

THE SEAL(S) AND SIGNATURE(S) APPLY ONLY TO THE DOCUMENT TO WHICH THEY ARE AFFIXED, AND EXPRESSLY DISCLAIM ANY RESPONSIBILITY FOR ALL OTHER PLANS, SPECIFICATIONS, ESTIMATES, REPORTS OR OTHER DOCUMENTS OR INSTRUMENTS RELATING TO OR INTENDED TO BE USED FOR ANY PART OR PARTS OF THE ARCHITECTURAL OR ENGINEERING PROJECT.



Webster University
Interdisciplinary Science Building

CANNONDESIGN

1100 Clark Avenue
St. Louis, Missouri 63102
T: 314.241.6250
F: 314.241.2570

William Tao & Associates, Inc.
MER/FP Engineer
7955 Manchester Road, Suite 125
St. Louis, MO 63143
314-884-7600

David Mason & Associates, Inc.
Structural & Civil Engineer
800 South Vandeventer Avenue
St. Louis, MO 63110
314.534.1053

Faith Group
Technology
3101 S. Hanley Rd, Suite 100
St. Louis, MO 63143
314.991.2229

Kuhmann Leavitt, Inc.
Environmental Graphics & Signage
7400 Pershing Ave
St. Louis, MO 63130
314.725.6616

KWA Architects
Architecture
9721 Litzinger Road
St. Louis, MO 63124
314.962.2560

Spellman Brady & Company
Interior Designer
8251 Maryland Avenue, Suite 300
St. Louis, MO 63105
314.862.0070

SWT Design
Landscape Architect
7722 Big Bend Blvd
St. Louis, MO 63119
314.644.5700

Webb Engineering Services, Inc.
Planning & Fire Protection
1400 S. 3rd Street, Suite 201
St. Louis, MO 63104
314.588.0600

GENERAL NOTES:


- DO NOT SCALE DRAWINGS. REFER TO ARCHITECTURAL PLANS AND ELEVATIONS FOR LOCATION AND ORIENTATION OF DEVICES. WHERE LOCATIONS ARE NOT INDICATED ON ARCHITECTURAL DRAWINGS, COORDINATE LOCATION AND ORIENTATION OF DEVICES IN FIELD WITH ARCHITECT PRIOR TO ROUGH-IN.
- ALL DEVICES SHOWN ARE NEW UNLESS NOTED OTHERWISE.
- ALL DEVICES TO REMAIN ARE INDICATED WITH A THIN SOLID LINE WEIGHT AND SUBSCRIPT "EX".
- CONTRACTOR SHALL VISIT PRIOR TO BID SUBMITTALS TO DETERMINE SITE CONDITIONS EFFECTING THE EXECUTION OF WORK. FAILURE TO BE ACQUAINTED WITH EXISTING CONDITIONS WILL NOT BE JUSTIFICATION FOR ADDITIONAL SERVICES.
- PROVIDE FACE PLATES ON ALL J-BOXES ABANDONED IN FINISHED FLOOR, WALL OR CEILINGS. COORDINATE COLOR AND FINISH WITH ARCHITECT. CONTRACTOR TO VERIFY QUANTITY IN THE FIELD.
- WHERE EXPOSED CONDUIT IS NOTED, CONTRACTOR SHALL IDENTIFY ROUTING IN FIELD AND OBTAIN ARCHITECT'S APPROVAL OF ROUTING PRIOR TO ROUGH-IN. EXPOSED CONDUIT SHALL BE ROUTED TIGHT TO STRUCTURE.
- ALL SINGLE PHASE BRANCH CIRCUITS SHOWN SHALL HAVE DEDICATED NEUTRALS TO MEET NEC SECTION 210.4 MULTI-WIRE BRANCH CIRCUIT REQUIREMENTS.
- REFER TO TECHNOLOGY DRAWINGS FOR CONDUIT ROUGH-IN OF DATA, VOICE AND A/V.

- ALL 120V BRANCH CIRCUITS ON THIS SHEET SHALL BE FED FROM PANEL 2NL1 UNLESS NOTED OTHERWISE.

KEYED NOTES

- E01** REFER TO EQUIPMENT DATA SCHEDULE FOR BRANCH CIRCUIT INFORMATION.
- E02** PROVIDE NEW RECEPTACLE FOR MONITOR, COORDINATE MOUNTING HEIGHT WITH ARCHITECTURAL ELEVATIONS AND TECHNOLOGY PLANS.
- E04** PROVIDE CONNECTION TO MOTORIZED PROJECTION SCREEN AND UP/DOWN CONTROLS.
- E06** OUTLET SHALL BE MOUNTED TO THE BACK SIDE OF THE TELECOMMUNICATION RACK AND FED FROM ABOVE. COORDINATE EXACT MOUNTING HEIGHT AND LOCATION WITH TELECOMMUNICATIONS CONTRACTOR PRIOR TO INSTALLATION.
- E07** OUTLET FOR RACK MOUNTED A/V EQUIPMENT. COORDINATE MOUNTING HEIGHT AND EXACT LOCATION WITH ARCHITECTURAL ELEVATIONS AND A/V DRAWINGS.
- E17** PROVIDE NEMA 6-30R, 30A-208V RECEPTACLE FOR PRINTER. CONTRACTOR SHALL VERIFY PRINTER PLUG TYPE WITH OWNERS REPRESENTATIVE PRIOR TO ROUGH-IN.
- E19** PROVIDE POWER AND FINAL CONNECTION TO ELECTRIC DOOR OPENER. COORDINATE POWER REQUIREMENTS WITH DOOR INSTALLER PRIOR TO ROUGH-IN.
- E20** PROVIDE POWER AND FINAL CONNECTION TO ELECTRIC DOOR OPENER CONTROLS. COORDINATE EXACT LOCATION WITH ARCHITECTURAL DRAWINGS PRIOR TO ROUGH-IN.
- E55** PROVIDE POWER TO BUILDING AUTOMATION SYSTEM PANEL. COORDINATE LOCATION WITH AUTOMATION CONTRACTOR.
- E59** PROVIDE NEW QUAD RECEPTACLE FLUSH MOUNTED IN CEILING FOR PROJECTOR. VERIFY EXACT LOCATION WITH ARCHITECTURAL AND A/V DRAWINGS.
- E61** PROVIDE A 2HR FIRE CLASSIFIED 2-GANG MULTI-SERVICE STEEL RECESSED FLOOR BOX EQUAL TO WIREMOLD CAT. NO. RF82S-FC WITH A BRASS FLANGED COVER CAT. NO. FP8TCBS-NA. THE FLOOR BOX SHALL HAVE ALL NECESSARY MOUNTING BRACKETS FOR (1) 20A DUPLEX RECEPTACLE, (1) GANG - DATA/VOICE (SEE TECHNOLOGY DRAWINGS FOR DEVICE TYPE), THE BOX SHALL BE INSTALLED PER MANUFACTURERS WRITTEN INSTRUCTIONS SO THAT THE COVER IS FLUSH WITH THE FLOOR.
- E63** PROVIDE A 2HR FIRE CLASSIFIED 4-GANG MULTI-SERVICE STEEL RECESSED FLOOR BOX EQUAL TO WIREMOLD CAT. NO. RF84S-FC WITH A BRASS FLANGED COVER CAT. NO. FP8TCBS-NA. THE FLOOR BOX SHALL HAVE ALL NECESSARY MOUNTING BRACKETS FOR (2) 20A DUPLEX RECEPTACLE, (1) GANG - DATA/VOICE (SEE TECHNOLOGY DRAWINGS FOR DEVICE TYPE), (1) GANG - A/V (SEE A/V DRAWINGS FOR DEVICE TYPES). THE BOX SHALL BE INSTALLED PER MANUFACTURERS WRITTEN INSTRUCTIONS SO THAT THE COVER IS FLUSH WITH THE FLOOR.
- E68** PROVIDE FIRE ALARM CONTROL MODULE TO RELEASE POWER TO ELECTRICALLY HELD OPEN FIRE DOOR UPON ACTIVATION OF ASSOCIATED SMOKE DETECTOR.
- E69** ALL 120V BRANCH CIRCUITS IN THIS ROOM SHALL BE FED FROM PANEL 2LL5.
- E70** PROVIDE NEMA L5-20R, 20A-120V TWIST LOCK RECEPTACLE FOR RACK MOUNTED PDU. COORDINATE EXACT LOCATION AND MOUNTING HEIGHT WITH TECHNOLOGY CONTRACTOR.
- E75** RECEPTACLES SHALL BE MOUNTED HORIZONTALLY, REFER TO ARCHITECTURAL PLANS AND ELEVATIONS.
- E76** PROVIDE A 2HR FIRE CLASSIFIED 4-GANG MULTI-SERVICE STEEL RECESSED FLOOR BOX EQUAL TO WIREMOLD CAT. NO. RF82S-FC WITH A BRASS FLANGED COVER CAT. NO. FP8TCBS-NA. THE FLOOR BOX SHALL HAVE ALL NECESSARY MOUNTING BRACKETS FOR (3) 20A STANDARD DUPLEX RECEPTACLES, NEMA 5-20R, (1) GANG - DATA/VOICE (SEE TECHNOLOGY DRAWINGS FOR DEVICE TYPE), THE BOX SHALL BE INSTALLED PER MANUFACTURERS WRITTEN INSTRUCTIONS SO THAT THE COVER IS FLUSH WITH THE FLOOR.

6	ASI-053	24 FEB 2017
5	ASI-036	30 NOV 2016
4	ASI-035	10 NOV 2016
3	ASI-017	14 OCT 2016
2	ADDENDUM 2-2	19 APRIL 2016
1	ADDENDUM 2-1	17 MAR 2016
-	ISSUED FOR CONSTRUCTION (BP2)	01 MAR 2016

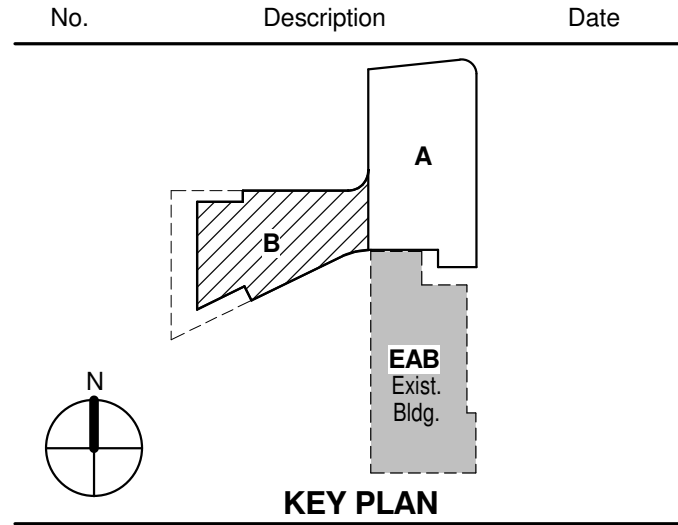


Drawing Title:

LEVEL 02 AREA B FLOOR PLAN - ELECTRICAL & AUXILIARY

Project No.: 04561.01 Checked by:

E0102.B

© Cannon Design 2015

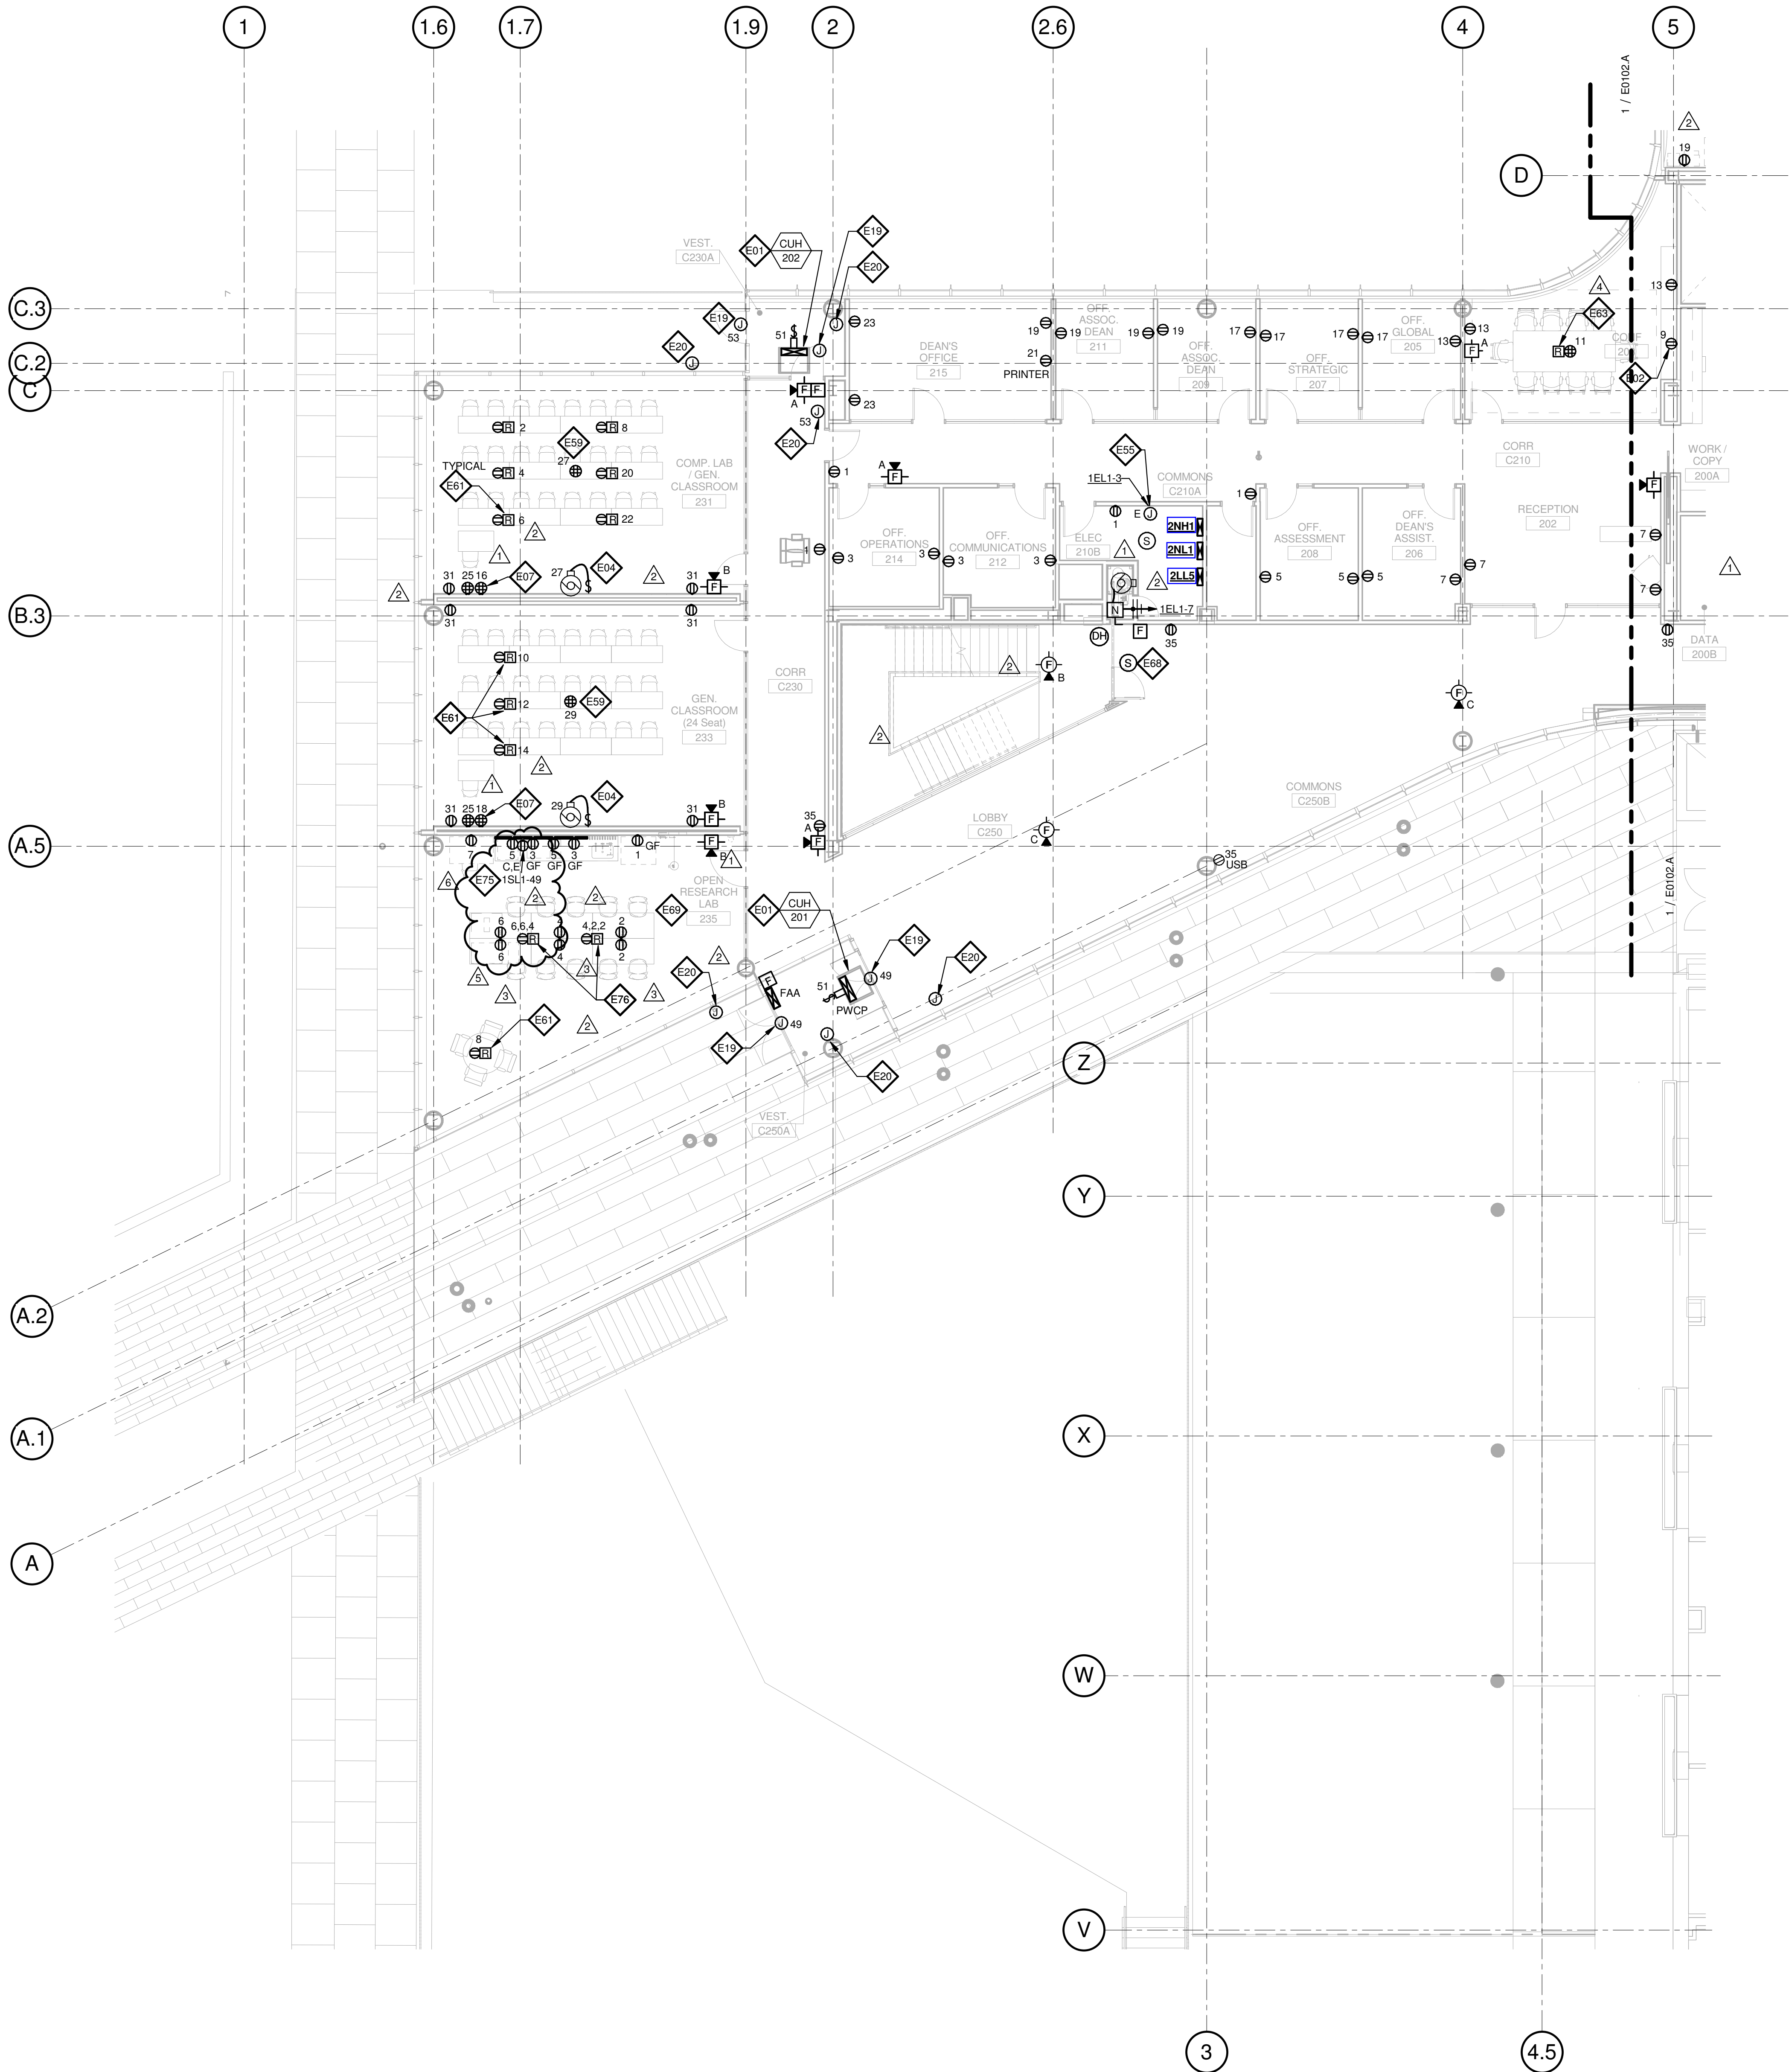

1 LEVEL 02 - AREA B - FLOOR PLAN - POWER AND AUXILIARY

1/8" = 1'-0"