

THE SEALS(S) AND SIGNATURE(S) APPLY ONLY TO THE DOCUMENT TO WHICH THEY ARE AFFIXED, AND EXPRESSLY DISCLAIM ANY RESPONSIBILITY FOR ALL OTHER PLANS, SPECIFICATIONS, ESTIMATES, REPORTS OR OTHER DOCUMENTS OR INSTRUMENTS RELATING TO OR INTENDED TO BE USED FOR ANY PART OR PARTS OF THE ARCHITECTURAL OR ENGINEERING PROJECT.



Webster University
Interdisciplinary Science Building

CANNONDESIGN

1100 Clark Avenue
St. Louis, Missouri 63102
T: 314.241.6250
F: 314.241.2570

William Tao & Associates, Inc.
MEP/FP Engineer
7955 Manchester Road, Suite 125
St. Louis, MO 63143
314-884-7600

David Mason & Associates, Inc.
Structural & Civil Engineer
800 South Vandeventer Avenue
St. Louis, MO 63110
314.534.1053

Faith Group
Technology

3101 S. Hanley Rd., Suite 100
St. Louis, MO 63143
314.591.2229

Kuhmann Leavitt, Inc.
Environmental Graphics & Signage
7400 Pershing Ave.
St. Louis, MO 63130
314.725.8616

KWA Architects
Architecture
3721 Litzinger Road
St. Louis, MO 63124
314.962.2560

Spellman Brady & Company
Interior Designer
8251 Maryland Avenue, Suite 300
St. Louis, MO 63105
314.862.0070

SWT Design
Landscape Architect
7722 Big Bend Blvd.
St. Louis, MO 63119
314.644.5700


Webb Engineering Services, Inc.
Planning & Fire Protection
1400 S. 3rd Street, Suite 201
St. Louis, MO 63104
314.588.0600

GENERAL NOTES:

- DO NOT SCALE DRAWINGS. REFER TO ARCHITECTURAL PLANS AND ELEVATIONS FOR LOCATION AND ORIENTATION OF DEVICES. WHERE LOCATIONS ARE NOT INDICATED ON ARCHITECTURAL DRAWINGS, COORDINATE LOCATION AND ORIENTATION OF DEVICES IN FIELD WITH ARCHITECT PRIOR TO ROUGH-IN.
- CONTRACTOR SHALL VISIT PRIOR TO BID SUBMITTALS TO DETERMINE SITE CONDITIONS EFFECTING THE EXECUTION OF WORK. FAILURE TO BE ACQUAINTED WITH EXISTING CONDITIONS WILL NOT BE JUSTIFICATION FOR ADDITIONAL SERVICES.
- PROVIDE FACE PLATES ON ALL J-BOXES ABANDONED IN FINISHED FLOOR, WALL OR CEILINGS. COORDINATE COLOR AND FINISH WITH ARCHITECT. CONTRACTOR TO VERIFY QUANTITY IN THE FIELD.
- WHERE EXPOSED CONDUIT IS NOTED, CONTRACTOR SHALL IDENTIFY ROUTING IN FIELD AND OBTAIN ARCHITECT'S APPROVAL OF ROUTING PRIOR TO ROUGH-IN. EXPOSED CONDUIT SHALL BE ROUTED TIGHT TO STRUCTURE.
- MINIMUM 0-10V CONTROL WIRE SIZE SHALL BE #18 (#16 FOR RUNS LONGER THAN 400'). DO NOT MIX 0-10V LOW VOLTAGE AND LINE VOLTAGE WIRING UNLESS APPROVED BY CONTROLS MANUFACTURER.
- ALL SINGLE PHASE BRANCH CIRCUITS SHOWN WITH COMMON NEUTRAL SHALL HAVE INDIVIDUAL 20A-1P CIRCUIT BREAKER. CONTRACTOR TO PROVIDE HANDLE TIES TO MEET NEC SECTION 210.4 MULTI-WIRE BRANCH CIRCUIT REQUIREMENTS. REFER TO DRAWINGS FOR CIRCUITS WITH DEDICATED NEUTRALS.
- SHADED FIXTURES AND FIXTURES NOTED WITH AN "E" ARE FOR EMERGENCY EGRESS. CONNECT FIXTURES TO LIFE SAFETY PANEL 1EH1.
- FIXTURES NOTED WITH "NL" ARE UN-SWITCHED NIGHT LIGHTS AND SHALL BE LEFT ON AFTER HOURS FOR WAY FINDING.
- WHERE A SWITCH WITH A "D" IS CALLED OUT, PROVIDE LUTRON DIVA 0-10V WALLBOX DIMMER WITH INTEGRAL RELAY. COORDINATE DIMMER VOLTAGE WITH CIRCUIT. WHERE A "3D" IS CALLED OUT, CONFIGURE DIMMER FOR 3-WAY DIMMING.
- CONNECT NON-EMERGENCY 277V LIGHTING ON THIS FLOOR TO PANEL 4NH1. CONNECT SHADES TO 120V PANEL SERVING LAB.

KEYED NOTES


- L03** THE LIGHTING CONTROLS IN THIS ROOM ARE CONNECTED TO THE BUILDING LIGHTING CONTROL SYSTEM.
- L09** PROVIDE SEPARATELY CONTROLLED TYPE SA LINEAR LED FIXTURE, MOUNTED TO AN ARCHITECTURAL CHANNEL WITHIN WINDOW NICHE. LIGHTING FEATURE SHALL EXTEND FROM 3RD FLOOR TO FOURTH FLOOR. SEE THIRD AND FOURTH FLOOR PLANS FOR CONTINUATION. PRELIMINARY OVERALL LENGTHS ARE INDICATED IN PARENTHESIS. COORDINATE FINAL LENGTHS WITH BUILT ROOM DIMENSIONS AND PROVIDE A CONTINUOUS FIXTURE FROM WALL TO WALL. ALLOW A 3" GAP BETWEEN WALL AND START/END OF FIXTURE. REFER TO DETAIL 1 ON SHEET A0841 FOR MOUNTING CONFIGURATION.
- L13** PROVIDE SQUARE-D AUTOMATIC LOAD CONTROL RELAY (OR APPROVED EQUAL) TO CONTROL SWITCHED LIFE SAFETY LIGHTS IN THIS ROOM. CONFIGURE RELAY TO ENSURE LIGHTS ENERGIZE UPON LOSS OF NORMAL POWER. PROVIDE DIMMING RELAY WHERE A DIMMER CONTROLS THE LIGHTS.
- L20** CONNECT 120 VOLT, TYPE UB4, MAGNETICALLY MOUNTED UNDERCABINET LIGHTING TO DEDICATED LIGHTING CIRCUIT IN OVERHEAD CARRIER. ROUTE CIRCUIT VIA LIGHTING CONTROL SYSTEM. COORDINATE REMOTE DRIVER LOCATION WITH FURNITURE. PROVIDE ONE REMOTE DRIVER PER MOVABLE TABLE.
- L21** PROVIDE 120 VOLT CIRCUIT FOR MOTORIZED SHADES. COORDINATE WIRING REQUIREMENTS AND LOCATIONS WITH SHADE VENDOR.
- L22** PROVIDE MOTORIZED SHADE SYSTEM CONTROL KEYPAD AND CONFIGURE TO OPERATE MOTORIZED SHADES. REFER TO APPROVED SHOP DRAWINGS FOR SYSTEM WIRING.
- L37** COORDINATE LOCATION OF ELEVATOR SHAFT LIGHTS AND SWITCH WITH ELEVATOR EQUIPMENT.

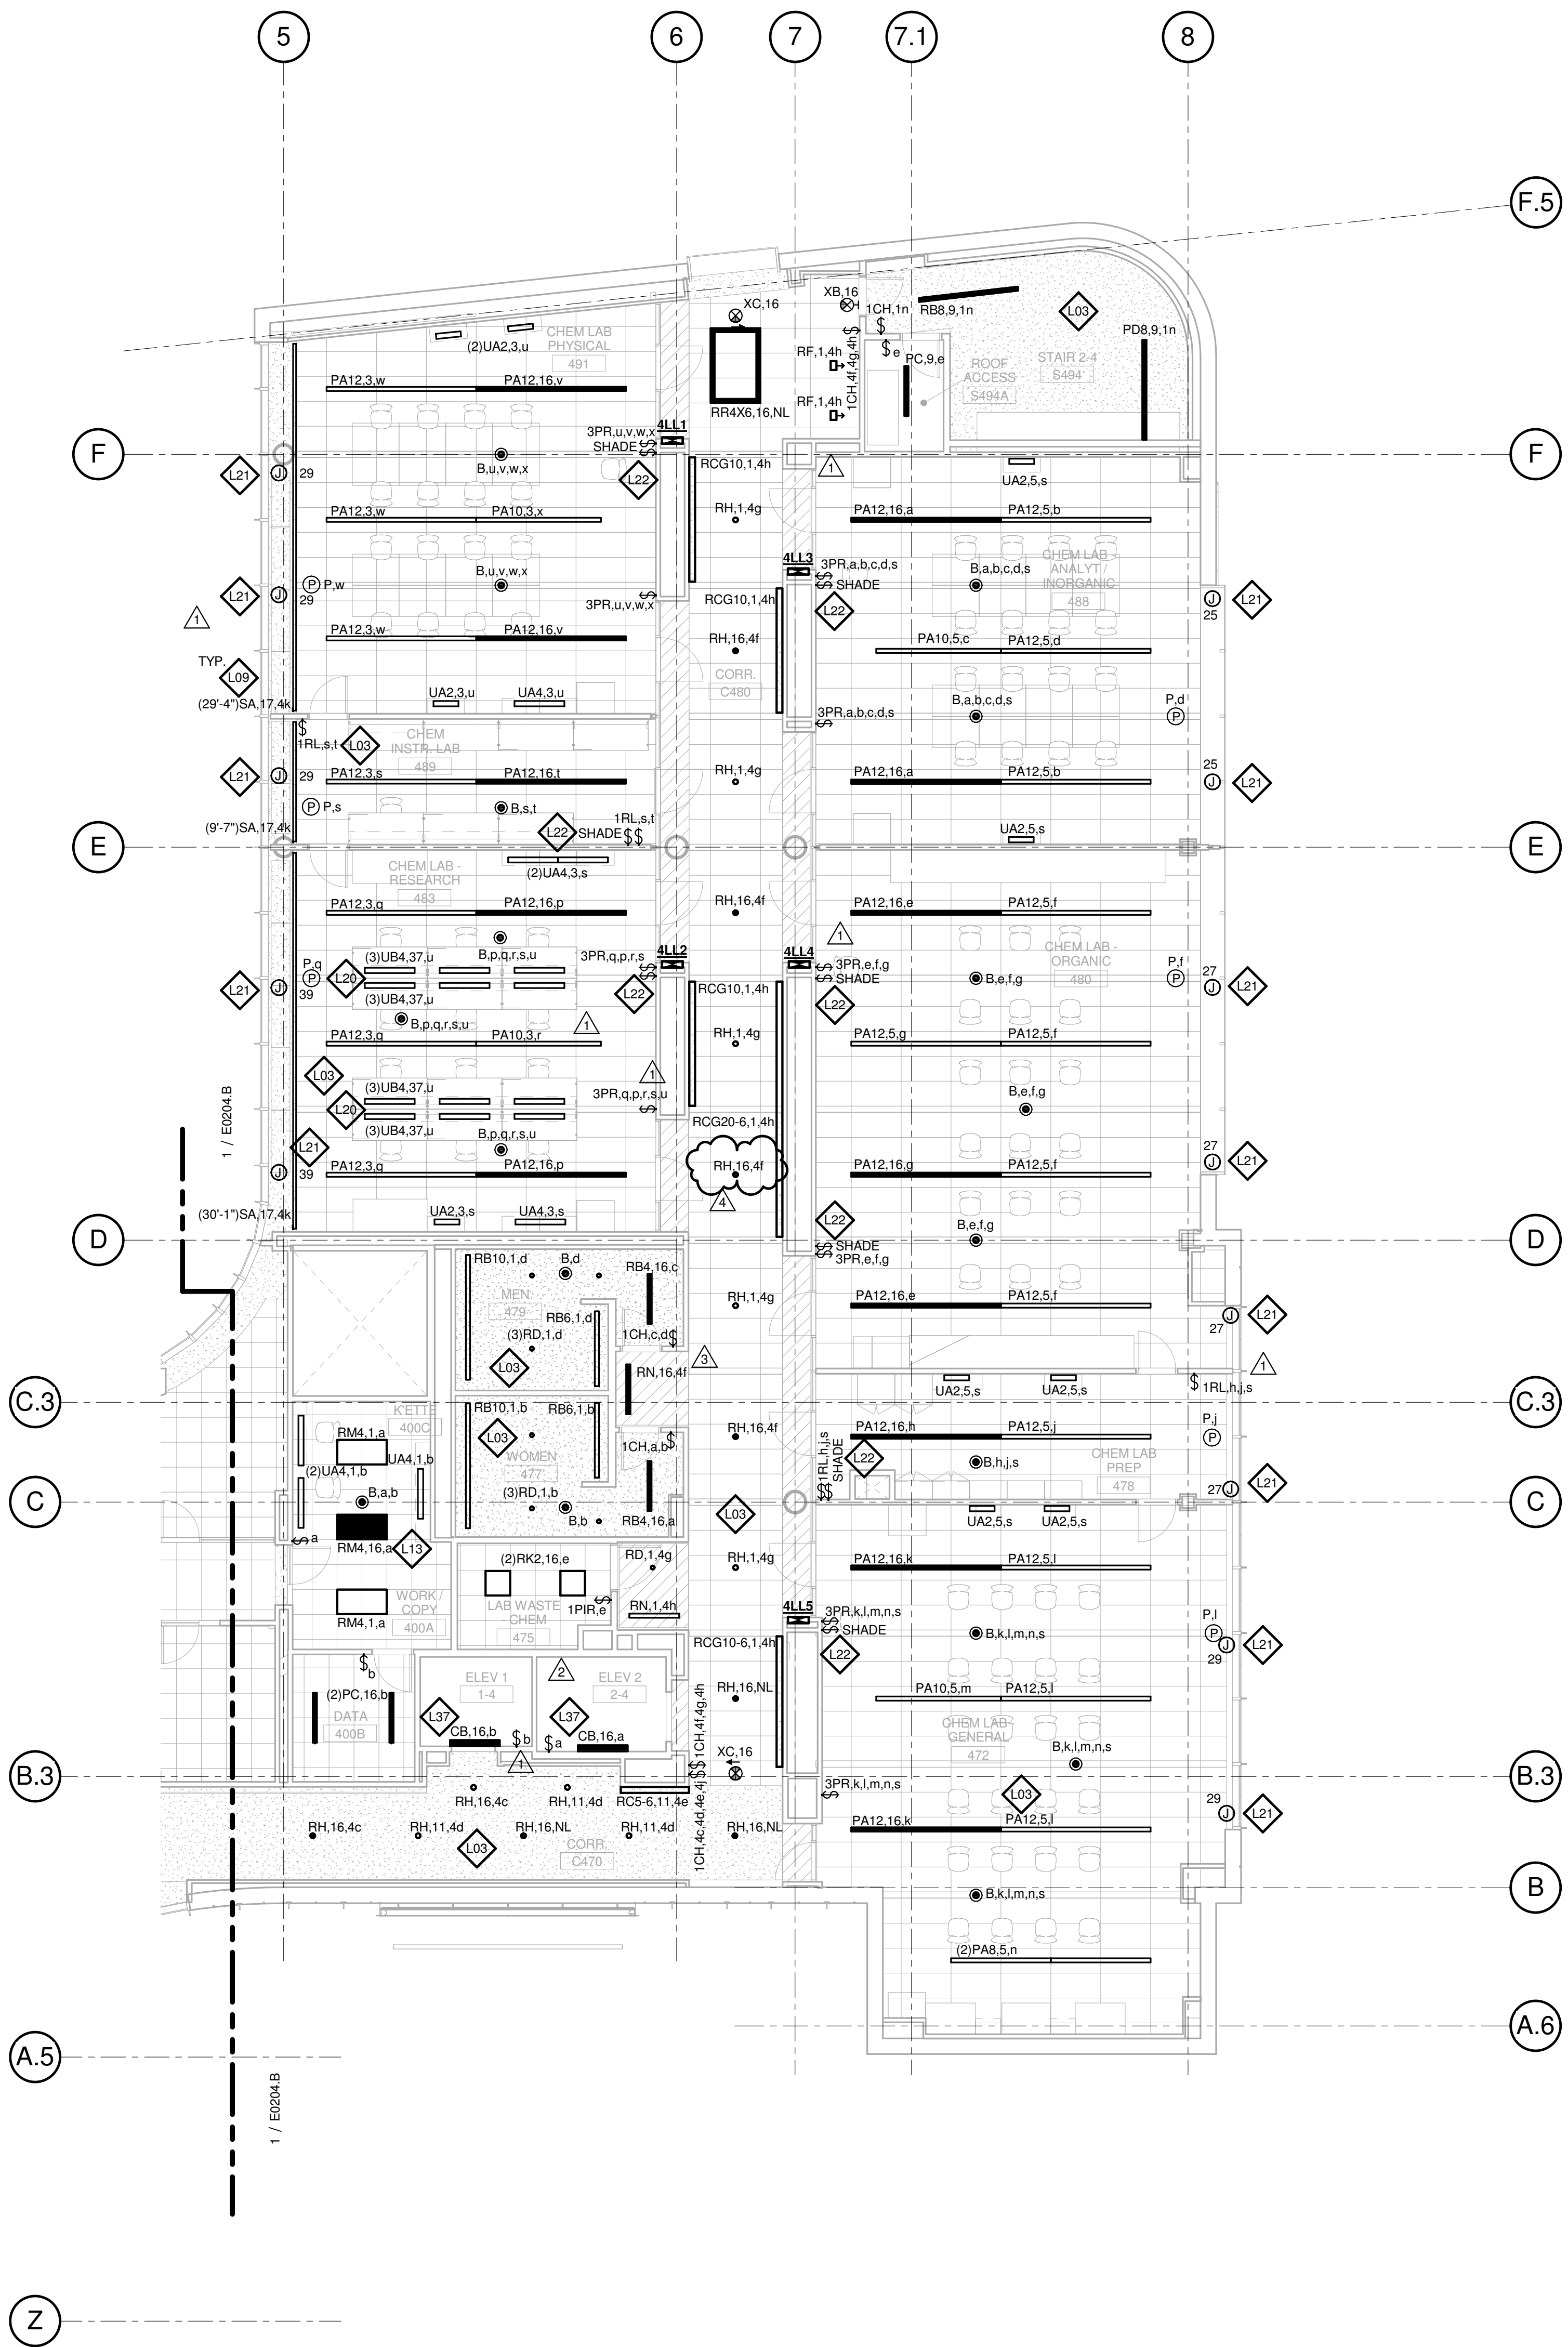

LEVEL 04 - AREA A - LIGHTING PLAN

1/8" = 1'-0"

4	ASI-046	16 JAN 2017
3	ASI-039	21 DEC 2016
2	ASI-001	08 JULY 2016
1	ADDENDUM 2-2	19 APRIL 2016
-	ISSUED FOR CONSTRUCTION (BP2)	01 MAR 2016

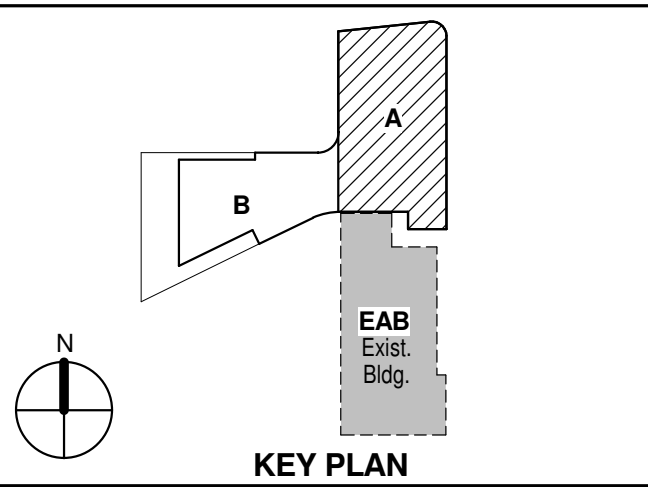

Drawing Title:

LEVEL 04 AREA A FLOOR PLAN - LIGHTING

Project No.: 04561.01 Checked by:

E0204.A