

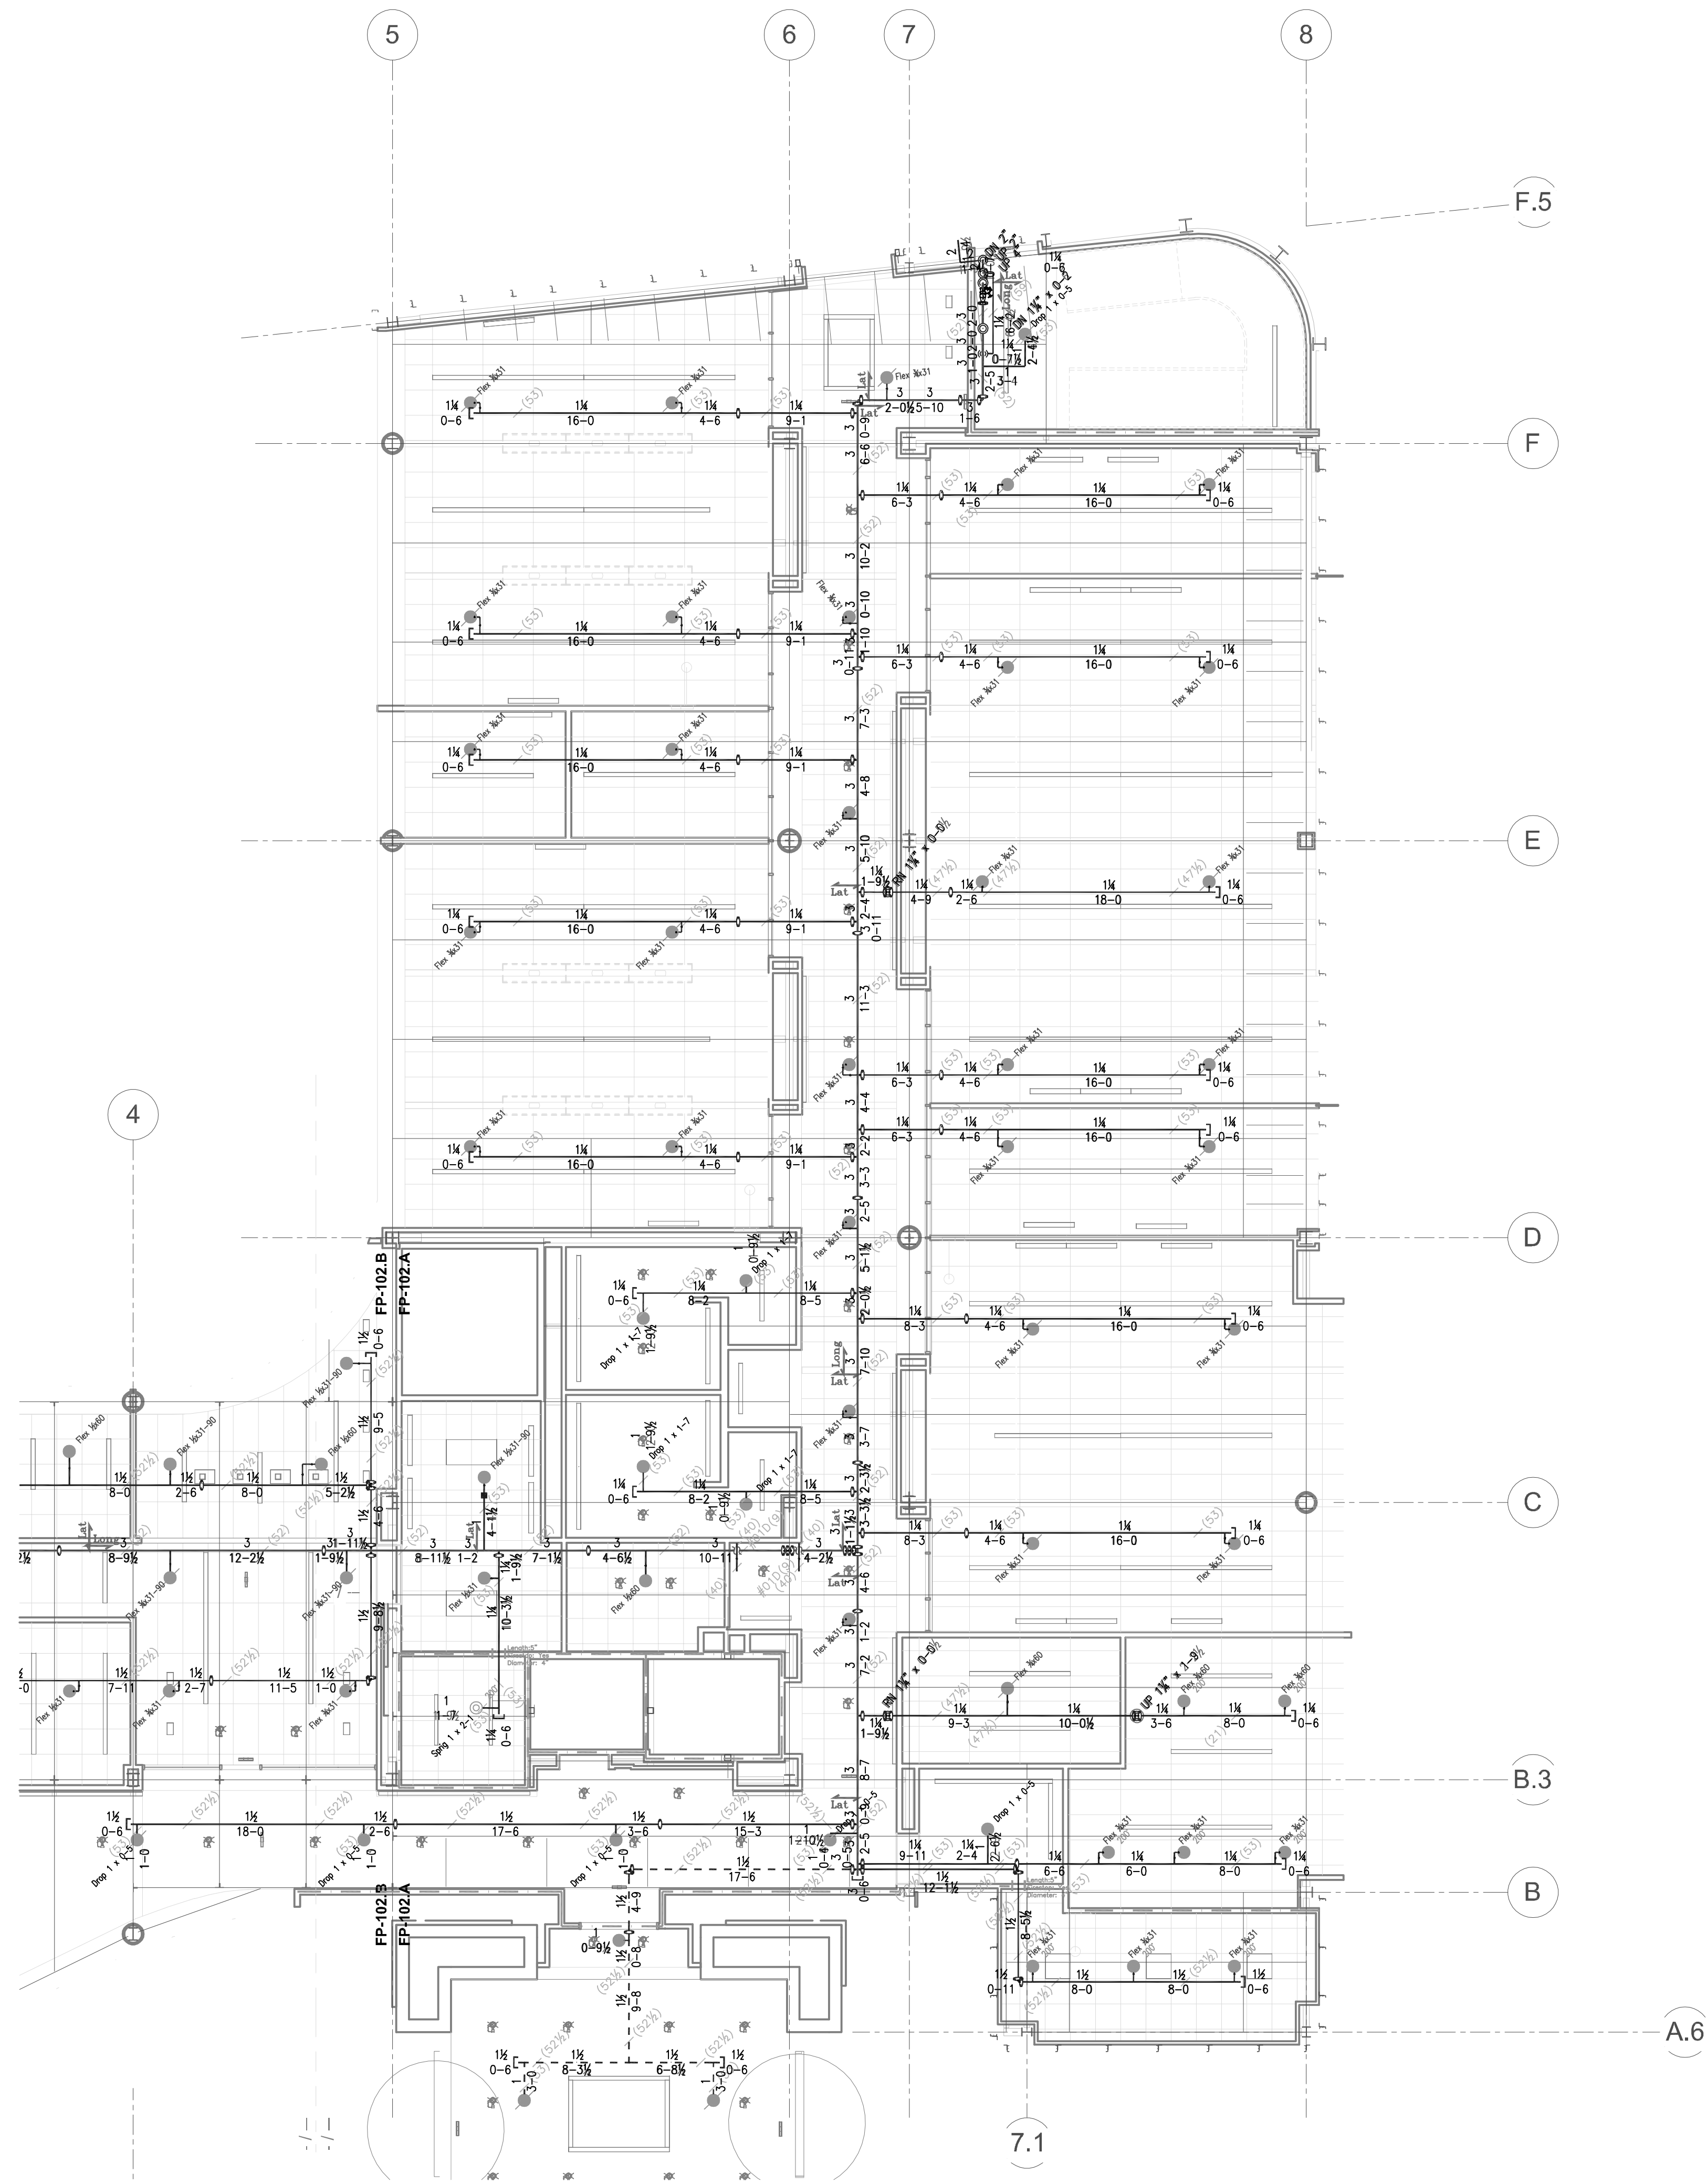
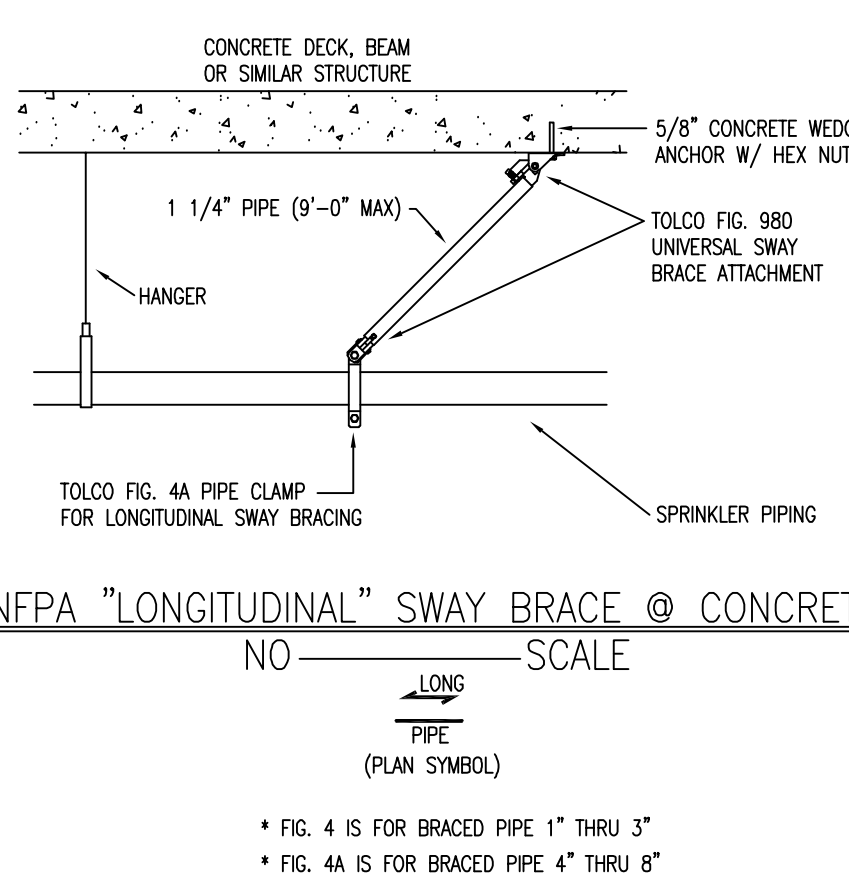
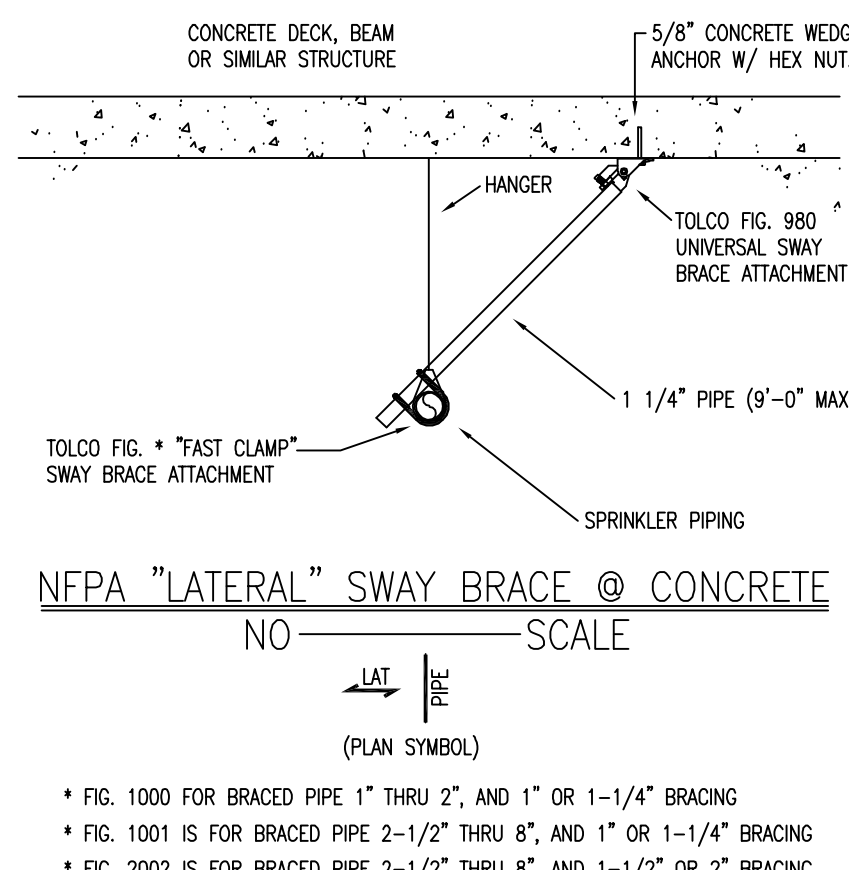
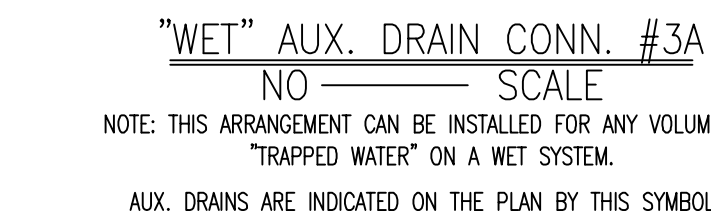
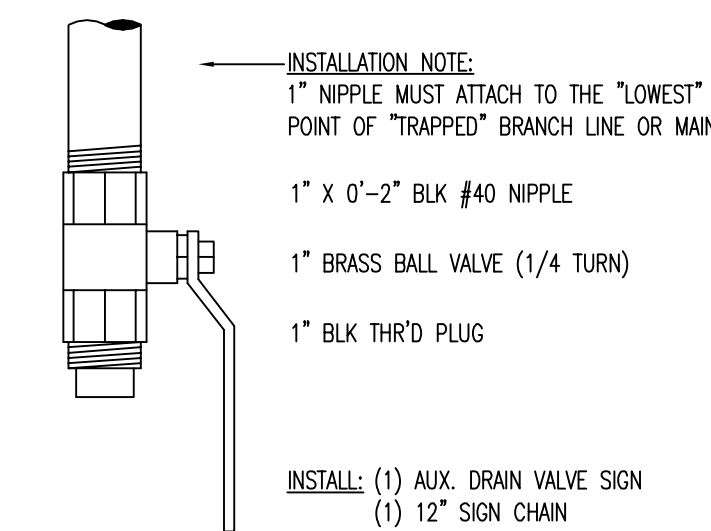
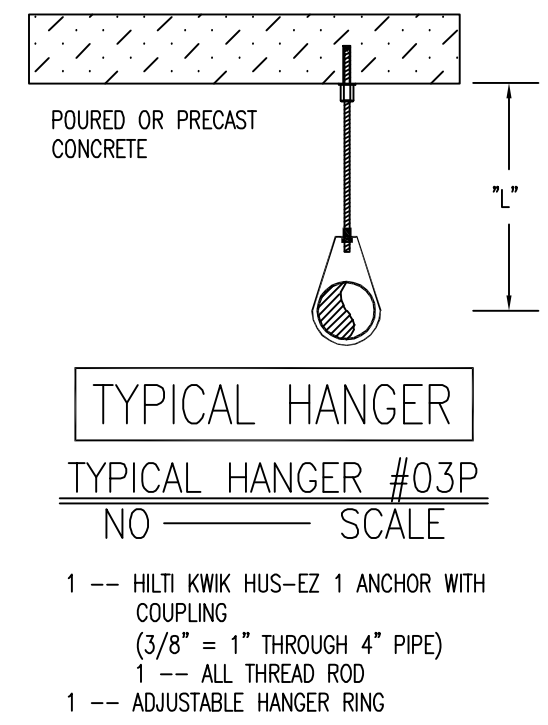


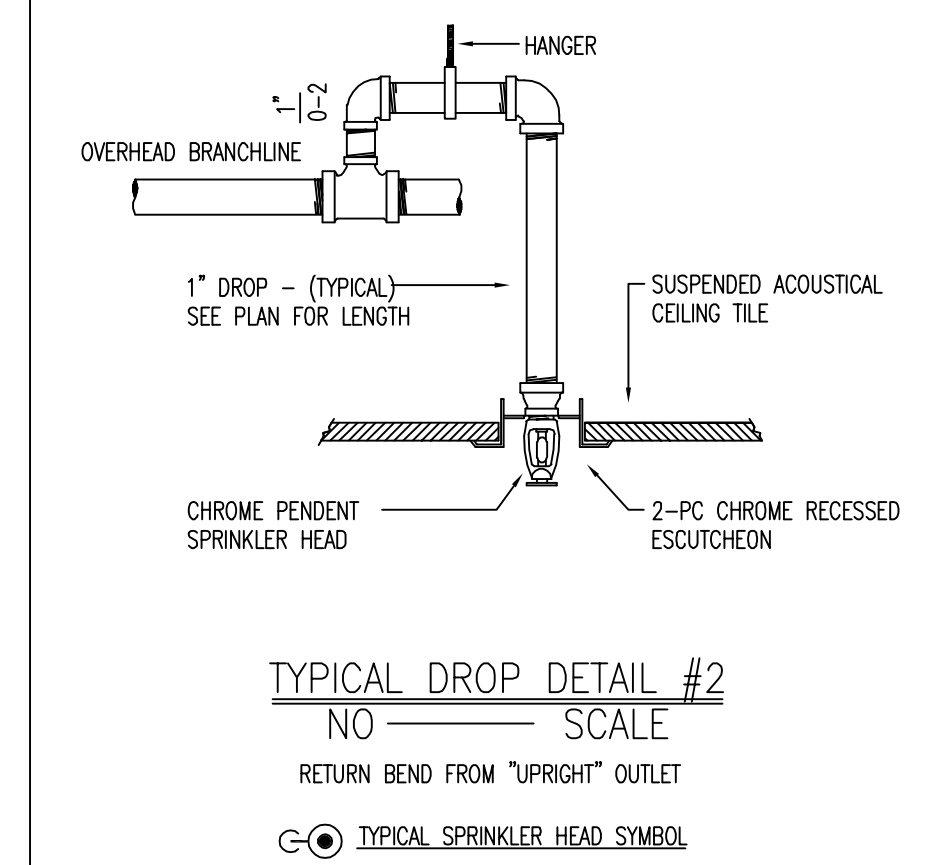

AUTOMATIC SPRINKLER SYSTEM PLAN
SCALE 1/8" = 1'-0"

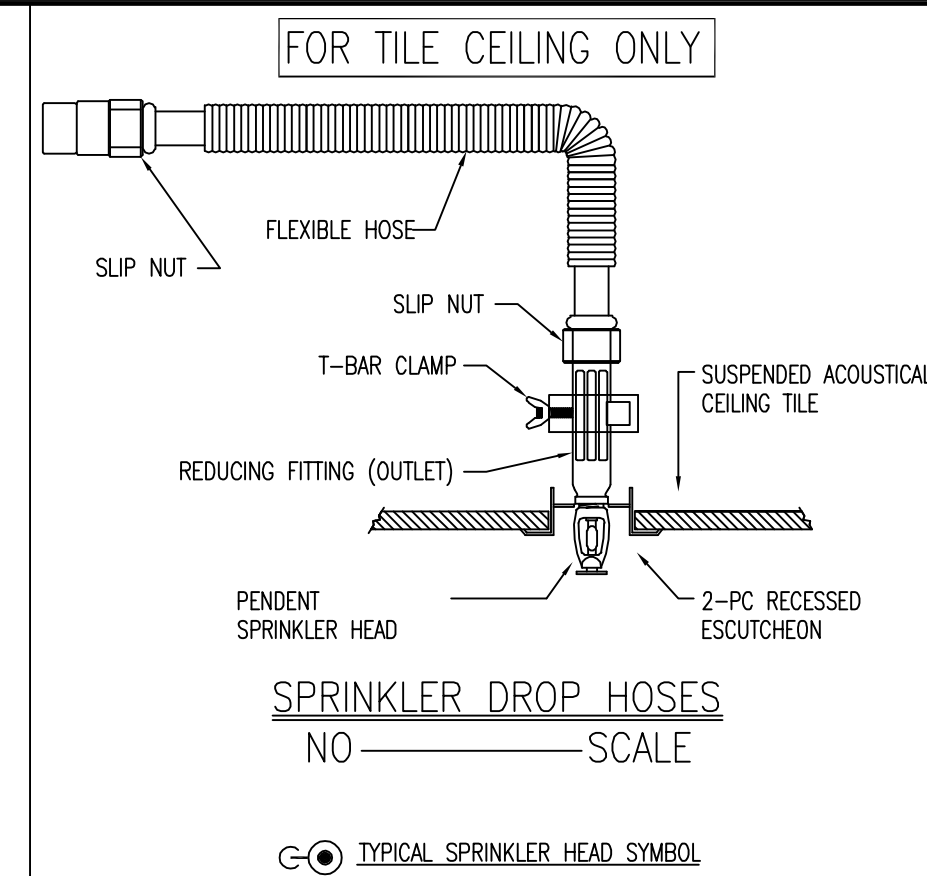

"AS-BUILTS"

08-01-2017


REV	DATE	REVISION DESCRIPTION
1	08/05/16	FW SCOPE REVIEW
2	10/26/16	PERMIT SET
3	12/06/16	INSTALLATION SET
4		
5		
6		
100		

The design information and data contained on this electronic media is provided to you as an instrument of service, protected by copyright law, and intended for use and reference relative only to the specific project they describe. J. F. Ahern Co. explicitly assumes no responsibility or liability for any other use of these electronic files whatsoever. The electronic files may not be copied, modified or released to a third party without the direct written permission of J. F. Ahern Co. Further, because transmission errors and read/write errors can occur and because electronic media stored can be modified by other parties intentionally or otherwise without notice of said modification, J. F. Ahern Co. cannot guarantee the accuracy of these files.





J. F. AHERN CO.
FIRE PROTECTION CONTRACTORS
2675 Scott Ave., Suite C
St. Louis, MO 63103-3047
(314) 535-4544 p (314) 535-0144 f
www.jfahern.com

KEYPLAN

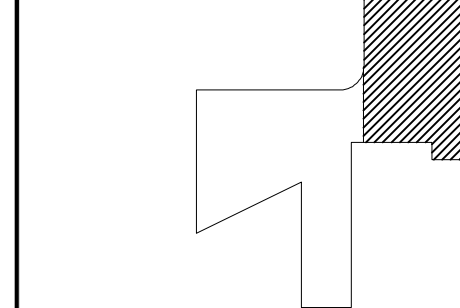

WEBSTER UNIV - INTER. SCIENCE BUILDING
8274 BIG BEND BLVD.
WEBSTER GROVES, MO

FIRE PROTECTION PLAN - LEVEL 2 - AREA A

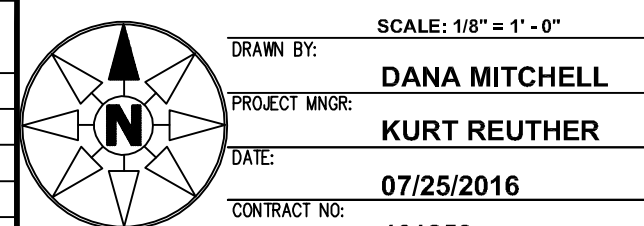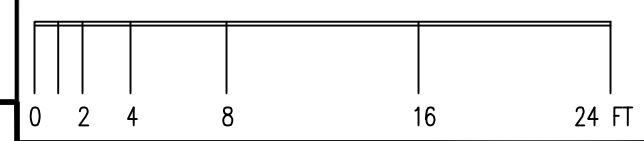

CONSTRUCTION DOCUMENTS
FP-102.A

SPRINKLERS											
MAKE / VENDOR	MODEL	SIN	TYPE	RESPONSE TYPE	THREAD SIZE	NOM. "K"	CALC'D COVERAGE	DEFLECT. DISTANCE	TEMP.	FINISH	ESC.
Viking	M	VK300	UPR	QR	1/2"	5.6	225 SQ FT	1-12"	155	BRZ	N/A
Viking	M	VK350	UPR	QR	3/4"	8.0	130 SQ FT	1-12"	200	BRZ	N/A
Viking	EC	VK532	UPR	QR	3/4"	11.2	400 SQ FT	1-12"	200	BRZ	N/A
Viking	MIRAGE	VK462	PND	QR	1/2"	5.6	225 SQ FT	1-12"	155	WHI	CONCLD
Viking	MIRAGE	VK464	PND	QR	3/4"	8.0	130 SQ FT	1-12"	200	WHI	CONCLD
Viking	MIRAGE EC	VK634	PND	QR	3/4"	8.0	400 SQ FT	1-12"	155	WHI	CONCLD
RELIABLE	G5-S6 DRY	RA5114	PND	QR	1"	5.6	225 SQ FT	1-12"	155	WHI	CONCLD
Viking	M	VK305	HSW	QR	1/2"	5.6	196 SQ FT	4-6"	200	BRZ	N/A
TOTAL SPRINKLERS ON THIS CONTRACT: 560											TOTAL SPRINKLERS ON THIS SHEET: 55