

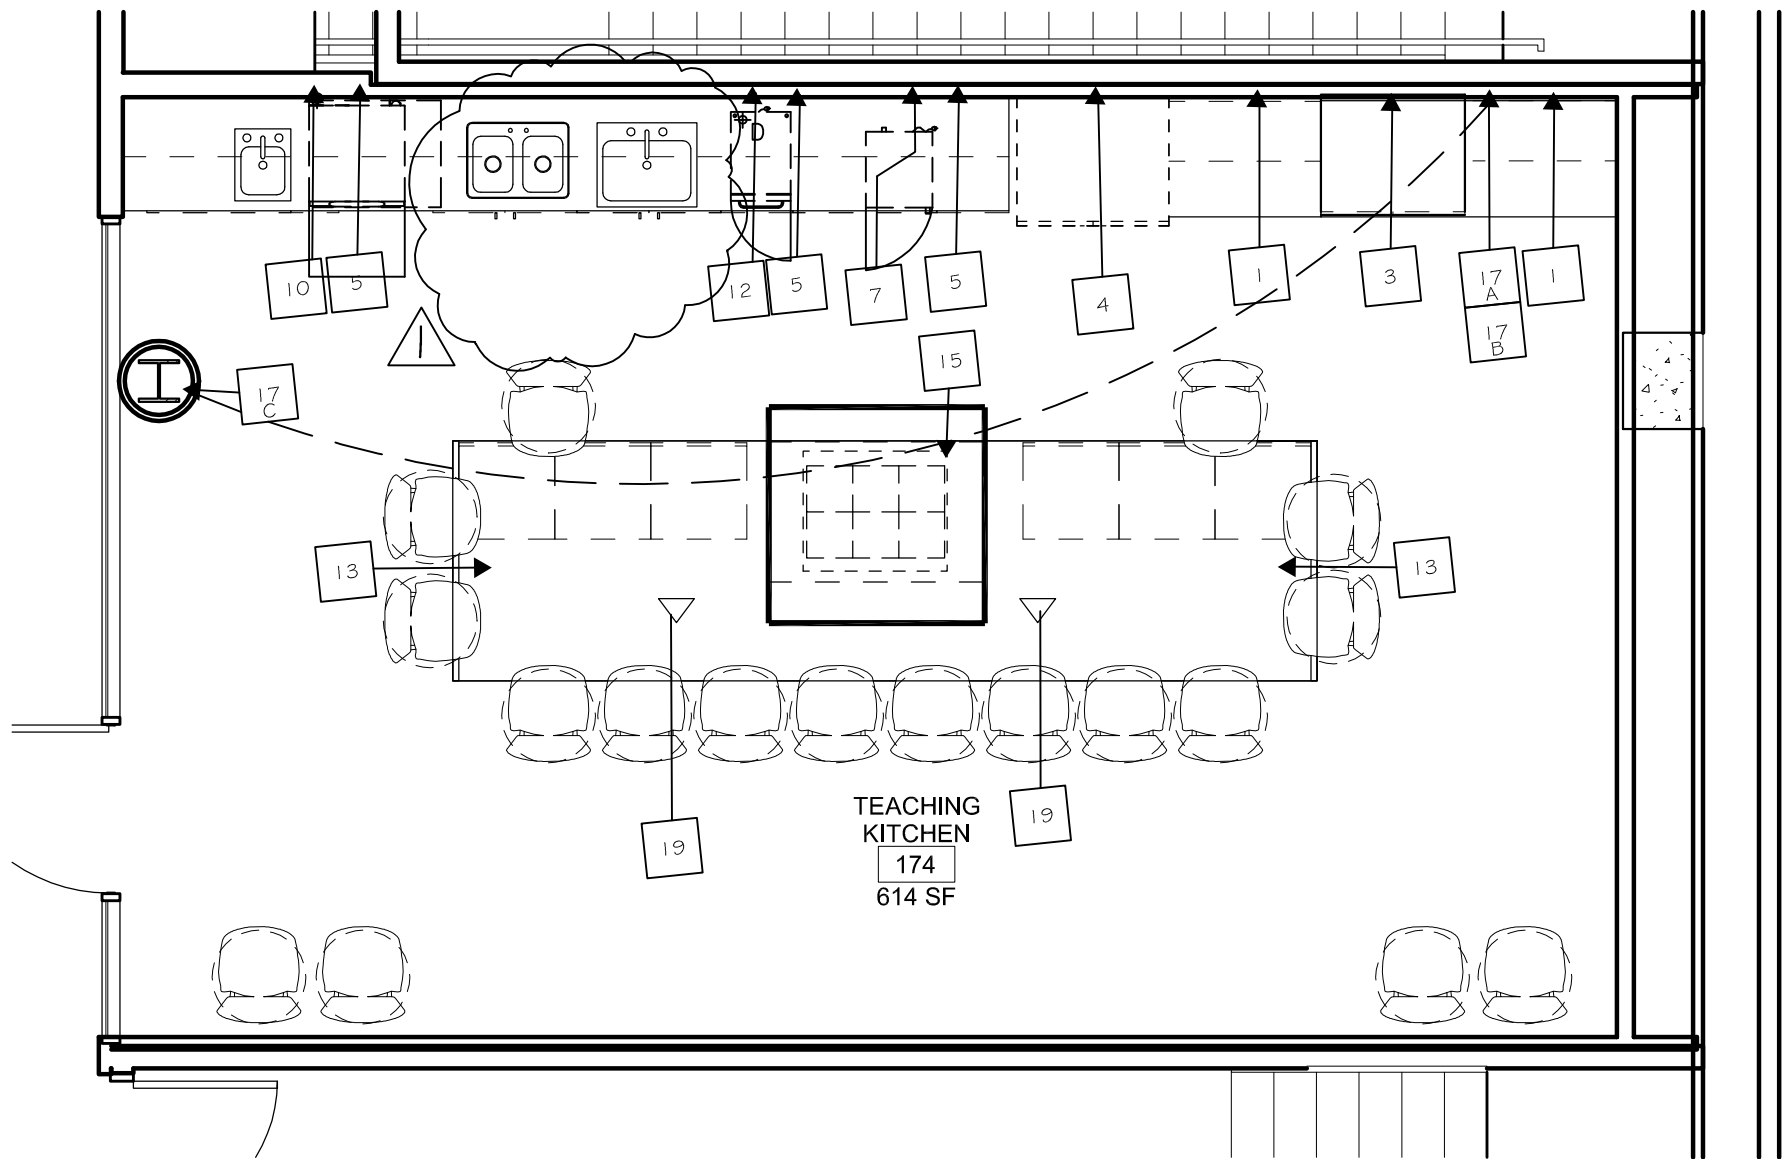


ELECTRICAL SCHEDULE									
CONN. NO.	VOLTAGE	PHASE	AMPS	K.W. LOAD	CONN. TYPE	HGT. A.F.F.	COMMENTS		
1	115	1	20	1.92	D.R.	4'-0"	CONVENIENCE OUTLET		
3	240	1	25.8		J.B.	4'-0"	VERIFY - EQUIPMENT SUPPLIED BY OTHERS		
4	115	1	20	1.92	D.R.	4'-0"	VERIFY - EQUIPMENT SUPPLIED BY OTHERS		
5	115	1	20	1.92	D.R.	4'-0"	CONVENIENCE OUTLET		
9	115	1	17.7	1.92	S.R.	6'-6"	VERIFY - EQUIPMENT SUPPLIED BY OTHERS		
11	240	1	39.6		S.R.	4'-6"	VERIFY - EQUIPMENT SUPPLIED BY OTHERS		
12	115	1	5		D.R.	1'-6"	ELECT. CONTR. SHALL CONNECT TO J-BOX FOR PRE-WIRED CONVENIENCE OUTLETS MOUNTED UNDER TOP OF TABLE BY KEC		
13	115	1	20	1.92	S.C.	1'-6"	VERIFY - EQUIPMENT SUPPLIED BY OTHERS		
14	115	1	5		J.B.	4'-0"	ELECT. CONTR. SHALL CONNECT TO J-BOX ON TOP OF HOOD FOR PRE-WIRED HOOD LIGHT SWITCH		
15	115	1	15		J.B.	9'-0"	ELECT. CONTR. SHALL PROVIDE 20 AMP 24 HR DEDICATED CIRCUIT FOR HOOD FIRE PROTECTION SYSTEM		
17A	115	1	20	1.92	J.B.	9'-0"	ELECT. CONTR. SHALL INNERCONNECT EXHAUST FANS AND MAKE-UP AIR FANS TO MICRO SWITCH IN FIRE PROTECTION CABINET		
17B					J.B.	9'-0"	ELECT. CONTR. SHALL PROVIDE J-BOX AND EMPTY CONDUIT IN WALL FOR REMOTE MANUAL PULL STATION - SEE DETAIL THIS SHEET		
17C					J.B.	4'-0"	VERIFY REQUIREMENTS AND LOCATIONS FOR CAMERA AND MONITOR EQUIPMENT		
19	115	1	20	1.92	D.R.	9'-0"			

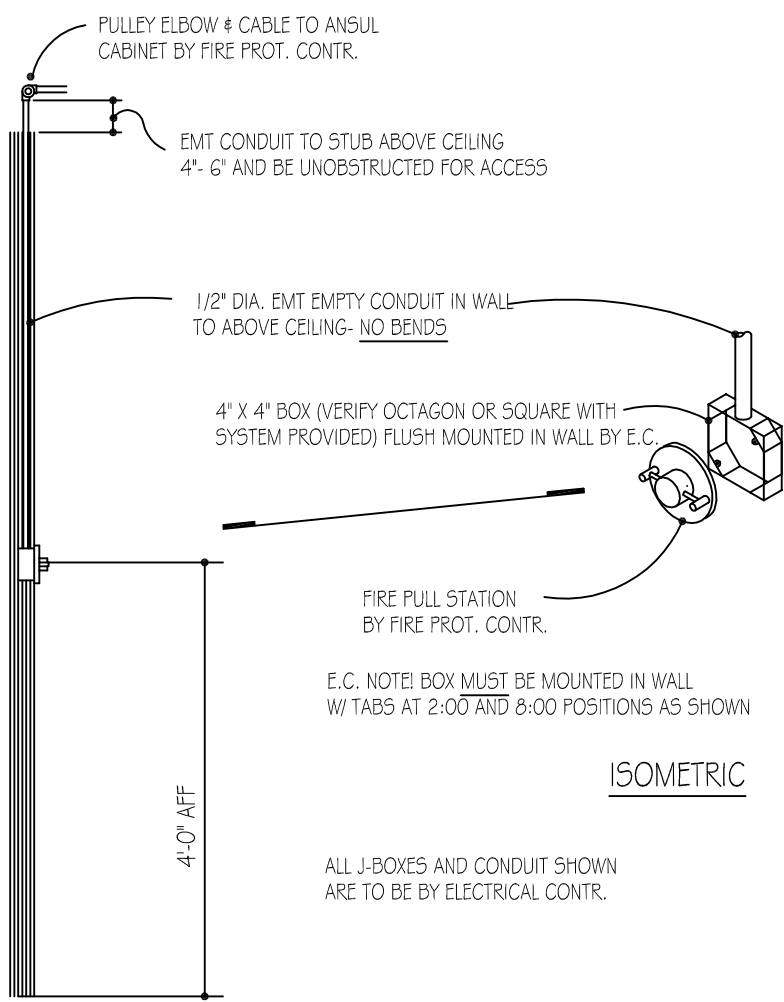


FOODSERVICE EQUIPMENT SPOT ELECTRICAL PLAN
SCALE: 1/4" = 1'-0"

PLUMBING SCHEDULE									
CONN. NO.	HOT WATER	COLD WATER	DIRECT WASTE	IN-DIRECT WASTE	GAS SIZE	GAS MBTU/S	CONN. TYPE	HGT. A.F.F.	COMMENTS
4	1/2"	1/2"					S.O.	4'-0"	FOR BUILT IN ICE MAKER ON UNIT
8	1/2"	1/2"					S.O.	1'-6"	
11	1/2"	1/2"					S.O.	1'-6"	
12	1/2"	1/2"					S.O.	1'-6"	
13	3/4"	1/2"					S.R.	4'-0"	PLBG. CONTR. SHALL PROVIDE 1.0 DEGREE H.W. TO DISH MACHINE
14	1/2"	1/2"					3" HUB	4'-0"	PLBG. CONTR. SHALL PIPE FROM DRAIN ON EQUIPMENT TO HUB DRAIN
15	1/2"	1/2"					S.O.	1'-6"	
16	1/2"	1/2"					S.O.	1'-6"	
17	1/2"	1/2"					S.O.	1'-9"	PLBG. CONTR. SHALL PIPE THRU FILTER IN CABINET BASE - VERIFY
18	1/2"	1/2"					S.O.	1'-6"	PLBG. CONTR. SHALL PIPE TO DRAIN AT SINK
19	3/4"	3/4"					S.U.	2'-0"	VERIFY - UNIT PROVIDED BY OTHERS

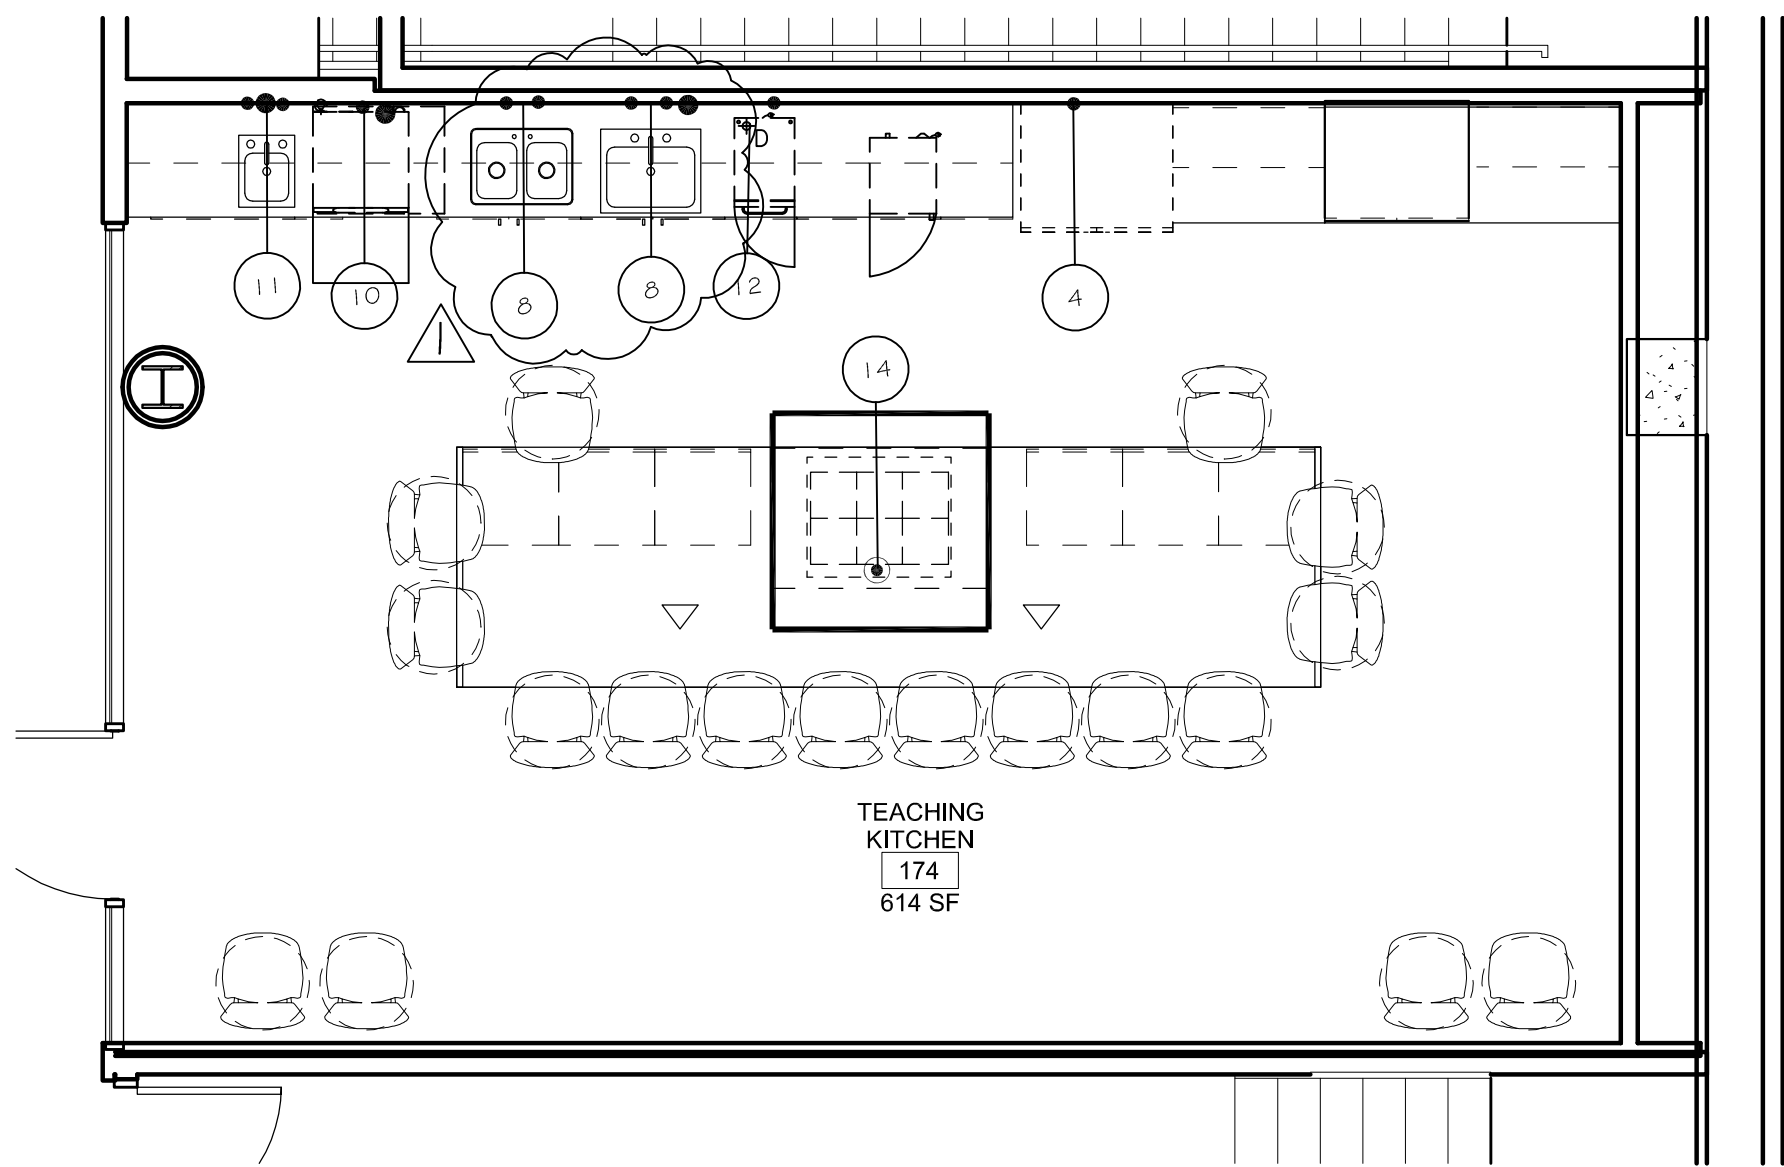

FOODSERVICE EQUIPMENT SPOT PLUMBING PLAN
SCALE: 1/4" = 1'-0"

EQUIPMENT SCHEDULE			
ITEM NO.	QTY.	DESCRIPTION	REMARKS
1	1 LOT	BACK COUNTERS	BY G.C.
2	1 LOT	WALL CABINETS	BY G.C.
3	1	DOUBLE OVFN	BY G.C.
4	1	REFRIGERATOR/FREEZER	BY G.C.
5	1 LOT	BACK COUNTERS	BY G.C.
6	1 LOT	WALL CABINETS	BY G.C.
7	1	MICROWAVE	BY G.C.
8	2	DROP IN SINKS	BY PLUMBER
9	1	SPARE NUMBER	
10	1	DISH WASHER - UNDER COUNTER	HIGH TEMP WITH BUILT IN BOOSTER HEATER
11	1	DROP IN HAND SINK	BY PLUMBER
12	1	UNDER COUNTER ICE MACHINE	BY G.C.
13	1	ISLAND COUNTER	BY G.C.
14	1	DROP IN COOK TOP	BY G.C.
15	1	ISLAND HOOD	BY HVAC
16	1	DUCT AND FAN	
17	1	FIRE PROTECTION SYSTEM	LOCATED IN WALL CABINET
18	1 LOT	FURNITURE	BY G.C.
19	2	CAMERAS AND DIGITAL SCREENS	BY G.C.

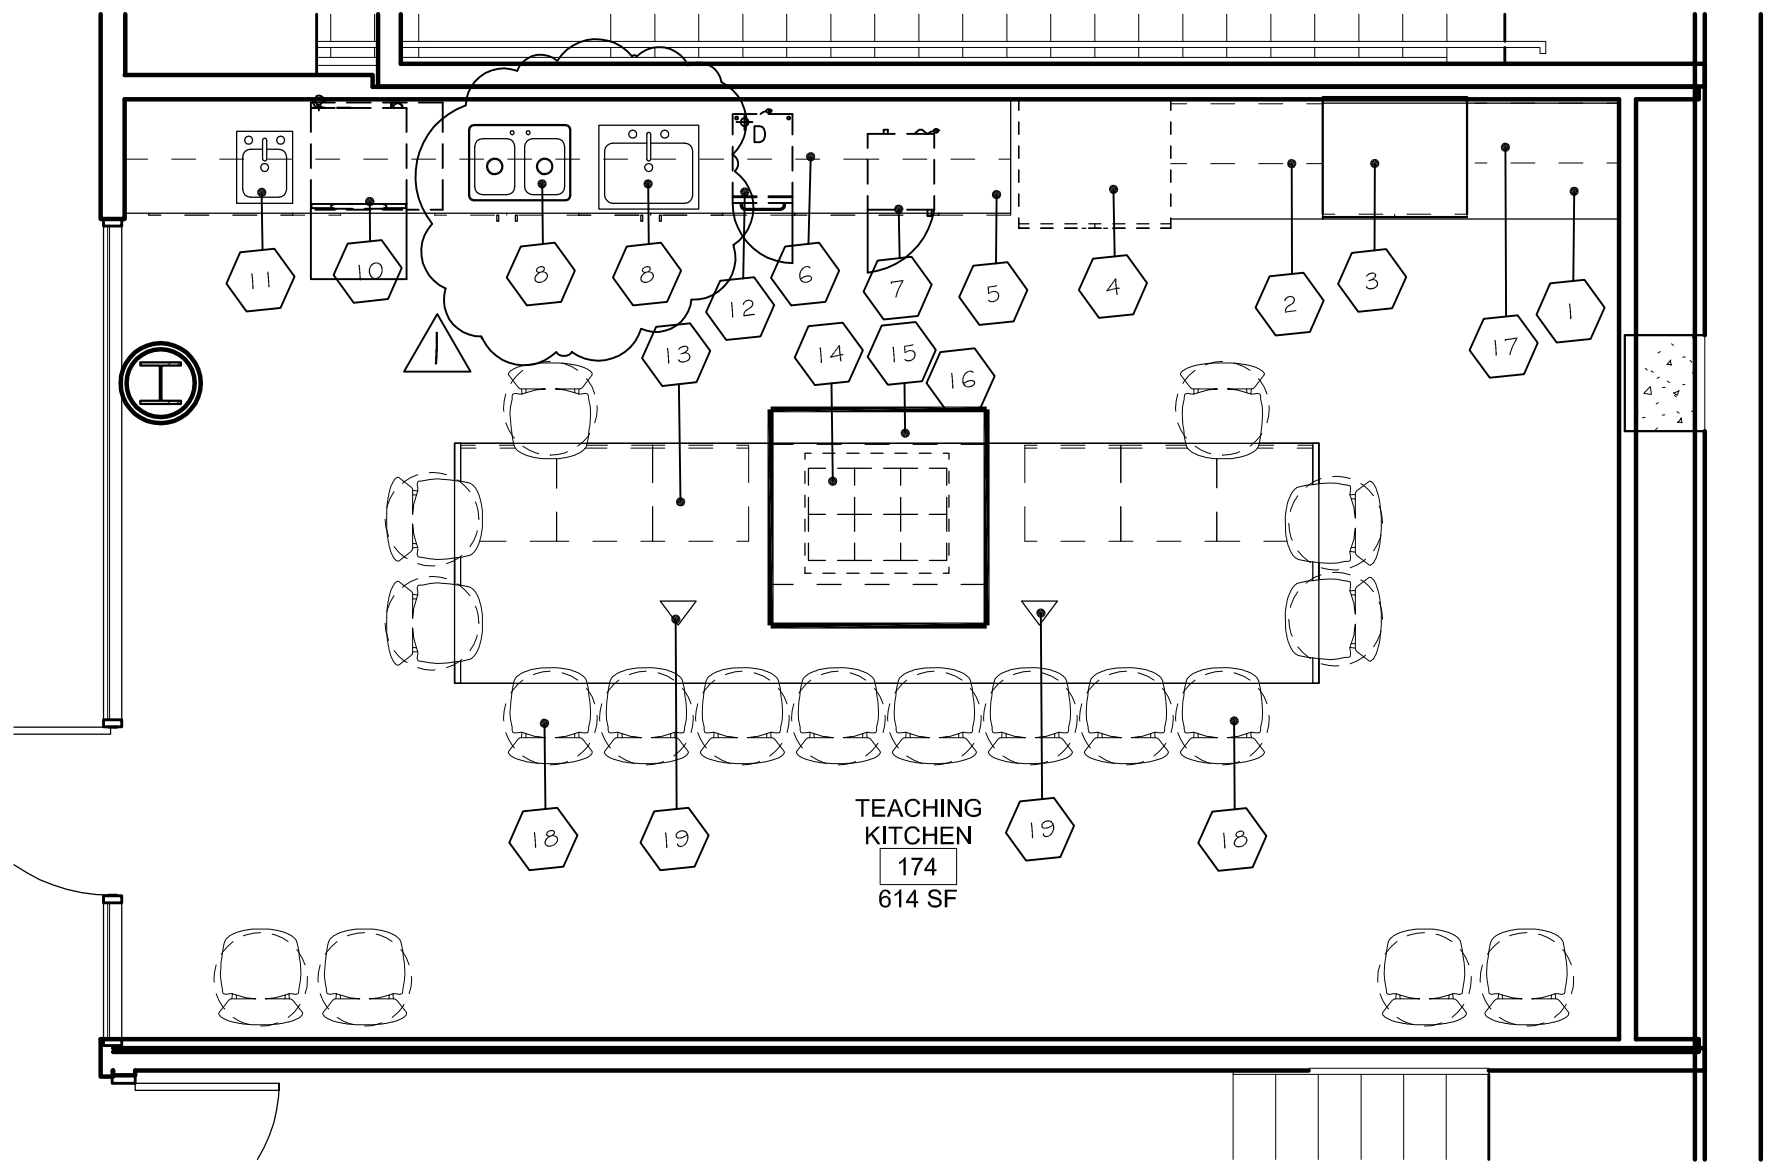

FOODSERVICE EQUIPMENT FLOOR PLAN
SCALE: 1/4" = 1'-0"

