



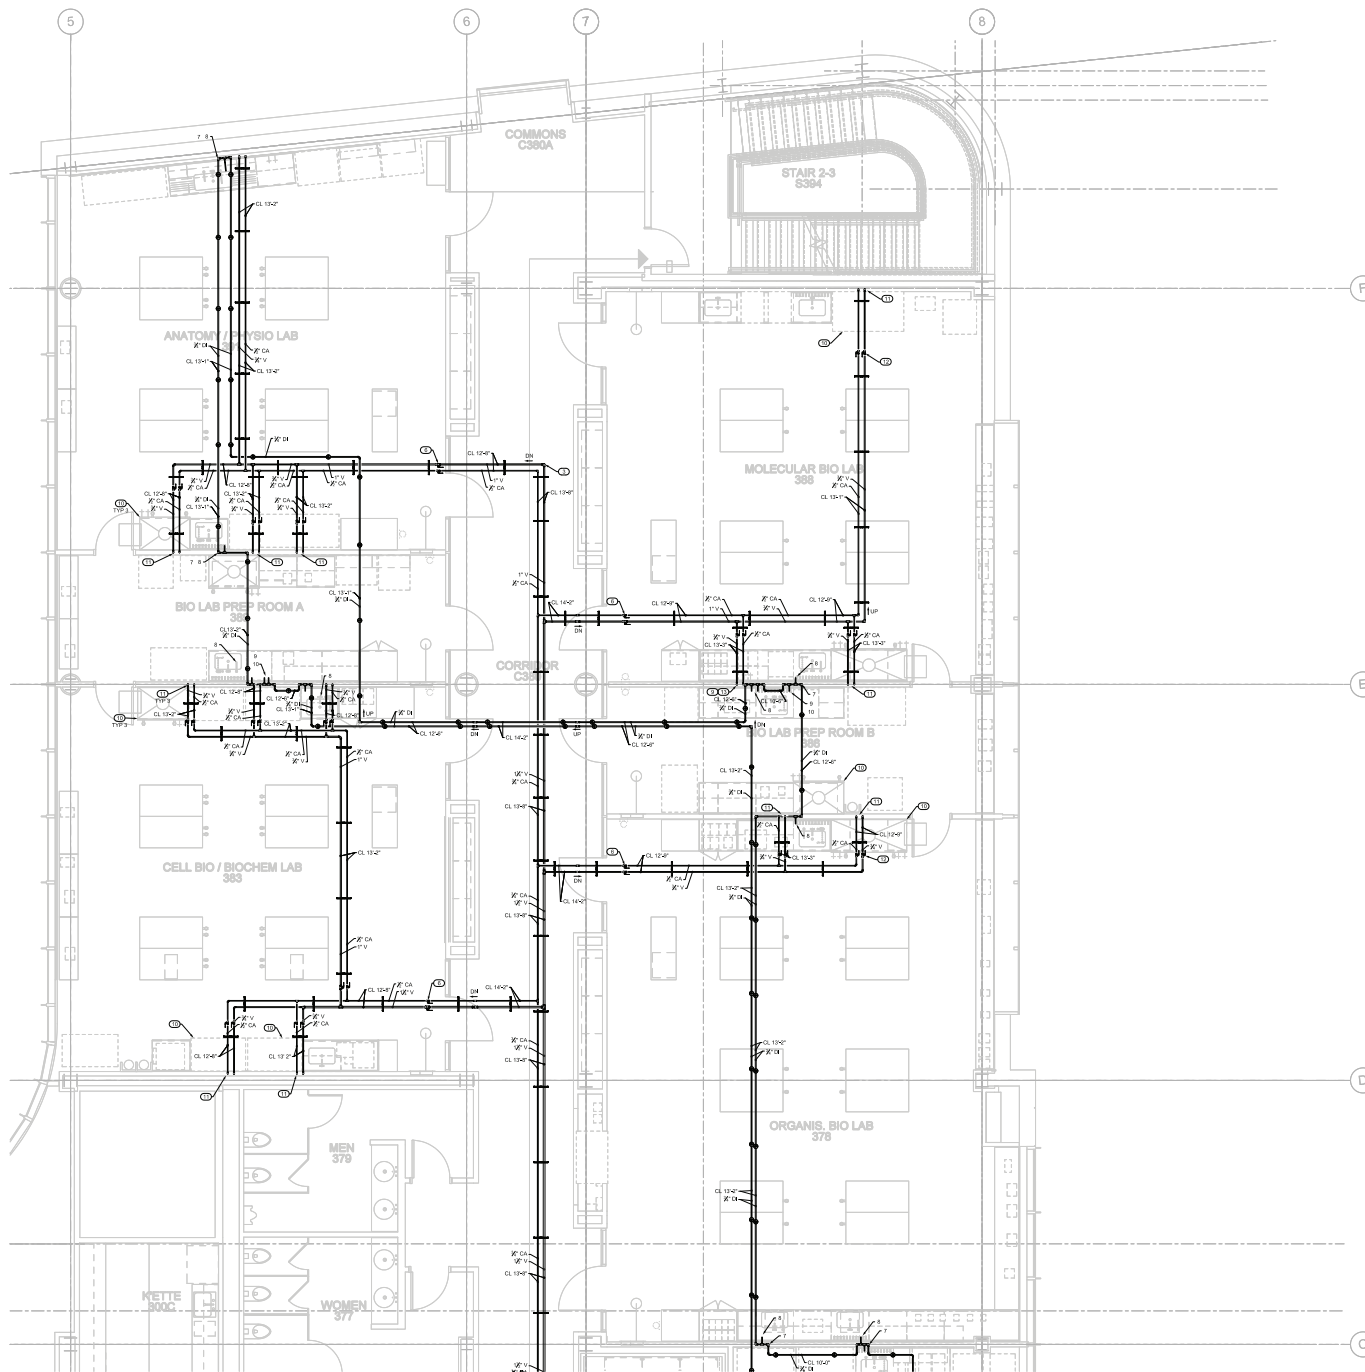


① PARTIAL LEVEL 3 - LAB GAS PIPING PLAN
 SCALE: 1/4"=1'-0"

- HANGER MAP KEYED NOTES:**

- H1** TRIANGLE HANGER W/ 3/8" ROD
H2 TRAPEZE HANGER W/ 3/8" ROD
H3 CLEVIS HANGER W/ 3/8" ROD
H4 V-BOTTOM CLEVIS HANGER W/ 3/8" ROD

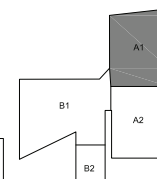

KEY PLAN

RECORD DRAWINGS
DATE: 6/30/17 DRAWN BY: ZS

Revision: 
 Issue Date 12 / 1 / 16
 Sheet Title
LP103A1
 Project Number
5768
 Sheet Number
1 of 1