



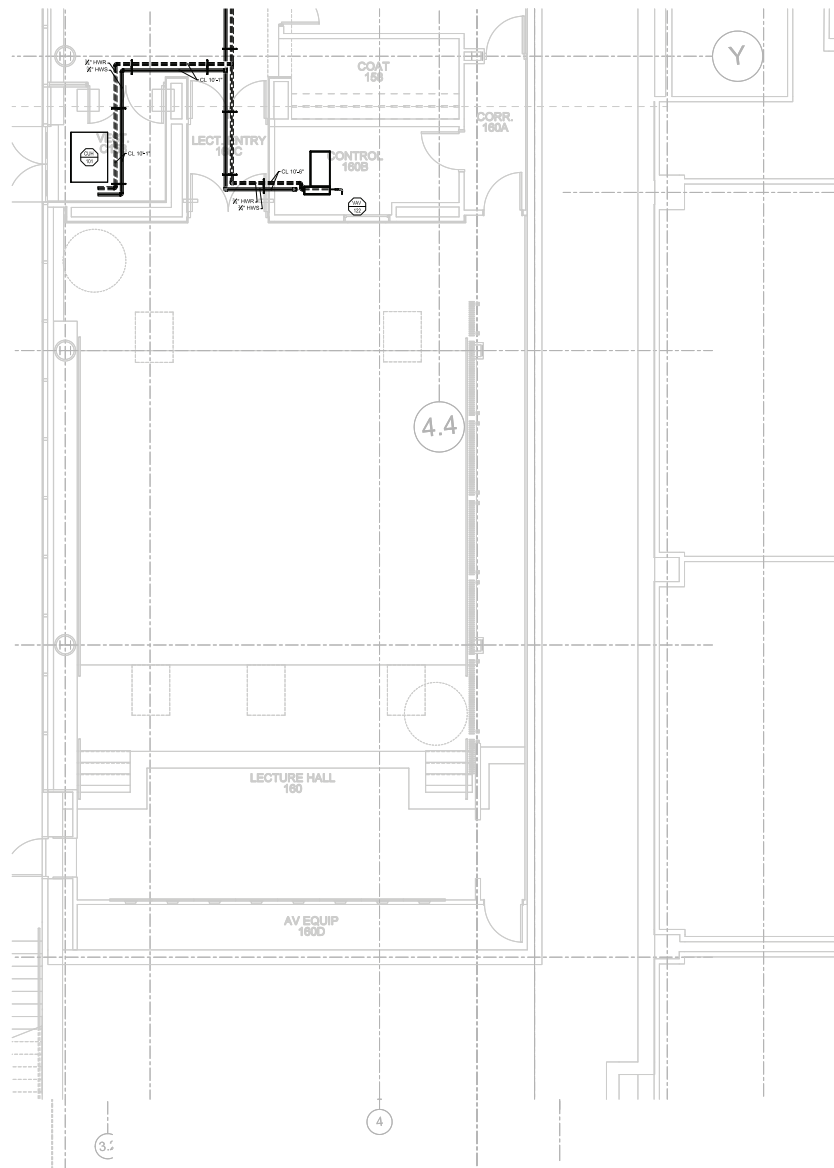

 **1 PARTIAL LEVEL 1 - PIPING PLAN**
SCALE: 1/4"=1'-0"

RECORD DRAWINGS
DATE: 6/30/17 DRAWN BY: ZPL

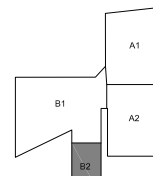

KEY PLAN

WEBSTER UNIVERSITY - ISB
WEBSTER GROVES, MISSOURI
ICON MECHANICAL CONTRACTORS AND ENGINEERS

NOT VALID FOR PERMITS
UNLESS SEALED BY
ENGINEER

Revision:						
Issue Date	XX / XX / XX					
Sheet Title	MP101B2					
Project Number	5768					
Sheet Number	1 of 1					