



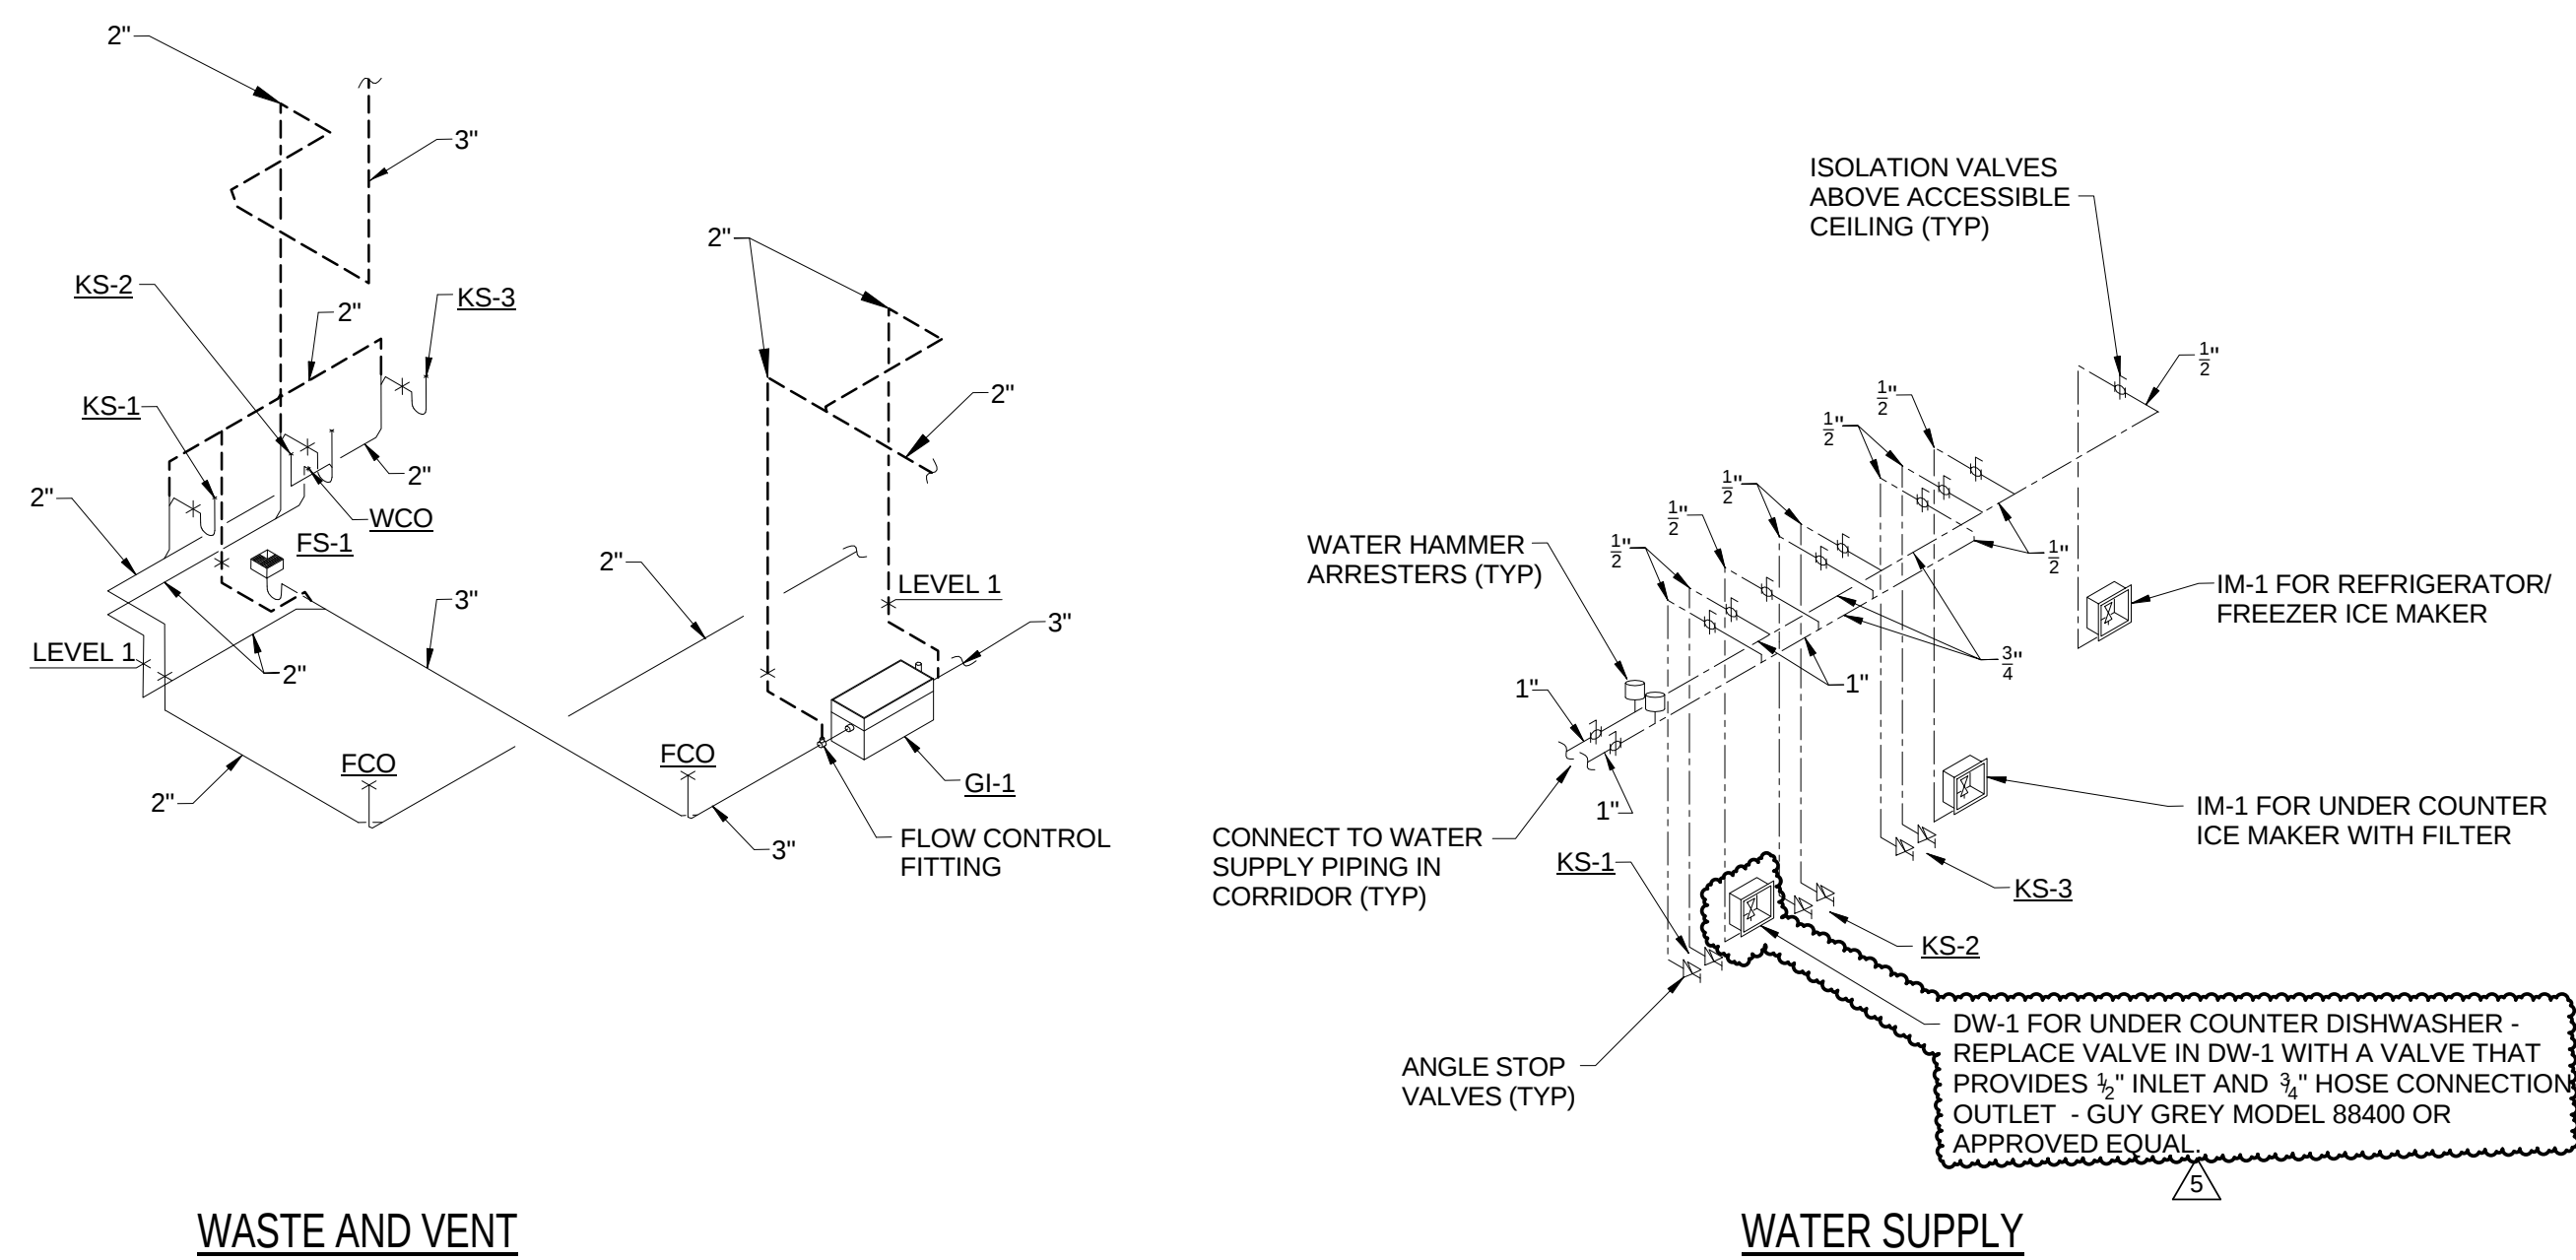

WASTE AND VENT

WATER SUPPLY


1 TEACHING KITCHEN 174 PLUMBING RISERS
P0402 SCALE: N.T.S.

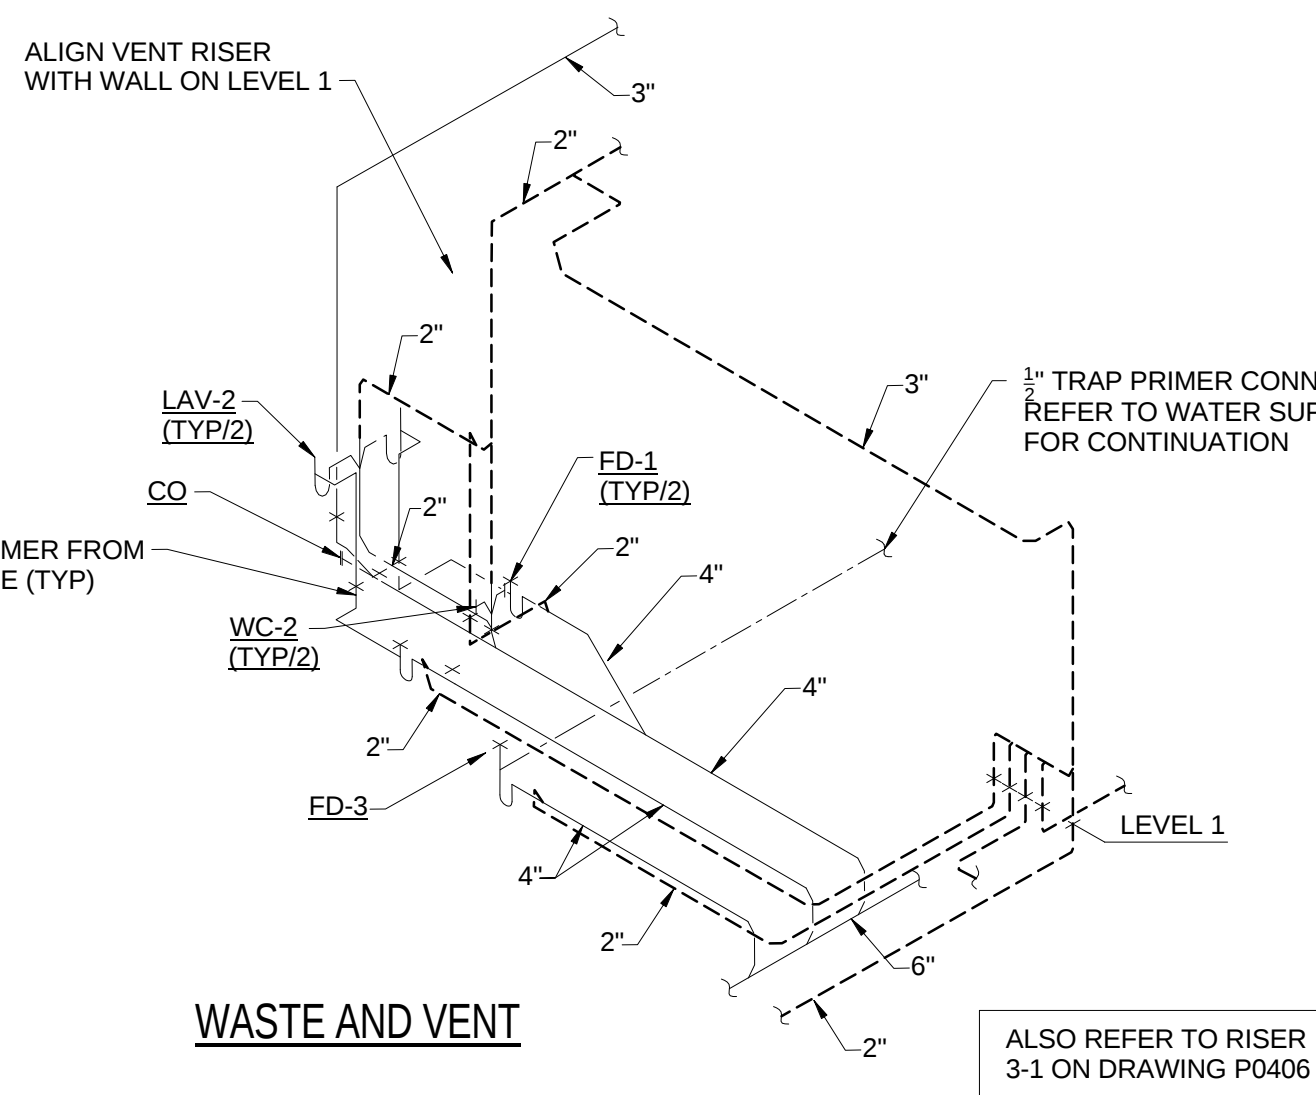


WASTE AND VENT

WATER SUPPLY

2 TOILET ROOMS 180 AND 182 PLUMBING RISERS
P0402 SCALE: N.T.S.

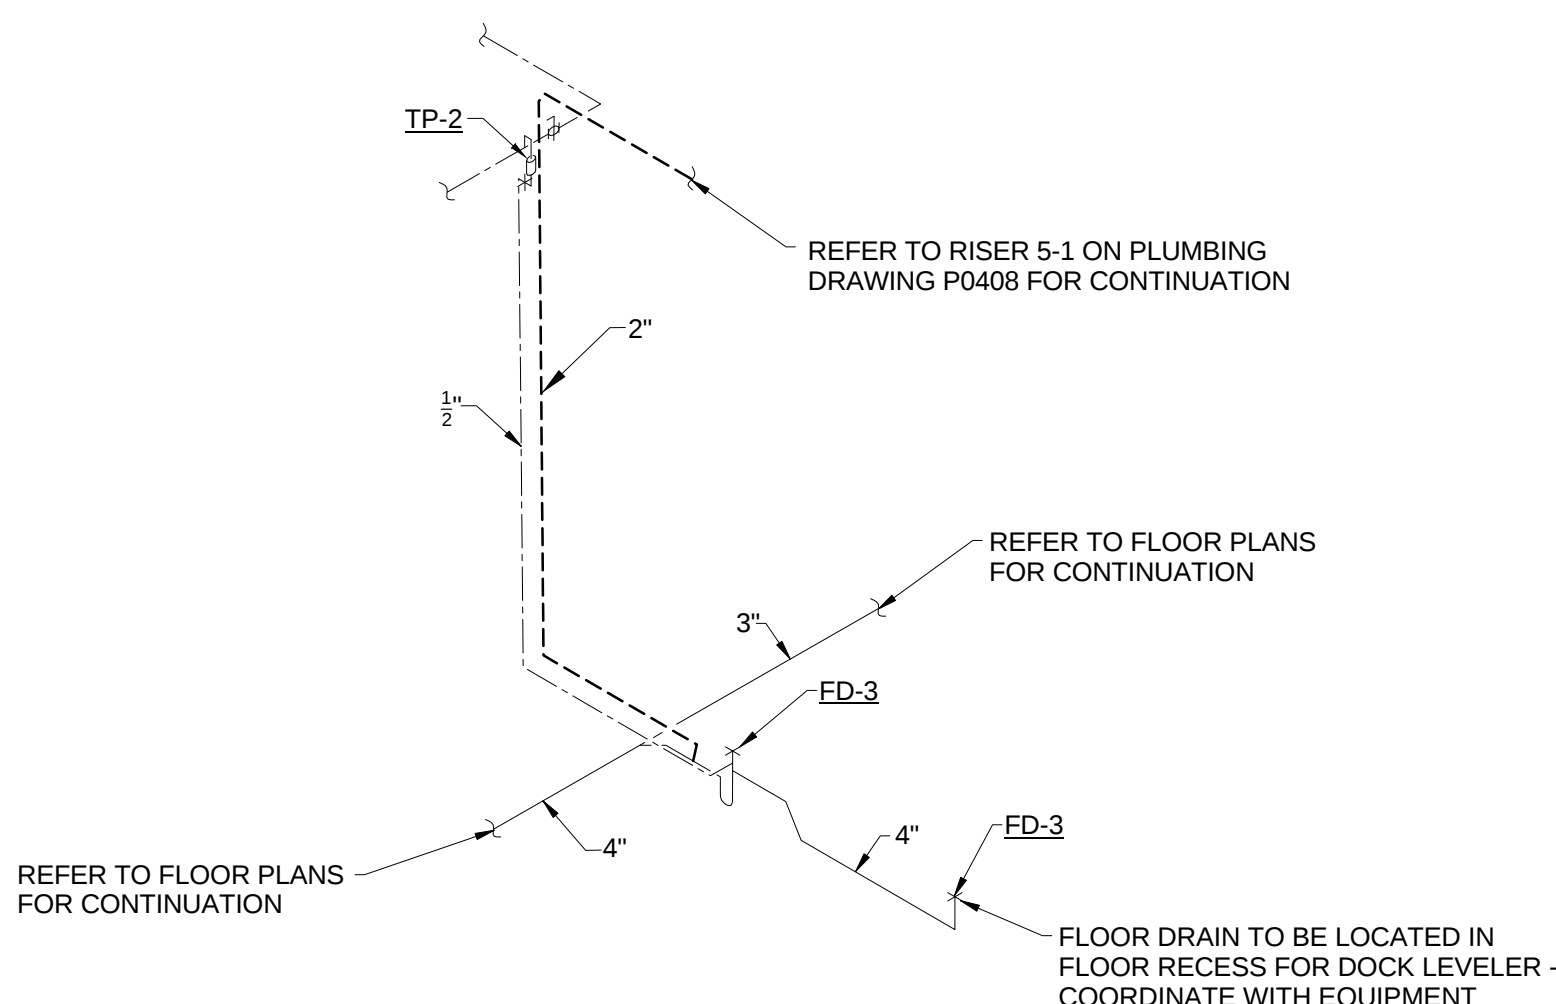


5 LOADING DOCK 172 FLOOR DRAINS
P0402 SCALE: N.T.S.

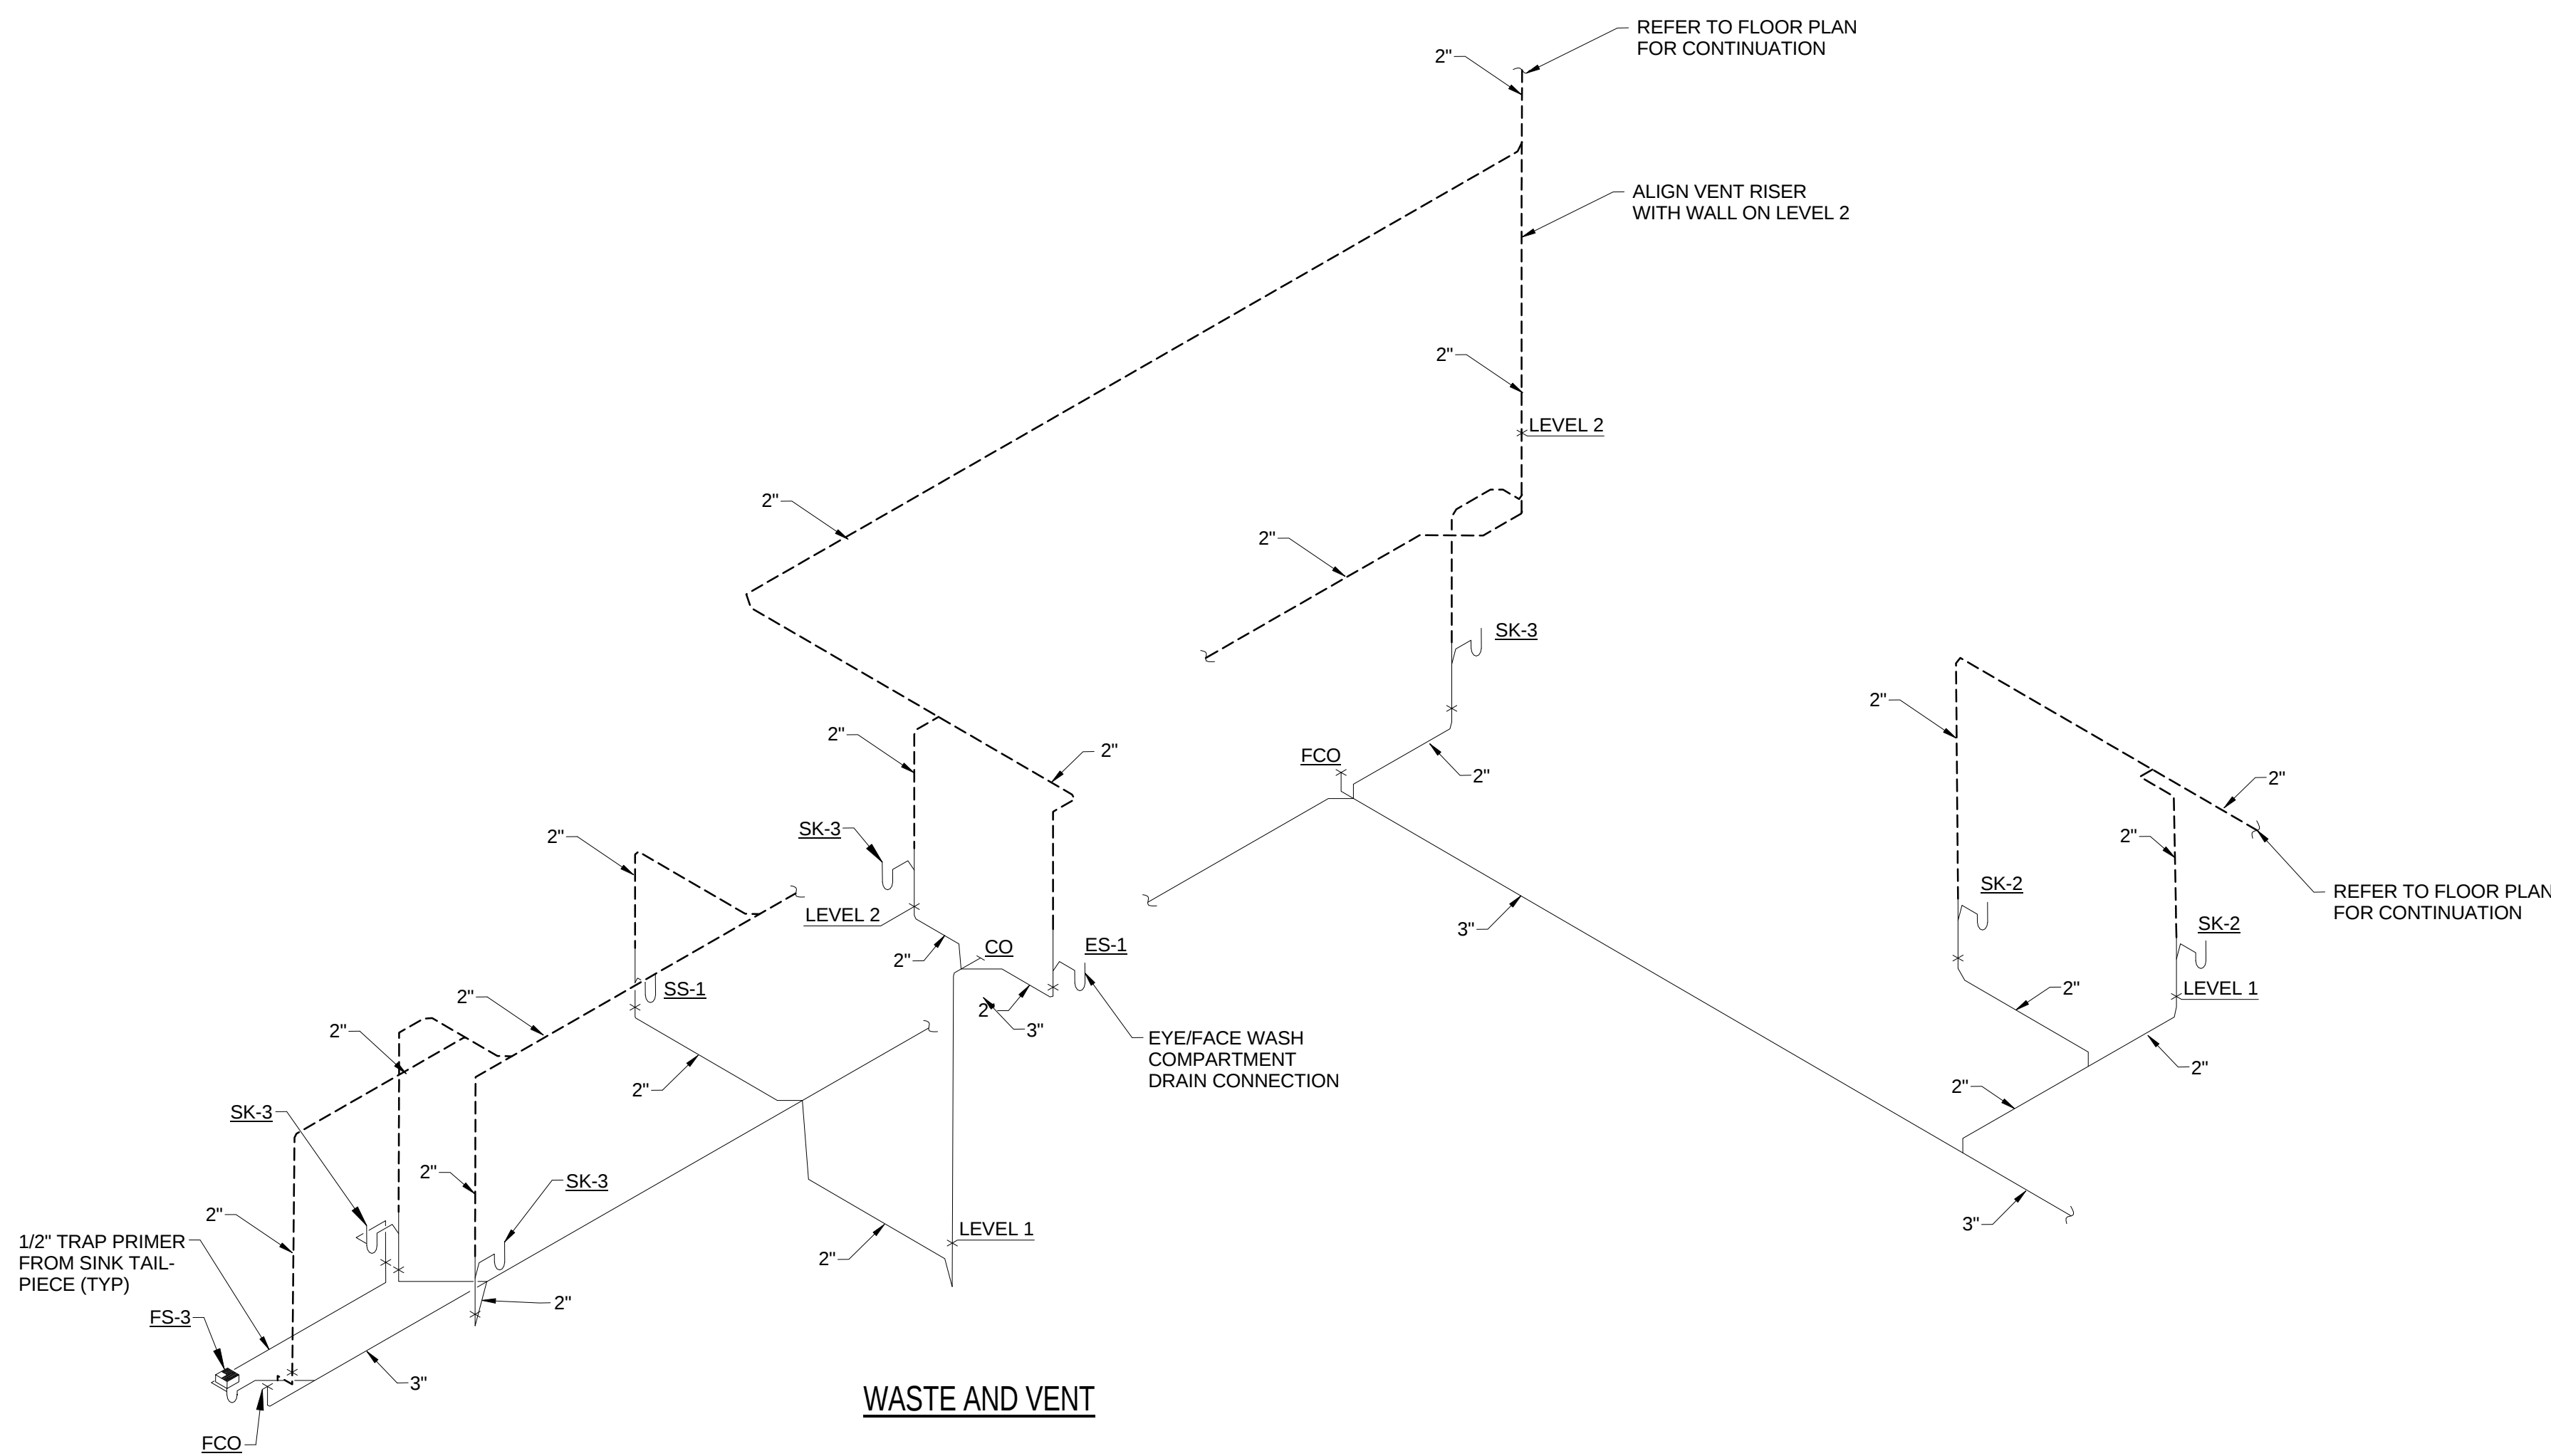

WASTE AND VENT

WATER SUPPLY

3 LEVEL 1 AND LEVEL 2 AREA B RISERS
P0402 SCALE: N.T.S.

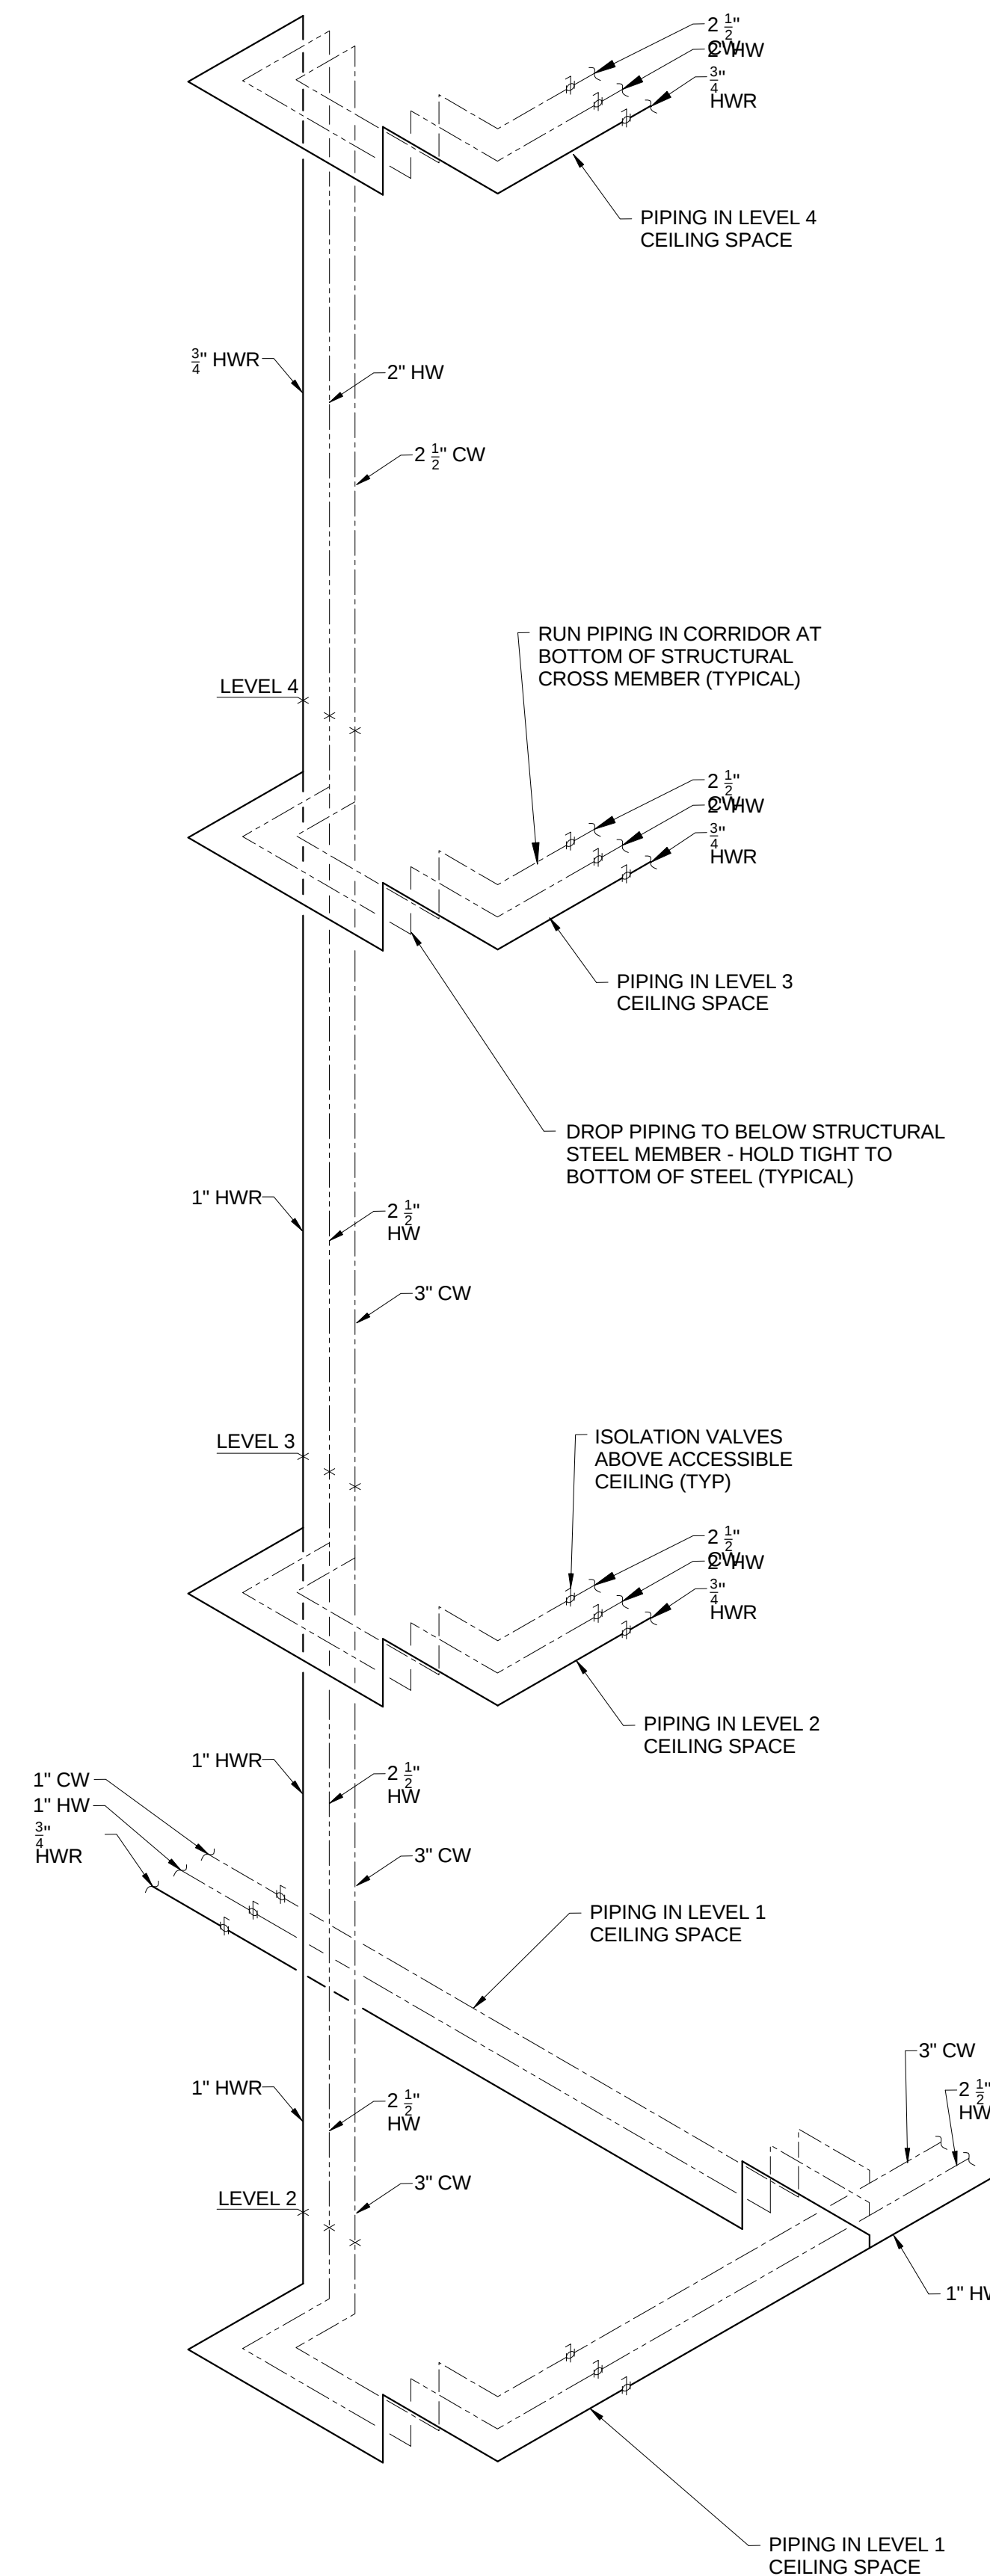

4 DOMESTIC WATER SERVICE BUILDING RISER
P0402 SCALE: N.T.S.

5	ASI - 061 (RFI - 502)	11 APR 2017
4	ASI - 033 (RFI 261,286,309 & 310)	03 NOV 2016
3	ADDENDUM 2-4	24 MAY 2015
2	ADDENDUM 2-2	19 APR 2016
1	ADDENDUM 2-1	17 MAR 2016
-	ISSUED FOR CONSTRUCTION (BP2)	01 MAR 2016
No.	Description	Date

Drawing Title:

RISERS - PLUMBING

Project No.: 04561.01 Checked by:

P0402

MSD P# 28874-01 MSD BASE MAP 23K3