




ICON MECHANICAL, INC. 1001 W. 14TH ST. SUITE 100, OMAHA, NE 68102-1001
TEL: 402.476.1000 FAX: 402.476.1001
WWW.ICONMECHANICAL.COM

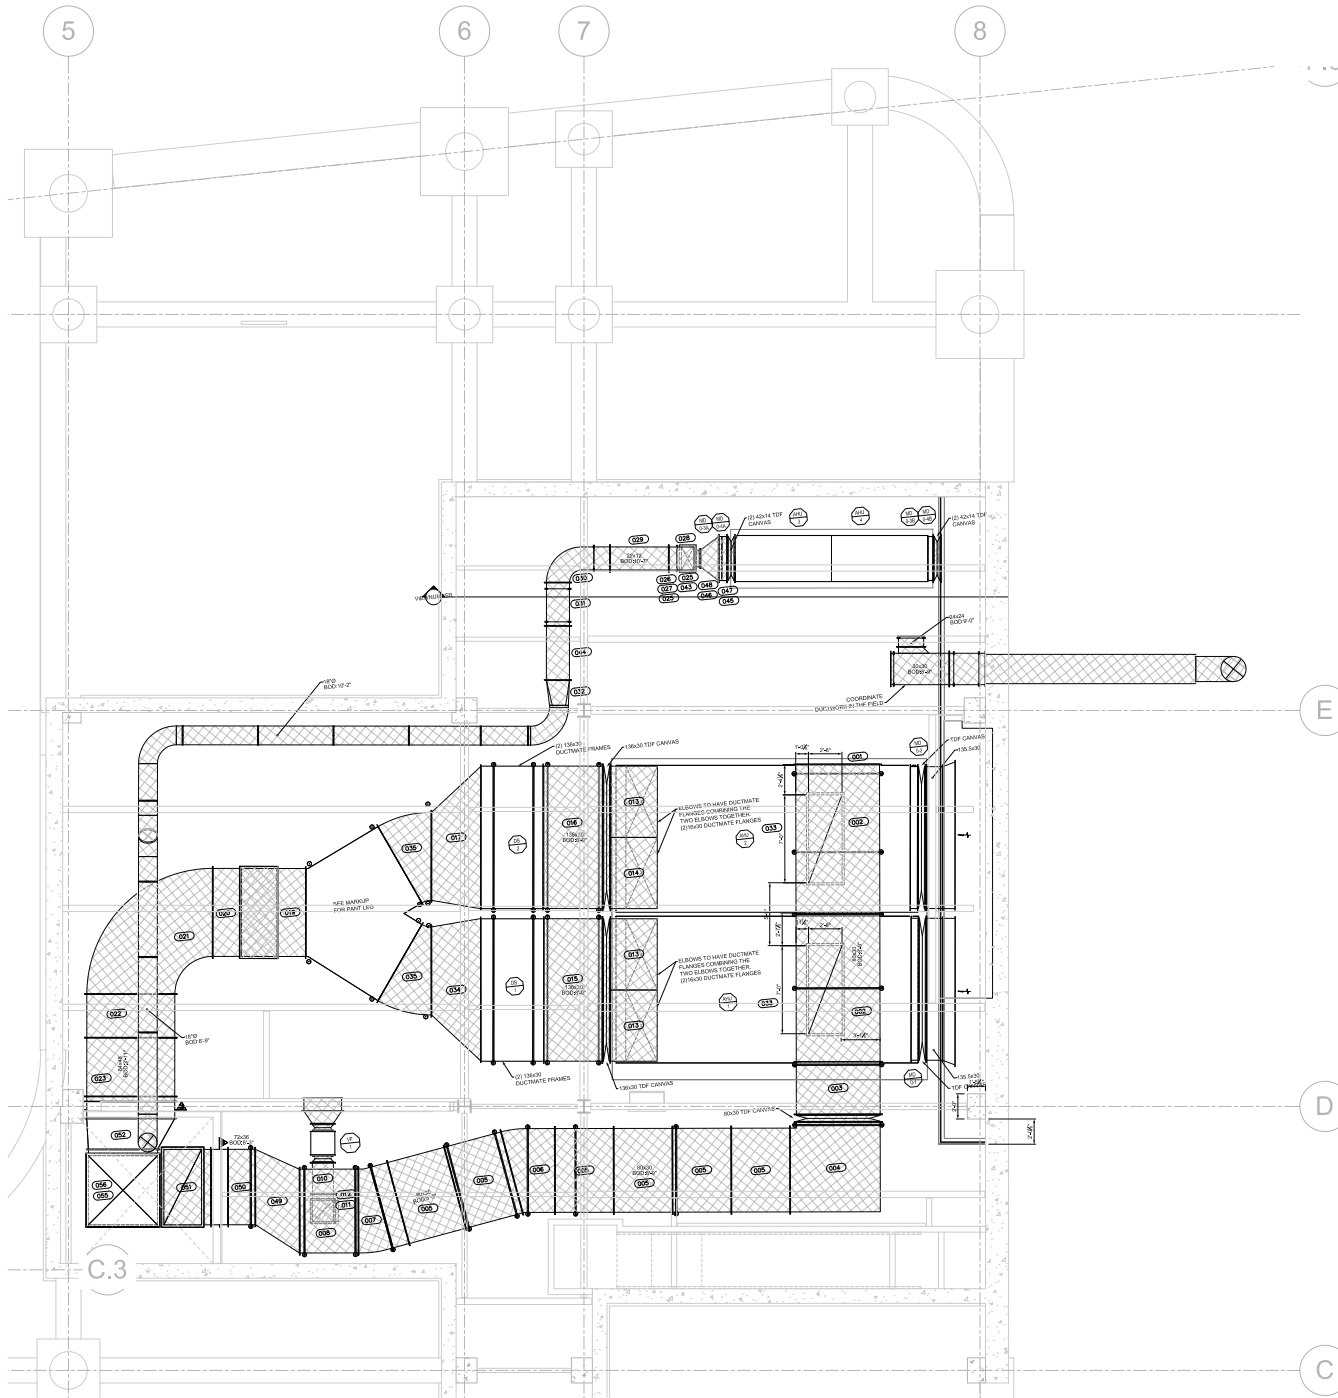

1 LEVEL 0 - DUCTWORK PLAN
SCALE: 1/4"=1'-0"

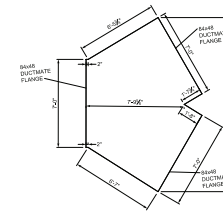

RECORD DRAWINGS
DATE: 6/30/17 DRAWN BY: JPL

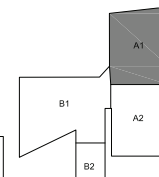

KEY PLAN



WEBSTER UNIVERSITY - ISB
WEBSTER GROVES, MISSOURI
ICON MECHANICAL CONTRACTORS AND ENGINEERS

NOT VALID FOR PERMITS
UNLESS SEALED BY
ENGINEER

Revision:	
Issue Date:	XX / XX / XX
Sheet Title:	SM100A
Project Number:	5768
Sheet Number:	1 of 1