


ICON MECHANICAL CONTRACTORS AND ENGINEERS
10000 W. 100th Street, Suite 100, Overland Park, KS 66213
TEL: 913.241.1000 FAX: 913.241.1001
WWW.ICONMECH.COM

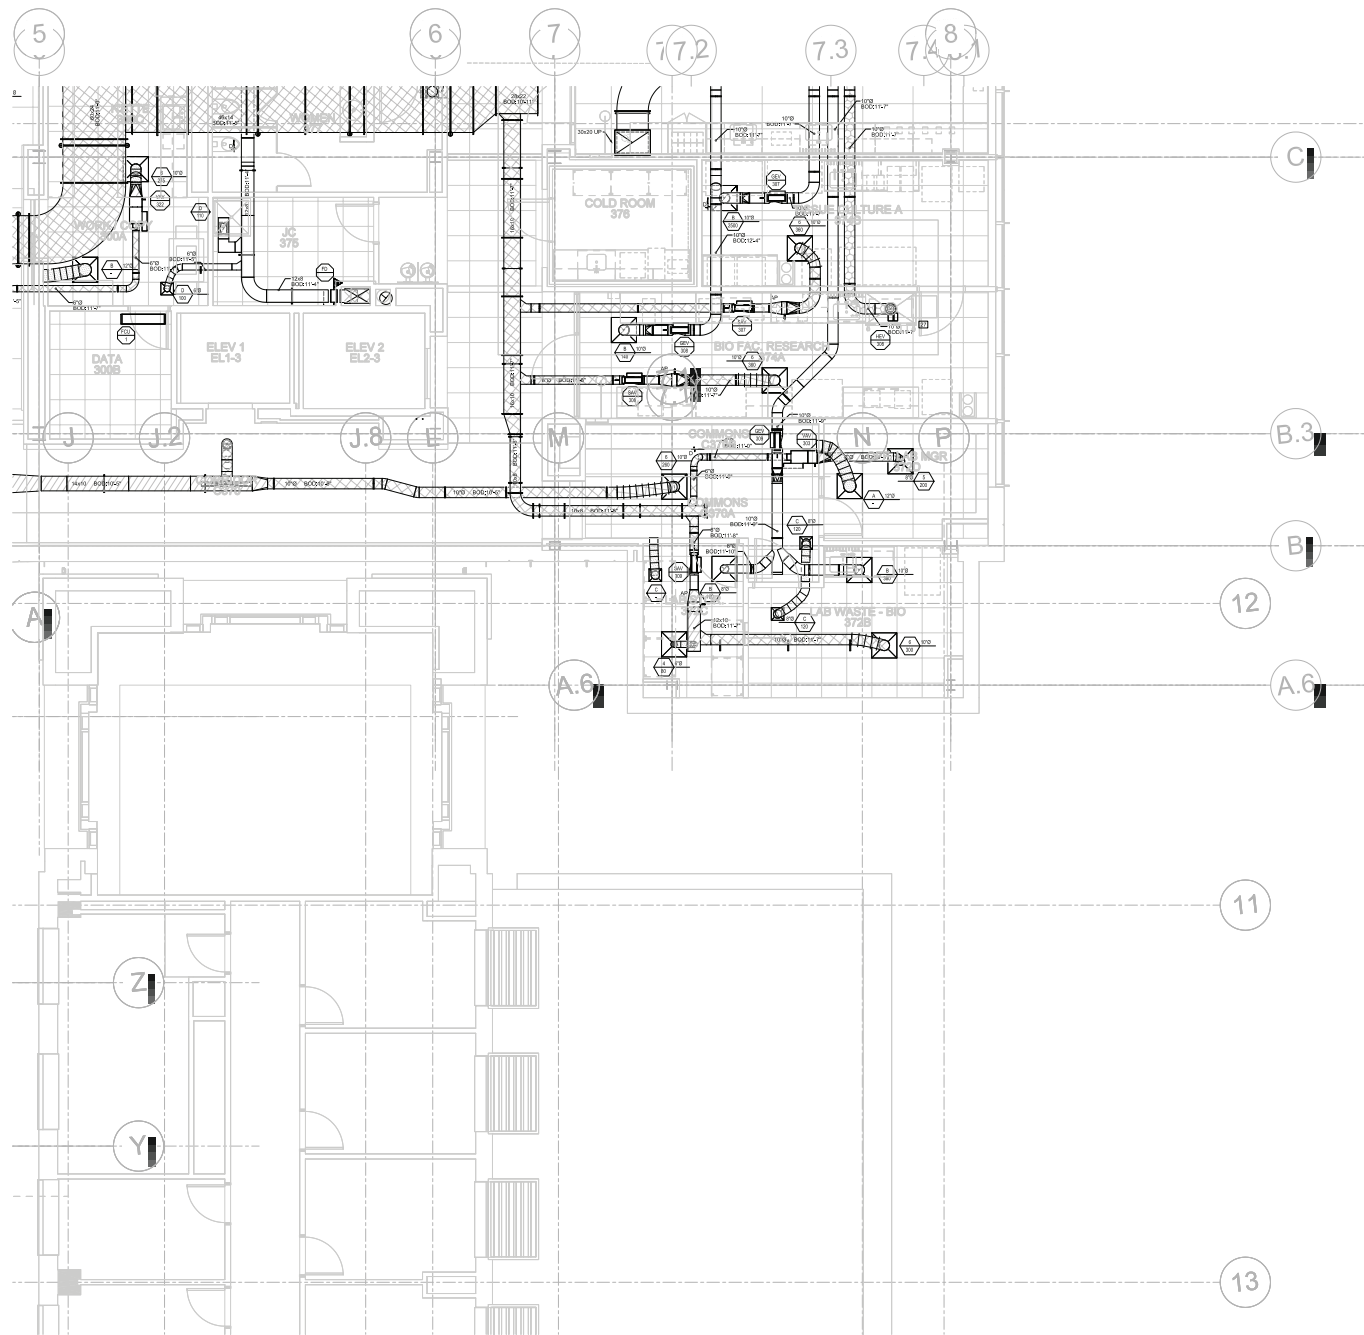


DUCT MATERIAL LEGEND	
	1/2" EXTERNAL WRAP
	1/2" INTERNAL LINER
	1" INTERNAL LINER
	STAINLESS STEEL
	BLACK IRON GREASE DUCT

KEYED NOTES (THIS SHEET ONLY)
[Symbol] INSTALL HOOD EXHAUST VALVE IN VERTICAL PORTION NEAR
[Symbol] HOOD ELBOWS SHALL HAVE 12" SHARPER RADIUS, 1/2" 1/2"
[Symbol] DIAMETER RADIUS ELBOWS ONLY WHERE NECESSARY

① PARTIAL LEVEL 3 - DUCTWORK PLAN
SCALE: 1/4"=1'-0"

RECORD DRAWINGS
DATE: 6/30/17 DRAW BY: JPL

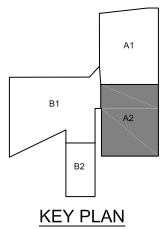

Icon Mechanical
MECHANICAL CONTRACTORS AND ENGINEERS
www.iconmech.com

WEBSTER UNIVERSITY - ISB
WEBSTER GROVES, MISSOURI
ICON MECHANICAL CONTRACTORS AND ENGINEERS

NOT VALID FOR PERMITS
UNLESS SEALED BY
ENGINEER

Revision:
Issue Date:
XX / XX / XX
Sheet Title:
SM103A2
Project Number:
5768
Sheet Number:
1 of 1