



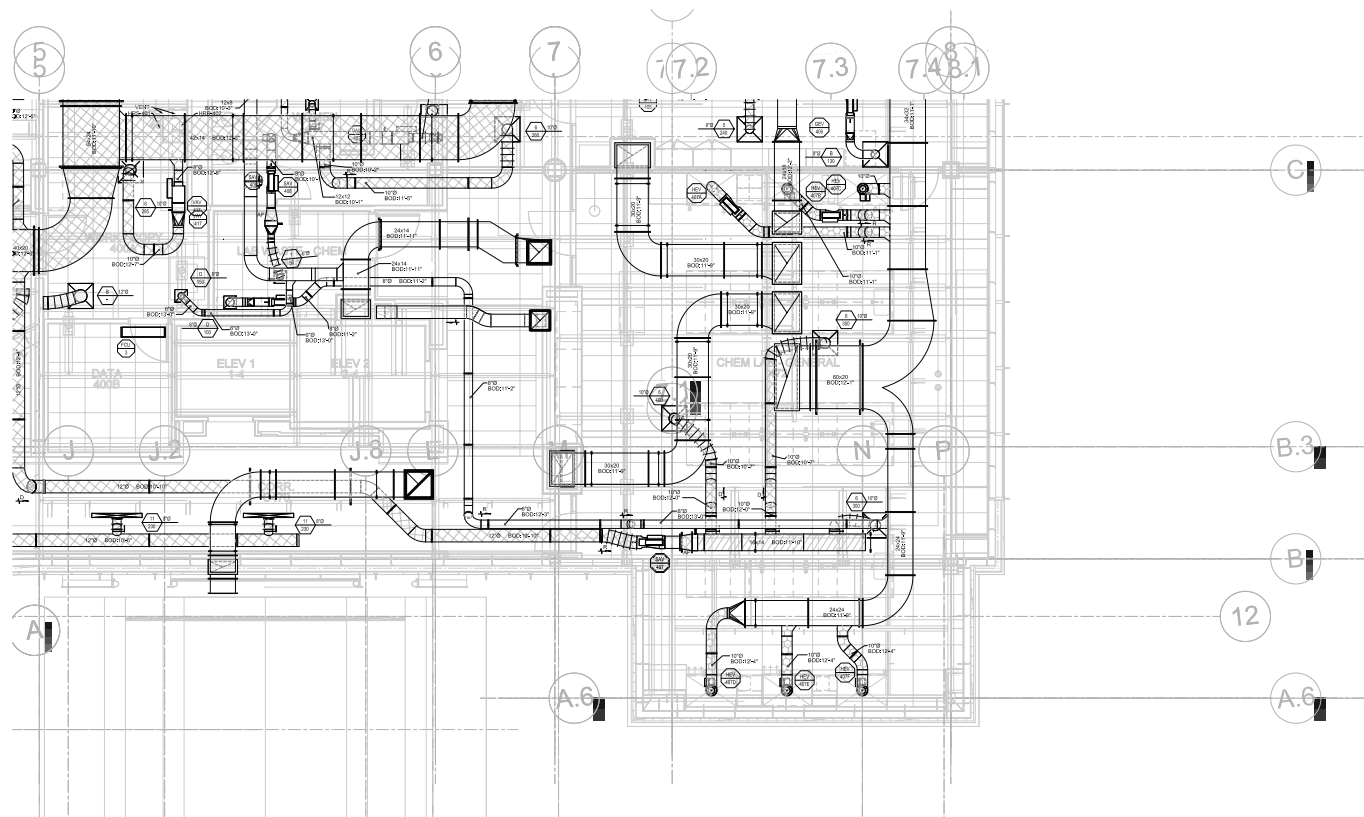

 **1** PARTIAL LEVEL 4 - DUCTWORK PLAN
SCALE: 1/4"=1'-0"

RECORD DRAWINGS
DATE: 6/30/17 DRAWN BY: ZPL

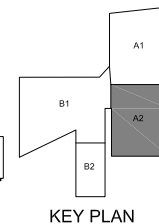

WEBSTER UNIVERSITY - ISB
WEBSTER GROVES, MISSOURI
ICON MECHANICAL CONTRACTORS AND ENGINEERS

NOT VALID FOR PERMITS
UNLESS SEALED BY
ENGINEER

Revision:     

Issue Date

01/03/17

Sheet Title

SM104A2

Project Number

5768

Sheet Number

1 of 1

SM104A2

Project Number

5768

Sheet Number

1 of 1

1 of 1