



ICON MECHANICAL - 1101 N. 11TH ST. SUITE 100, OMAHA, NE 68102-1101. TEL: 402.466.1101. FAX: 402.466.1102. WWW.ICONMECHANICAL.COM

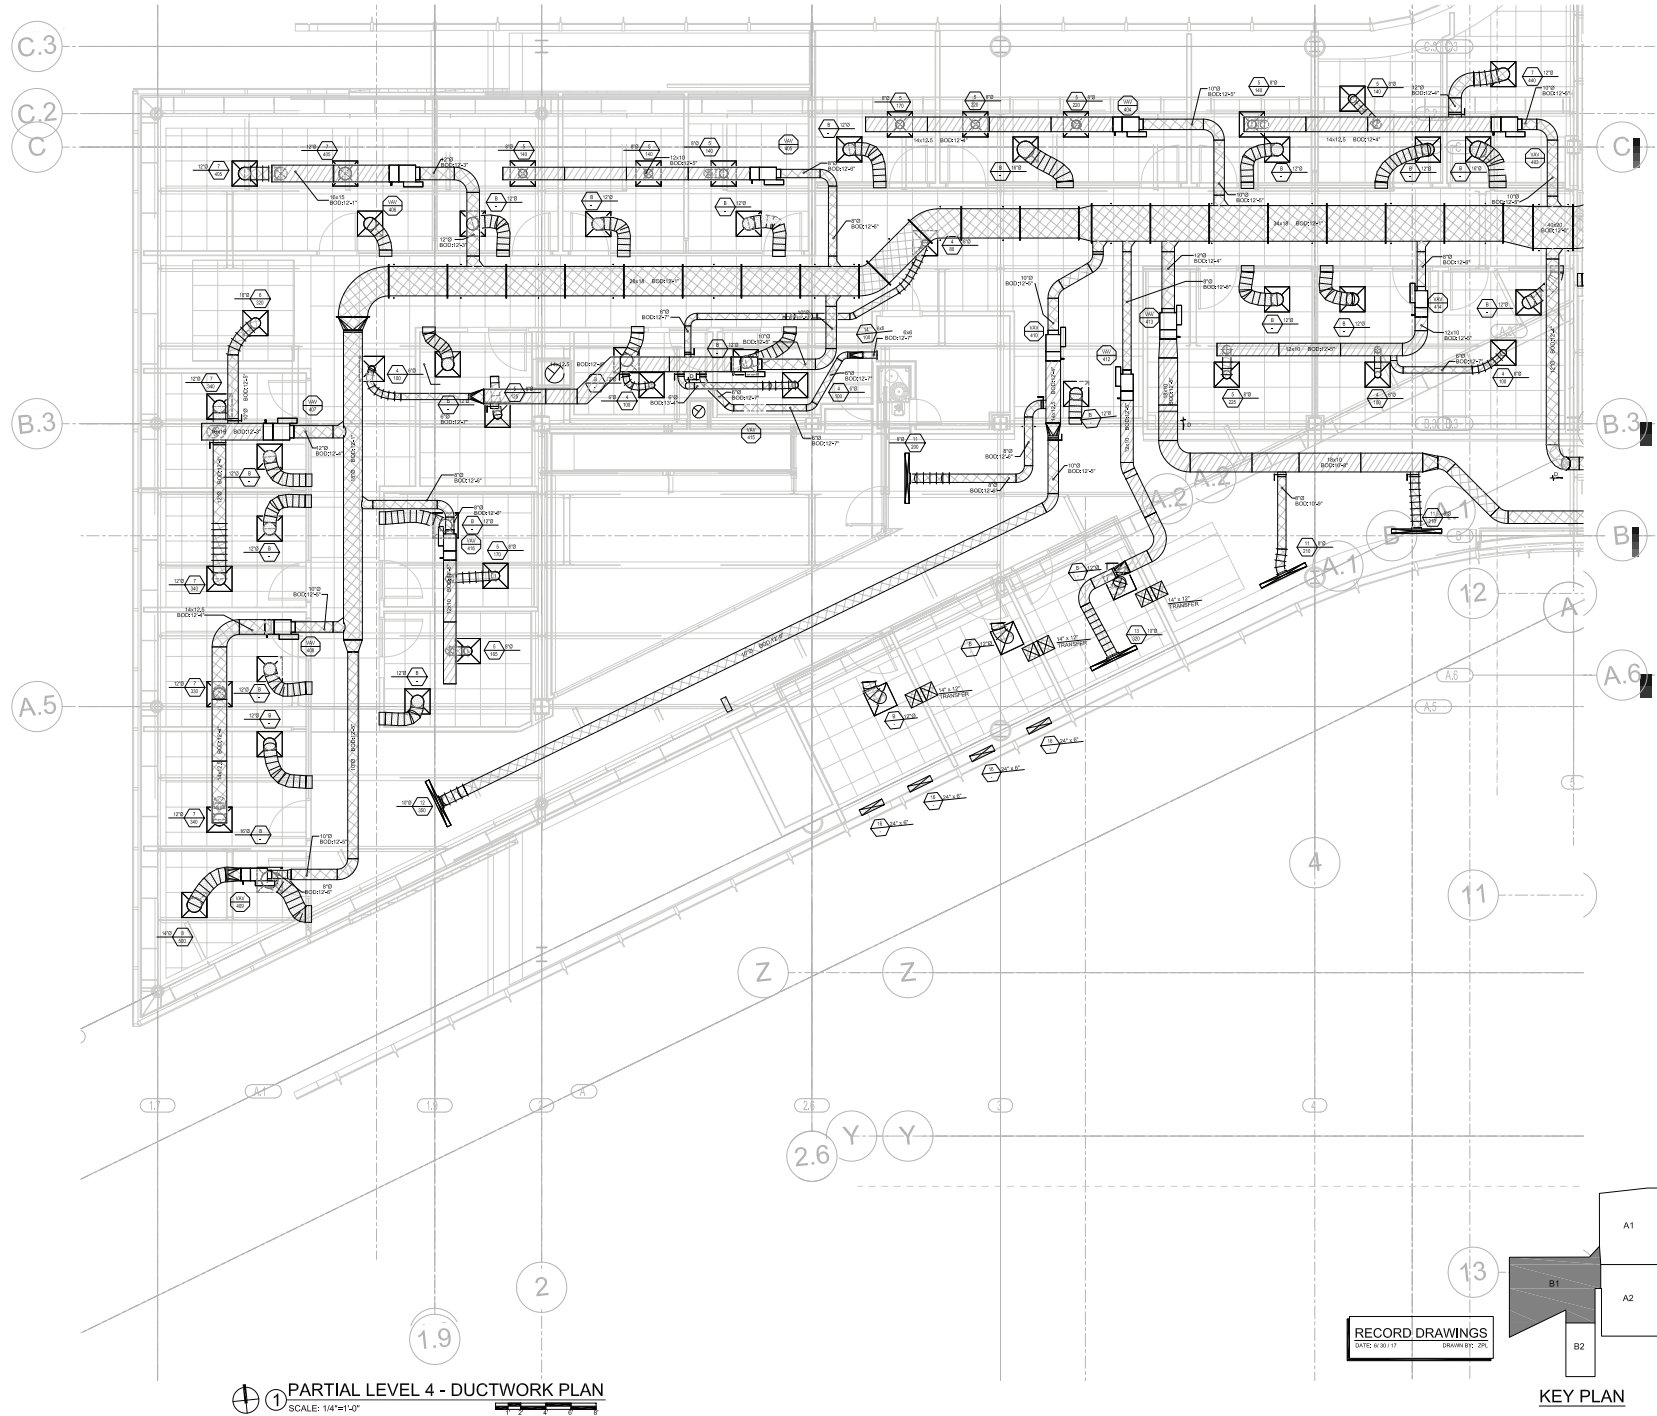

1 PARTIAL LEVEL 4 - DUCTWORK PLAN
SCALE: 1/4"=1'-0"

RECORD DRAWINGS
DATE: 6/30/17 DRAWN BY: JPC

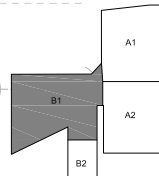

WEBSTER UNIVERSITY - ISB
WEBSTER GROVES, MISSOURI
ICON MECHANICAL CONTRACTORS AND ENGINEERS

NOT VALID FOR PERMITS
UNLESS SEALED BY
ENGINEER

Revision:	
Issue Date:	XX / XX / XX
Sheet Title:	
Project Number:	SM104B1
Sheet Number:	5768
1 of 1	