



ICON MECHANICAL, INC. 1000 W. 1000 S. SUITE 100, OMAHA, NE 68101-1000
TEL: 402.426.1000 FAX: 402.426.1001
WWW.ICONMECHANICAL.COM

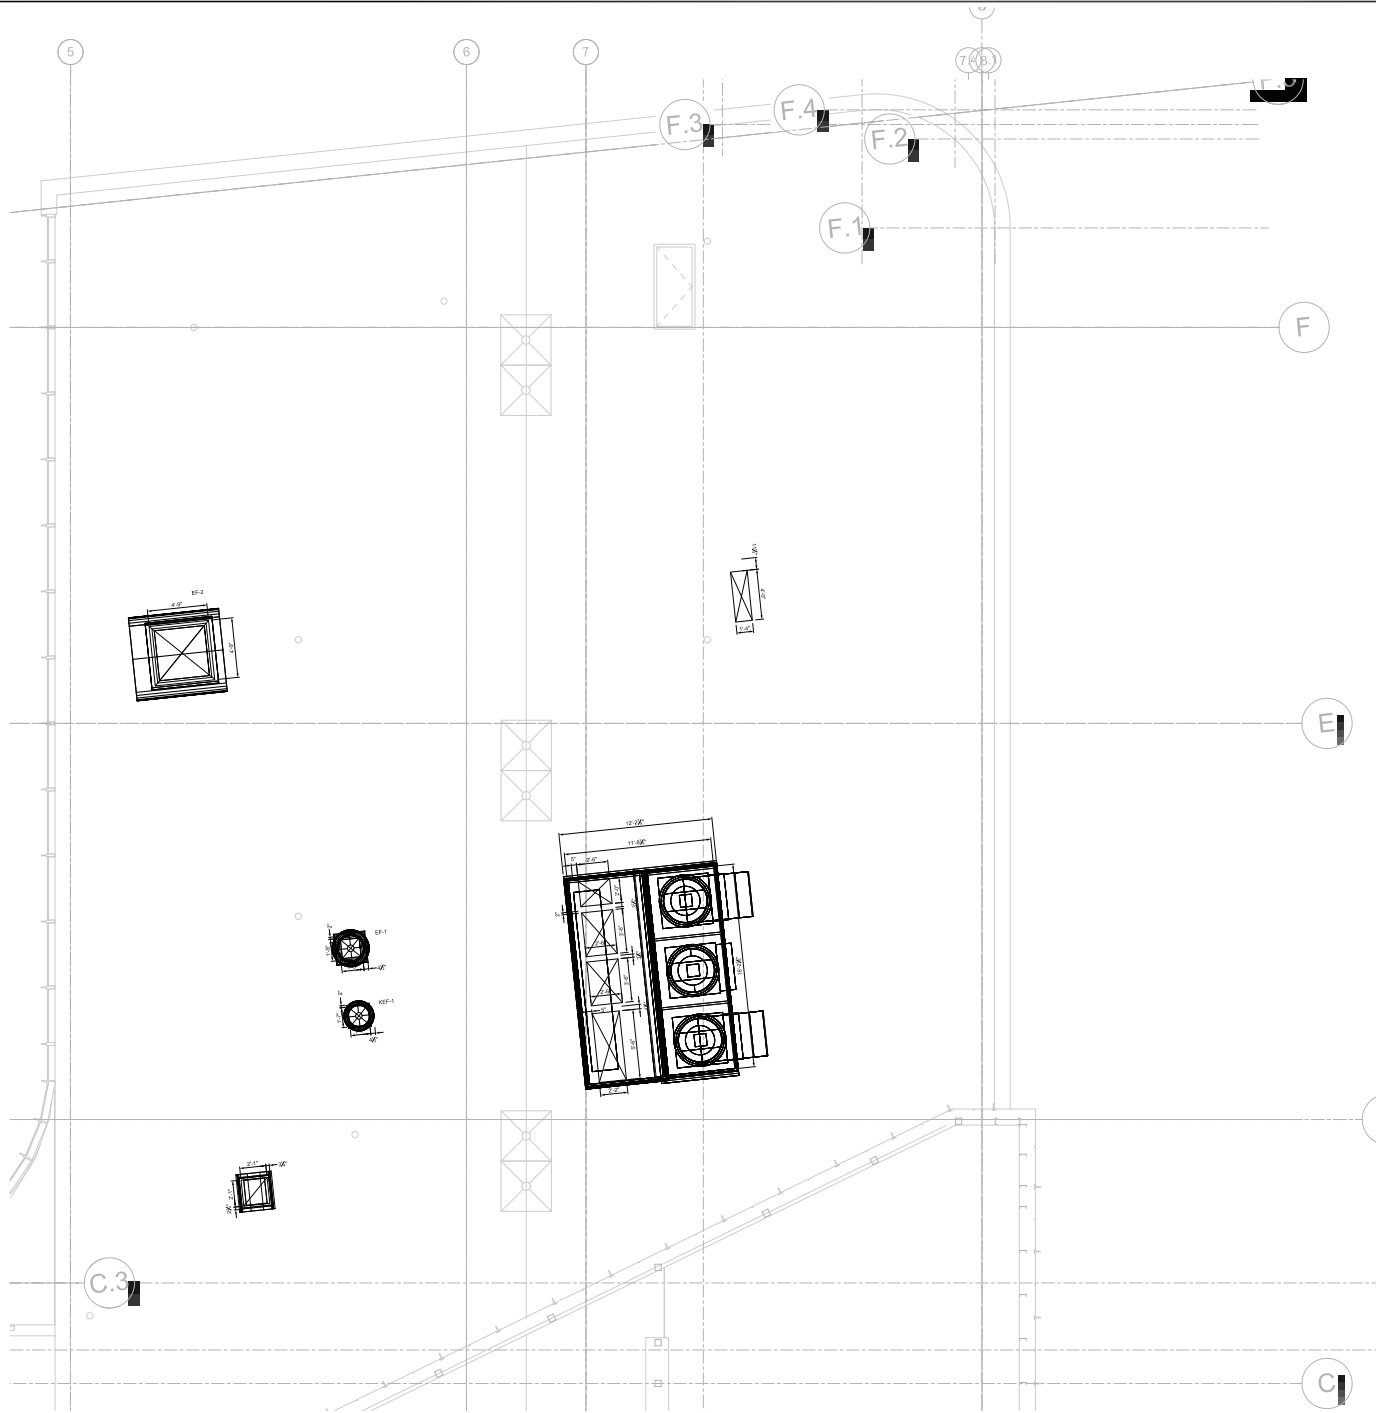

1 PARTIAL ROOF LEVEL - DUCTWORK PLAN
SCALE: 1/4"=1'-0"

RECORD DRAWINGS
DATE: 6/30/17 DRAWN BY: JPL

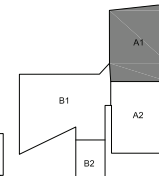

KEY PLAN



WEBSTER UNIVERSITY - ISB
WEBSTER GROVES, MISSOURI
ICON MECHANICAL CONTRACTORS AND ENGINEERS

NOT VALID FOR PERMITS
UNLESS SEALED BY
ENGINEER

Revision:

Issue Date: XX / XX / XX
Sheet Title:

Project Number: SM105A1
Sheet Number: 5768

1 of 1