


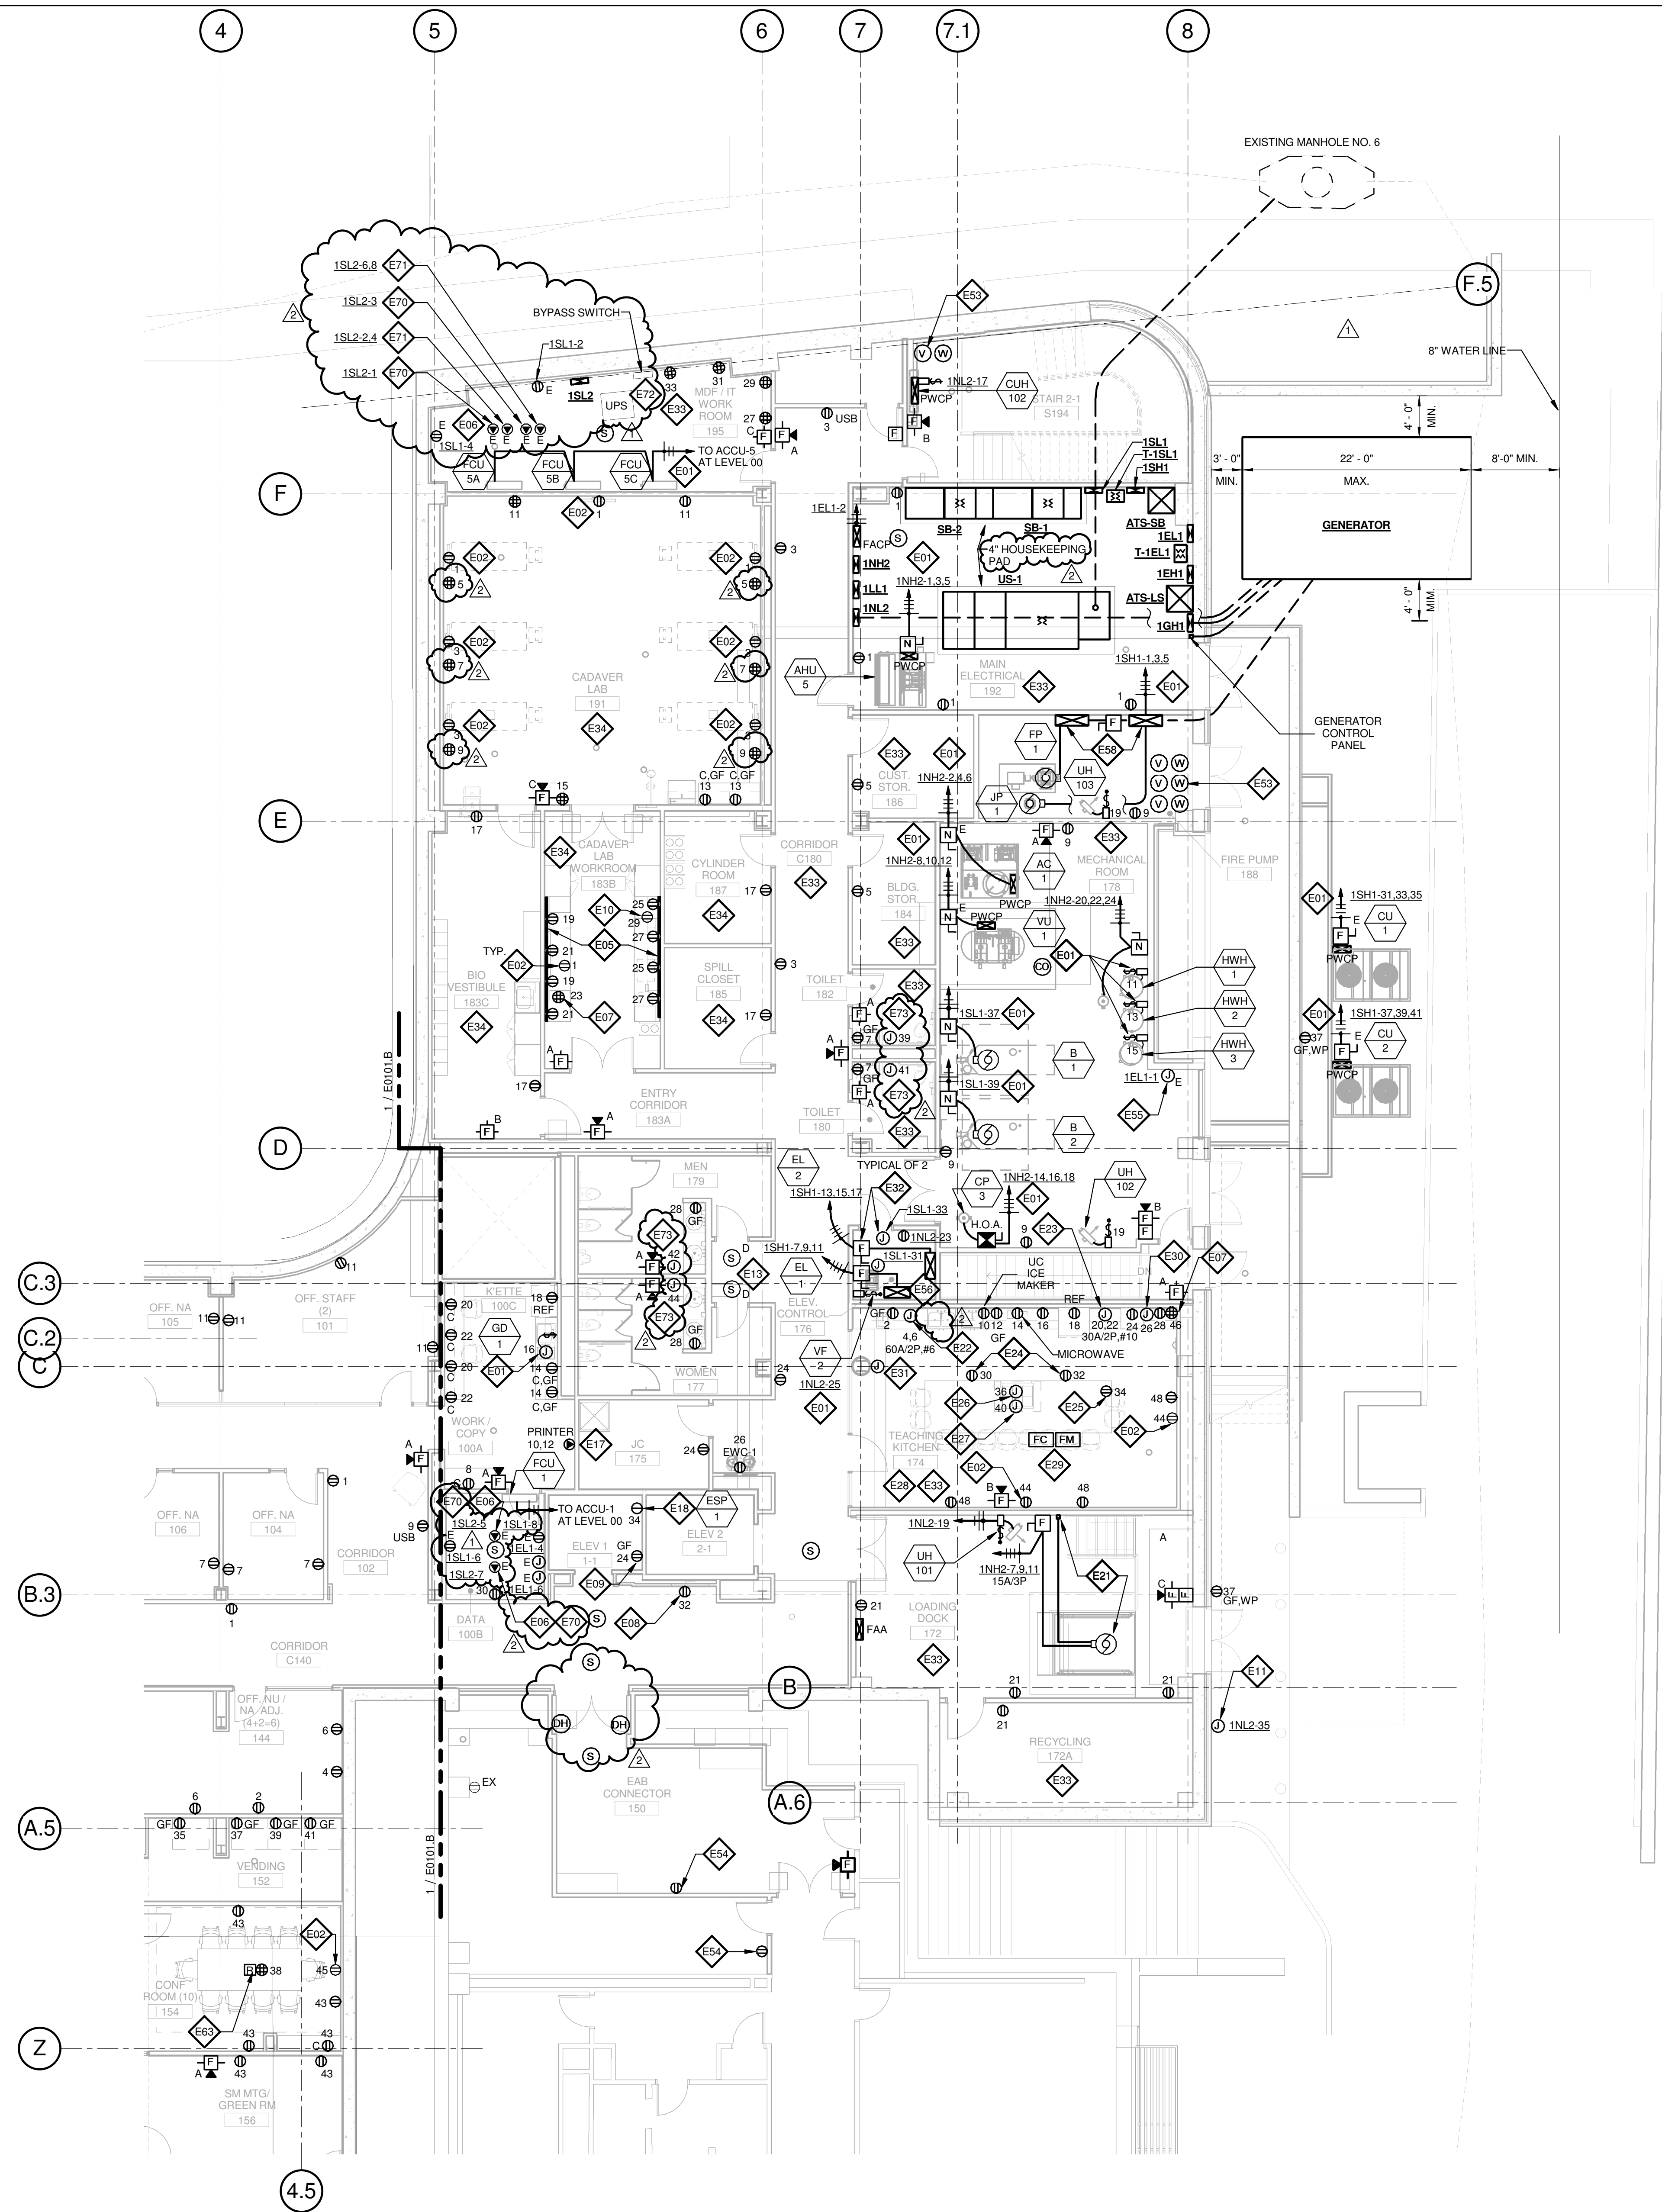

1 LEVEL 01 - AREA A - FLOOR PLAN - POWER AND AUXILIARY
1/8" = 1'-0"

GENERAL NOTES:

- DO NOT SCALE DRAWINGS. REFER TO ARCHITECTURAL PLANS AND ELEVATIONS FOR LOCATION AND ORIENTATION OF DEVICES. WHERE LOCATIONS ARE NOT INDICATED ON ARCHITECTURAL DRAWINGS, COORDINATE LOCATION AND ORIENTATION OF DEVICES IN FIELD WITH ARCHITECT PRIOR TO ROUGH-IN.
- ALL DEVICES SHOWN ARE NEW UNLESS NOTED OTHERWISE.
- ALL DEVICES TO REMAIN ARE INDICATED WITH A THIN SOLID LINE WEIGHT AND SUBSCRIPT "EX".
- CONTRACTOR SHALL VISIT PRIOR TO BID SUBMITTALS TO DETERMINE SITE CONDITIONS EFFECTING THE EXECUTION OF WORK. FAILURE TO BE ACQUAINTED WITH EXISTING CONDITIONS WILL NOT BE JUSTIFICATION FOR ADDITIONAL SERVICES.
- PROVIDE FACE PLATES ON ALL J-BOXES ABANDONED IN FINISHED FLOOR, WALL OR CEILING. COORDINATE COLOR AND FINISH WITH ARCHITECT. CONTRACTOR TO VERIFY QUANTITY IN THE FIELD.
- WHERE EXPOSED CONDUIT IS NOTED, CONTRACTOR SHALL IDENTIFY ROUTING IN FIELD AND OBTAIN ARCHITECT'S APPROVAL OF ROUTING PRIOR TO ROUGH-IN. EXPOSED CONDUIT SHALL BE ROUTED TIGHT TO STRUCTURE.
- ALL SINGLE PHASE BRANCH CIRCUITS SHOWN SHALL HAVE DEDICATED NEUTRALS TO MEET NEC SECTION 210.4 MULTI-WIRE BRANCH CIRCUIT REQUIREMENTS.
- REFER TO TECHNOLOGY DRAWINGS FOR CONDUIT ROUGH-IN OIDATA, VOICE AND A/V.
- ALL 120V BRANCH CIRCUITS ON THIS SHEET SHALL BE FED FROM PANEL 1N1.1 UNLESS NOTED OTHERWISE.

KEYED NOTES

- REFER TO EQUIPMENT DATA SCHEDULE FOR BRANCH CIRCUIT INFORMATION.
- PROVIDE NEW RECEPTACLE FOR MONITOR. COORDINATE MOUNTING HEIGHT WITH ARCHITECTURAL ELEVATIONS AND TECHNOLOGY PLANS.
- PROVIDE NEW TWO SECTION ALUMINUM RACEWAY, WIREMOLD AL4320 WITH RECEPTACLES MOUNTED 24" ON CENTER UNLESS NOTED OR SHOWN OTHERWISE. PROVIDE ALL ACCESSORIES FOR A COMPLETE INSTALLATION. REFER TO ARCHITECTURAL ELEVATIONS FOR MOUNTING HEIGHT AND LENGTH. SEE DETAILS ON SHEET E402.
- OUTLET SHALL BE MOUNTED TO THE BACK SIDE OF THE TELECOMMUNICATION RACK AND FED FROM ABOVE. COORDINATE EXACT MOUNTING HEIGHT AND LOCATION WITH TELECOMMUNICATIONS CONTRACTOR PRIOR TO INSTALLATION.
- OUTLET FOR RACK MOUNTED A/V EQUIPMENT. COORDINATE MOUNTING HEIGHT AND EXACT LOCATION WITH ARCHITECTURAL ELEVATIONS AND A/V DRAWINGS.
- OUTLET FOR DIGITAL SIGNAGE. COORDINATE MOUNTING HEIGHT AND EXACT LOCATION WITH ARCHITECTURAL ELEVATIONS AND A/V DRAWINGS.
- MOUNT RECEPTACLE IN ELEVATOR PIT. COORDINATE EXACT LOCATION WITH ELEVATOR CONTRACTOR.
- UNDERCOUNT REFRIGERATOR. COORDINATE EXACT LOCATION AND MOUNTING HEIGHT WITH ARCHITECTURAL PLANS AND ELEVATIONS.
- PROVIDE POWER AND FINAL CONNECTION TO WALL MOUNTED BLUE LIGHT EMERGENCY INTERCOM STATION.
- PROVIDE A DUCT MOUNTED SMOKE DETECTOR(S) AT RETURN AIR GRILLE OF AHU-1 & AHU-2. BOTH AIR HANDLING UNITS SHALL SHUT DOWN UPON ACTIVATION OF THE DUCT MOUNTED SMOKE DETECTOR(S). PROVIDE REMOTE INDICATOR LIGHT(S) IN CEILING BELOW.
- PROVIDE NEMA 6-30R, 30A-208V RECEPTACLE FOR PRINTER. CONTRACTOR SHALL VERIFY PRINTER PLUG TYPE WITH OWNERS REPRESENTATIVE PRIOR TO ROUGH-IN.
- PROVIDE POWER AND FINAL CONNECTION TO ELEVATOR SUMP PUMP. COORDINATE EXACT LOCATION WITH PLUMBING CONTRACTOR PRIOR TO ROUGH-IN.
- PROVIDE POWER AND FINAL CONNECTION TO DOCK LEVELER AND CONTROLS PER MANUFACTURERS WRITTEN INSTRUCTIONS. COORDINATE CONTROL AND DISCONNECT LOCATION WITH DOCK LEVELER INSTALLER PRIOR TO INSTALLATION.
- PROVIDE POWER AND FINAL CONNECTION TO DISH WASHER. REFER TO KITCHEN EQUIPMENT DRAWINGS FOR ADDITIONAL INFORMATION.
- PROVIDE POWER AND FINAL CONNECTION TO DOUBLE OVEN. REFER TO KITCHEN EQUIPMENT DRAWINGS FOR ADDITIONAL INFORMATION.
- RECEPTACLE MOUNTED IN COUNTER APRON. REFER TO ARCHITECTURAL DRAWINGS AND ELEVATIONS FOR EXACT LOCATION.
- RECEPTACLE MOUNTED INSIDE CABINET FOR COMPUTER. REFER TO ARCHITECTURAL DRAWINGS AND ELEVATIONS FOR EXACT LOCATION.
- PROVIDE POWER AND FINAL CONNECTION TO DROP IN COOK TOP. REFER TO KITCHEN EQUIPMENT DRAWINGS FOR ADDITIONAL INFORMATION.
- PROVIDE POWER AND FINAL CONNECTION TO ISLAND HOOD. REFER TO KITCHEN EQUIPMENT DRAWINGS FOR ADDITIONAL INFORMATION.
- REFER TO KITCHEN EQUIPMENT DRAWINGS FOR MOUNTING HEIGHTS OF ALL ELECTRICAL DEVICES IN THIS ROOM AND FOR POWER REQUIREMENTS PRIOR TO ROUGH-IN.
- PROVIDE FIRE ALARM MONITOR MODULE AND CONTROL MODULE CONNECTED TO FIRE ALARM SYSTEM AT HOOD. PROVIDE WIRING BETWEEN HOOD AND FIRE SUPPRESSION SYSTEM. REFER TO KITCHEN HOOD EXTINGUISHING SYSTEM WIRING DIAGRAM, ON SHEET E0402.
- PROVIDE POWER FOR HOOD FIRE PROTECTION SYSTEM. INTERCONNECT EXHAUST FANS AND MAKE-UP AIR FANS TO MICRO SWITCH IN FIRE PROTECTION CABINET. REFER TO KITCHEN HOOD EXTINGUISHING SYSTEM WIRING DIAGRAM.
- PROVIDE J-BOX AND CONDUIT IN WALL FOR REMOTE MANUAL PULL STATION. REFER TO KITCHEN EQUIPMENT DRAWINGS FOR ADDITIONAL INFORMATION.
- PROVIDE POWER MODULE SWITCH FOR ELEVATOR AND A JUNCTION BOX WITH A 120V/20A CIRCUIT FOR CONNECTION OF ELEVATOR CONTROLS. PROVIDE ALL FINAL CONNECTIONS TO ELEVATOR CONTROLLER AND ELEVATOR CAB PER MANUFACTURERS WRITTEN INSTRUCTIONS. REFER TO ONE-LINE DIAGRAM FOR ADDITIONAL INFORMATION.
- ALL 120V BRANCH CIRCUITS IN THIS ROOM SHALL BE FED FROM PANEL 1N1.2.
- ALL 120V BRANCH CIRCUITS IN THIS ROOM SHALL BE FED FROM PANEL 1L1.1.
- COORDINATE QUANTITY AND LOCATION OF TAMPER AND FLOW SWITCHES WITH FIRE PROTECTION CONTRACTOR.
- EXTEND CIRCUIT FROM EXISTING RECEPTACLES SERVING THIS AREA.
- PROVIDE POWER TO BUILDING AUTOMATION SYSTEM PANEL. COORDINATE LOCATION WITH AUTOMATION CONTRACTOR.
- SEE ELEVATOR DETAIL ON SHEET E0402 FOR ADDITIONAL POWER & FIRE ALARM REQUIREMENTS.
- FIRE PUMP CONTROLLER AND JOCKEY PUMP CONTROLLER SEE ONE LINE DIAGRAM FOR FEEDER INFORMATION.
- PROVIDE A 2HR FIRE CLASSIFIED 4-GANG MULTI-SERVICE STEEL RECESSED FLOOR BOX EQUAL TO WIREMOLD CAT. NO. RFB45-FC WITH A BRASS FLANGED COVER CAT. NO. RFBTCBS-NA. THE FLOOR BOX SHALL HAVE ALL NECESSARY MOUNTING BRACKETS FOR (2) 20A DUPLEX RECEPTACLE, (1) GANG - DATA/VOICE (SEE TECHNOLOGY DRAWINGS FOR DEVICE TYPE), (1) GANG - A/V (SEE A/V DRAWINGS FOR DEVICE TYPES). THE BOX SHALL BE INSTALLED PER MANUFACTURERS WRITTEN INSTRUCTIONS SO THAT THE COVER IS FLUSH WITH THE FLOOR.
- PROVIDE NEMA L5-20R, 20A-120V TWIST LOCK RECEPTACLE FOR RACK MOUNTED PDU. COORDINATE EXACT LOCATION AND MOUNTING HEIGHT WITH TECHNOLOGY CONTRACTOR.
- PROVIDE NEMA L5-20R, 30A-208V TWIST LOCK RECEPTACLE FOR RACK MOUNTED PDU. COORDINATE EXACT LOCATION AND MOUNTING HEIGHT WITH TECHNOLOGY CONTRACTOR.
- UPS AND EXTERNAL BYPASS SWITCH FURNISHED BY OWNER AND INSTALLED BY CONTRACTOR. REFER TO TECHNOLOGY DRAWINGS AND ONE-LINE DIAGRAM FOR ADDITIONAL INFORMATION.
- PROVIDE POWER AND FINAL CONNECTIONS FOR ELECTRIC HAND DRYER.

THE SEAL(S) AND SIGNATURE(S) APPLY ONLY TO THE DOCUMENT TO WHICH THEY ARE AFFIXED, AND EXPRESSLY DISCLAIM ANY RESPONSIBILITY FOR ALL OTHER PLANS, SPECIFICATIONS, ESTIMATES, REPORTS OR OTHER DOCUMENTS OR INSTRUMENTS RELATING TO OR INTENDED TO BE USED FOR ANY PART OR PARTS OF THE ARCHITECTURAL OR ENGINEERING PROJECT.



Webster University
Interdisciplinary Science
Building

CANNONDESIGN

1100 Clark Avenue
St. Louis, Missouri 63102
T: 314.241.6250
F: 314.241.2570

William Tao & Associates, Inc.
MERFP Engineer
7955 Manchester Road, Suite 125
St. Louis, MO 63143
314-884-7600

David Mason & Associates, Inc.
Structural & Civil Engineer
800 South Vandeventer Avenue
St. Louis, MO 63110
314.534.1053

Faith Group
Technology
3101 S. Hanley Rd., Suite 100
St. Louis, MO 63143
314.591.2229

Kuhmann Leavitt, Inc.
Environmental Graphics & Signage
7400 Pershing Ave.
St. Louis, MO 63130
314.725.6616

KWA Architects
Architecture
3721 Litzinger Road
St. Louis, MO 63124
314.962.2560


Spellman Brady & Company
Interior Designer
8251 Maryland Avenue, Suite 300
St. Louis, MO 63105
314.862.0070

SWT Design
Landscape Architect
7722 Big Bend Blvd
St. Louis, MO 63119
314.644.5700

Webb Engineering Services, Inc.
Planning & Fire Protection
1400 S. 3rd Street, Suite 201
St. Louis, MO 63104
314.588.0690

CONFORMED SET 01 JUL 2016

2	ADDENDUM 2-2	19 APRIL 2016
1	ADDENDUM 2-1	17 MAR 2016
-	ISSUED FOR CONSTRUCTION (BP2)	01 MAR 2016
No.	Description	Date

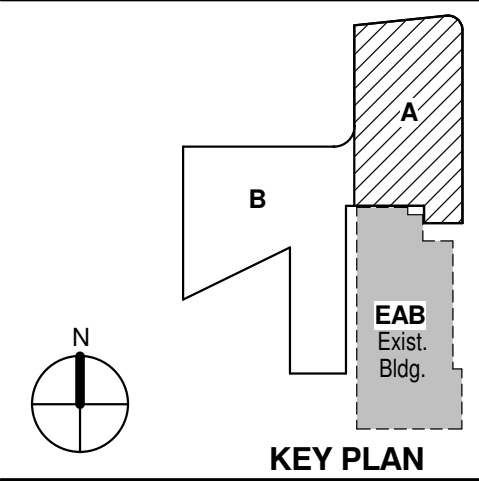

KEY PLAN

LEVEL 01 AREA A FLOOR PLAN - ELECTRICAL & AUXILIARY

Project No.: 04561.01 Checked by:

E0101.A