

THE SEAL(S) AND SIGNATURE(S) APPLY ONLY TO THE DOCUMENT TO WHICH THEY ARE AFFIXED, AND EXPRESSLY DISCLAIM ANY RESPONSIBILITY FOR ALL OTHER PLANS, SPECIFICATIONS, ESTIMATES, REPORTS OR OTHER DOCUMENTS OR INSTRUMENTS RELATING TO OR INTENDED TO BE USED FOR ANY PART OR PARTS OF THE ARCHITECTURAL OR ENGINEERING PROJECT.



Webster University
Interdisciplinary Science
Building

CANNONDESIGN

1100 Clark Avenue
St. Louis, Missouri 63102
T: 314.241.6250
F: 314.241.2570

William Tao & Associates, Inc.
MERFP Engineer
7955 Manchester Road, Suite 125
St. Louis, MO 63143
314-884-7600

David Mason & Associates, Inc.
Structural & Civil Engineer
800 South Vandeventer Avenue
St. Louis, MO 63110
314.534.1053

Faith Group
Technology
3101 S. Hanley Rd., Suite 100
St. Louis, MO 63143
314.591.2229

Kuhmann Leavitt, Inc.
Environmental Graphics & Signage
7400 Pershing Ave.
St. Louis, MO 63130
314.725.6616

KWA Architects
Architecture
3721 Litzinger Road
St. Louis, MO 63124
314.962.2560

Spellman Brady & Company
Interior Designer
8251 Maryland Avenue, Suite 300
St. Louis, MO 63105
314.862.0070

SWT Design
Landscape Architect
7722 Big Bend Blvd.
St. Louis, MO 63119
314.644.5700


Webb Engineering Services, Inc.
Planning & Fire Protection
1400 S. 3rd Street, Suite 201
St. Louis, MO 63104
314.588.0600

GENERAL NOTES:

- A. DO NOT SCALE DRAWINGS. REFER TO ARCHITECTURAL PLANS AND ELEVATIONS FOR LOCATION AND ORIENTATION OF DEVICES. WHERE LOCATIONS ARE NOT INDICATED ON ARCHITECTURAL DRAWINGS, COORDINATE LOCATION AND ORIENTATION OF DEVICES IN FIELD WITH ARCHITECT PRIOR TO ROUGH-IN.
- B. ALL DEVICES SHOWN ARE NEW UNLESS NOTED OTHERWISE.
- C. ALL DEVICES TO REMAIN ARE INDICATED WITH A THIN SOLID LINE WEIGHT AND SUBSCRIPT "EX".
- D. CONTRACTOR SHALL VISIT PRIOR TO BID SUBMITTALS TO DETERMINE SITE CONDITIONS EFFECTING THE EXECUTION OF WORK. FAILURE TO BE ACQUAINTED WITH EXISTING CONDITIONS WILL NOT BE JUSTIFICATION FOR ADDITIONAL SERVICES.
- E. PROVIDE FACE PLATES ON ALL J-BOXES ABANDONED IN FINISHED FLOOR, WALL OR CEILINGS. COORDINATE COLOR AND FINISH WITH ARCHITECT. CONTRACTOR TO VERIFY QUANTITY IN THE FIELD.
- F. WHERE EXPOSED CONDUIT IS NOTED, CONTRACTOR SHALL IDENTIFY ROUTING IN FIELD AND OBTAIN ARCHITECT'S APPROVAL OF ROUTING PRIOR TO ROUGH-IN. EXPOSED CONDUIT SHALL BE ROUTED TIGHT TO STRUCTURE.
- G. ALL SINGLE PHASE BRANCH CIRCUITS SHOWN SHALL HAVE DEDICATED NEUTRALS. TO MEET NEC SECTION 210.4 MULTI-WIRE BRANCH CIRCUIT REQUIREMENTS.
- H. REFER TO TECHNOLOGY DRAWINGS FOR CONDUIT ROUGH-IN OIDA, VOICE AND A/V.
- I. ALL 120V BRANCH CIRCUITS ON THIS SHEET SHALL BE FED FROM PANEL 2N1.1 UNLESS NOTED OTHERWISE.

KEYED NOTES


- E01 REFER TO EQUIPMENT DATA SCHEDULE FOR BRANCH CIRCUIT INFORMATION.
- E02 PROVIDE NEW RECEPTACLE FOR MONITOR, COORDINATE MOUNTING HEIGHT WITH ARCHITECTURAL ELEVATIONS AND TECHNOLOGY PLANS.
- E03 PROVIDE NEW RECEPTACLE FOR WALL MOUNTED PROJECTOR. VERIFY EXACT LOCATION AND MOUNTING HEIGHT WITH ARCHITECTURAL ELEVATIONS AND A/V DRAWINGS.
- E05 PROVIDE NEW TWO SECTION ALUMINUM RACEWAY, WIREMOLD AL4320 WITH RECEPTACLES MOUNTED 24" ON CENTER UNLESS NOTED OR SHOWN OTHERWISE. PROVIDE ALL ACCESSORIES FOR A COMPLETE INSTALLATION. REFER TO ARCHITECTURAL ELEVATIONS FOR MOUNTING HEIGHT AND LENGTH. SEE DETAILS ON SHEET E402.
- E06 OUTLET SHALL BE MOUNTED TO THE BACK SIDE OF THE TELECOMMUNICATION RACK AND FED FROM ABOVE. COORDINATE EXACT MOUNTING HEIGHT AND LOCATION WITH TELECOMMUNICATIONS CONTRACTOR PRIOR TO INSTALLATION.
- E07 OUTLET FOR RACK MOUNTED A/V EQUIPMENT. COORDINATE MOUNTING HEIGHT AND EXACT LOCATION WITH ARCHITECTURAL ELEVATIONS AND A/V DRAWINGS.
- E08 OUTLET FOR DIGITAL SIGNAGE. COORDINATE MOUNTING HEIGHT AND EXACT LOCATION WITH ARCHITECTURAL ELEVATIONS AND A/V DRAWINGS.
- E13 PROVIDE A DUCT MOUNTED SMOKE DETECTOR(S) AT RETURN AIR GRILLE OF AHU-1 & AHU-2. BOTH AIR HANDLING UNITS SHALL SHUT DOWN UPON ACTIVATION OF THE DUCT MOUNTED SMOKE DETECTOR(S). PROVIDE REMOTE INDUCTOR LIGHT(S) IN CEILING BELOW.
- E14 SURFACE RACEWAY AT EXTERIOR WINDOWS SHALL BE FED FROM BELOW OR FROM ADJACENT WALL OR COLUMN.
- E16 PROVIDE POWER AND FINAL CONNECTIONS TO FUME HOOD.
- E17 PROVIDE NEMA 6-30R, 30A-208V RECEPTACLE FOR PRINTER. CONTRACTOR SHALL VERIFY PRINTER PLUG TYPE WITH OWNERS REPRESENTATIVE PRIOR TO ROUGH-IN.
- E19 PROVIDE POWER AND FINAL CONNECTION TO ELECTRIC DOOR OPENER. COORDINATE POWER REQUIREMENTS WITH DOOR INSTALLER PRIOR TO ROUGH-IN.
- E20 PROVIDE POWER AND FINAL CONNECTION TO ELECTRIC DOOR OPENER CONTROLS. COORDINATE EXACT LOCATION WITH ARCHITECTURAL DRAWINGS PRIOR TO ROUGH-IN.
- E36 ALL 120V BRANCH CIRCUITS IN THIS ROOM SHALL BE FED FROM PANEL 2L1.1.
- E37 ALL 120V BRANCH CIRCUITS IN THIS ROOM SHALL BE FED FROM PANEL 2L2.
- E38 ALL 120V BRANCH CIRCUITS IN THIS ROOM SHALL BE FED FROM PANEL 2L3.
- E39 ALL 120V BRANCH CIRCUITS IN THIS ROOM SHALL BE FED FROM PANEL 2L4.
- E52 PROVIDE POWER AND FINAL CONNECTIONS TO OVERHEAD SERVICE CARRIER. REFER TO LIGHTING PLANS FOR LIGHTING CIRCUITS. COORDINATE WITH ARCHITECTURAL PLANS AND ELEVATIONS.
- E53 COORDINATE QUANTITY AND LOCATION OF TAMPER AND FLOW SWITCHES WITH FIRE PROTECTION CONTRACTOR.
- E62 PROVIDE A 2HR FIRE CLASSIFIED 2-GANG MULTI-SERVICE STEEL RECESSED FLOOR BOX EQUAL TO WIREMOLD CAT. NO. RFB2S-FC WITH A BRASS FLANGED COVER CAT. NO. FPBTCBS-NA. THE FLOOR BOX SHALL HAVE ALL NECESSARY MOUNTING BRACKETS FOR (2) 20A DUPLEX RECEPTACLES, NEMA L5-20R. THE BOX SHALL BE INSTALLED PER MANUFACTURERS WRITTEN INSTRUCTIONS SO THAT THE COVER IS FLUSH WITH THE FLOOR.
- E63 PROVIDE A 2HR FIRE CLASSIFIED 4-GANG MULTI-SERVICE STEEL RECESSED FLOOR BOX EQUAL TO WIREMOLD CAT. NO. RFB4S-FC WITH A BRASS FLANGED COVER CAT. NO. FPBTCBS-NA. THE FLOOR BOX SHALL HAVE ALL NECESSARY MOUNTING BRACKETS FOR (2) 20A DUPLEX RECEPTACLES, NEMA L5-20R. THE BOX SHALL BE INSTALLED PER MANUFACTURERS WRITTEN INSTRUCTIONS SO THAT THE COVER IS FLUSH WITH THE FLOOR.
- E64 PROVIDE A 2HR FIRE CLASSIFIED 4-GANG MULTI-SERVICE STEEL RECESSED FLOOR BOX EQUAL TO WIREMOLD CAT. NO. RFB2S-FC WITH A BRASS FLANGED COVER CAT. NO. FPBTCBS-NA. THE FLOOR BOX SHALL HAVE ALL NECESSARY MOUNTING BRACKETS FOR (3) 20A TWIST-LOCK RECEPTACLES, NEMA L5-20R, (1) GANG BLANK. THE BOX SHALL BE INSTALLED PER MANUFACTURERS WRITTEN INSTRUCTIONS SO THAT THE COVER IS FLUSH WITH THE FLOOR.
- E70 PROVIDE NEMA L5-20R, 20A-120V TWIST LOCK RECEPTACLE FOR RACK MOUNTED PDU. COORDINATE EXACT LOCATION AND MOUNTING HEIGHT WITH TECHNOLOGY CONTRACTOR.
- E73 PROVIDE POWER AND FINAL CONNECTIONS FOR ELECTRIC HAND DRYER.

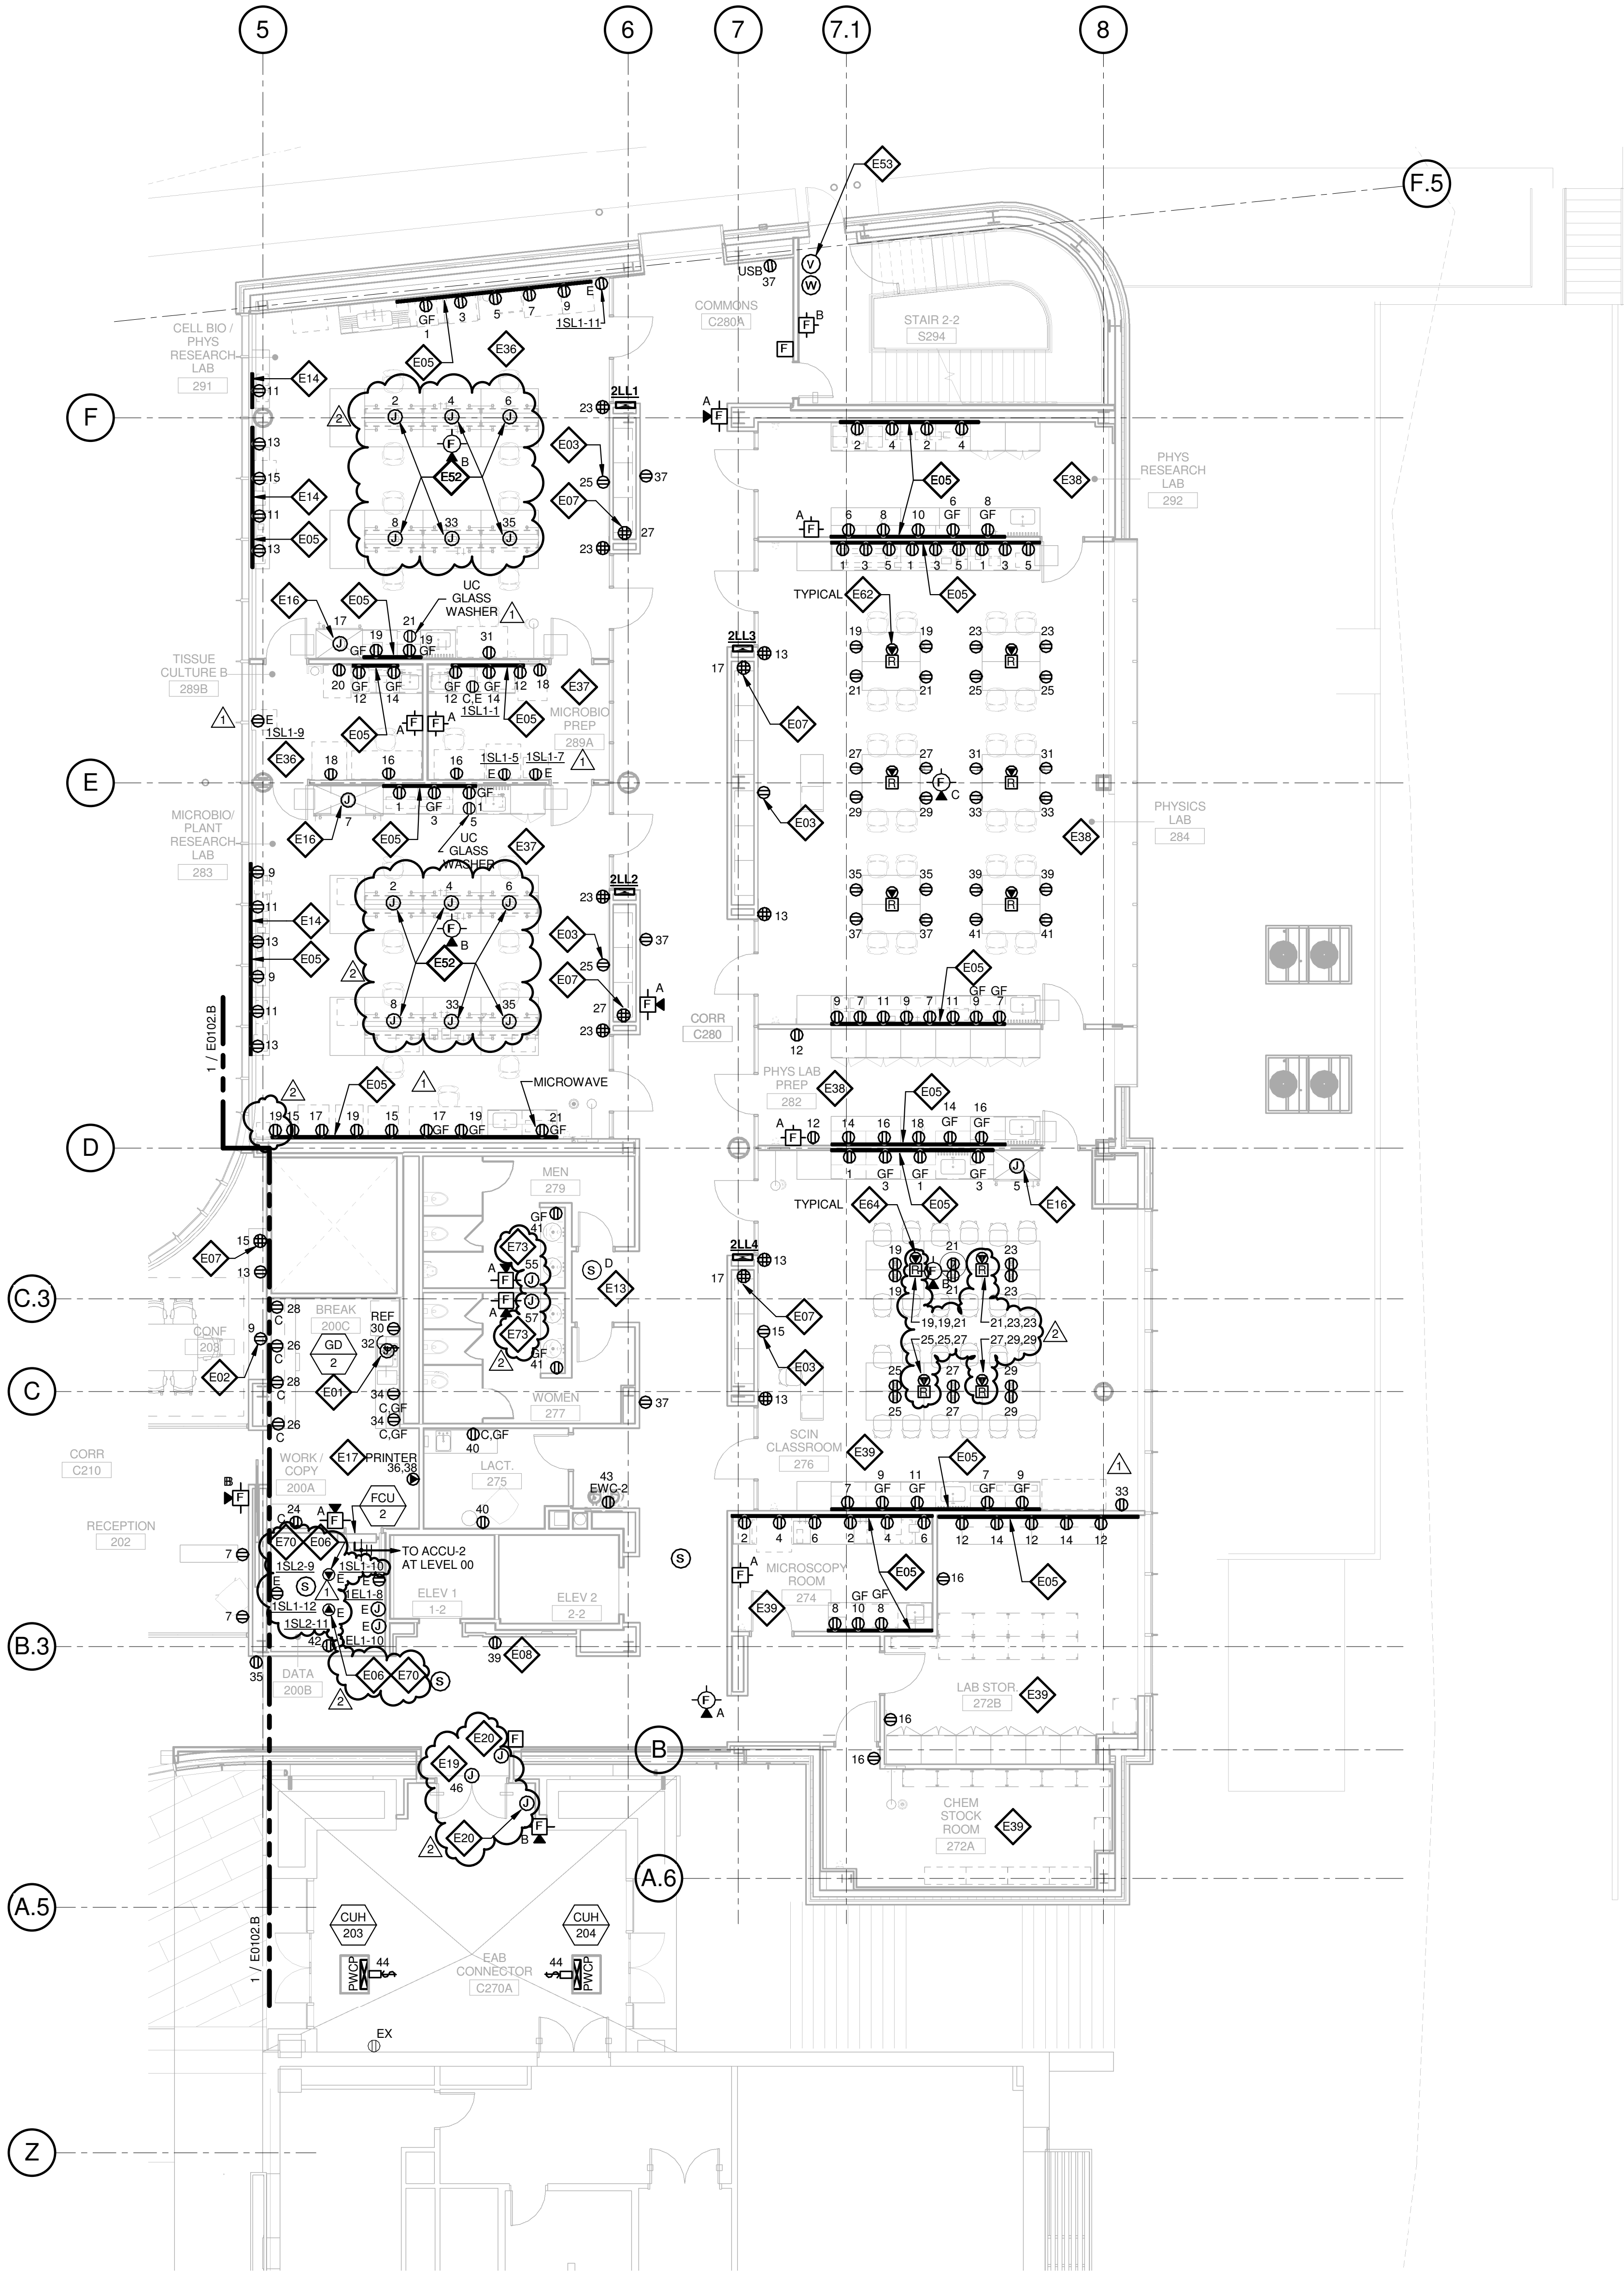

1 LEVEL 02 - AREA A - FLOOR PLAN - POWER AND AUXILLARY
1/8" = 1'-0"

CONFORMED SET 01 JUL 2016

2	ADDENDUM 2-2	19 APRIL 2016
1	ADDENDUM 2-1	17 MAR 2016
-	ISSUED FOR CONSTRUCTION (BP2)	01 MAR 2016

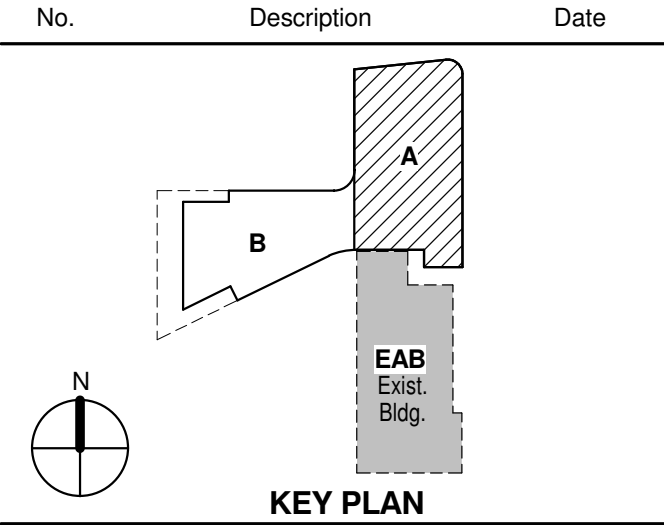

Drawing Title:

LEVEL 02 AREA A FLOOR
PLAN - ELECTRICAL &
AUXILIARY

Project No.: 04561.01 Checked by:

E0102.A