


© Cannon Design 2015
All rights reserved. No part of this document may be reproduced or transmitted in any form or by any means, electronic or mechanical, including photocopying, recording, or by any information storage and retrieval system, without written authorization by The Cannon Corporation.
3/1/2016 12:06:36 PM

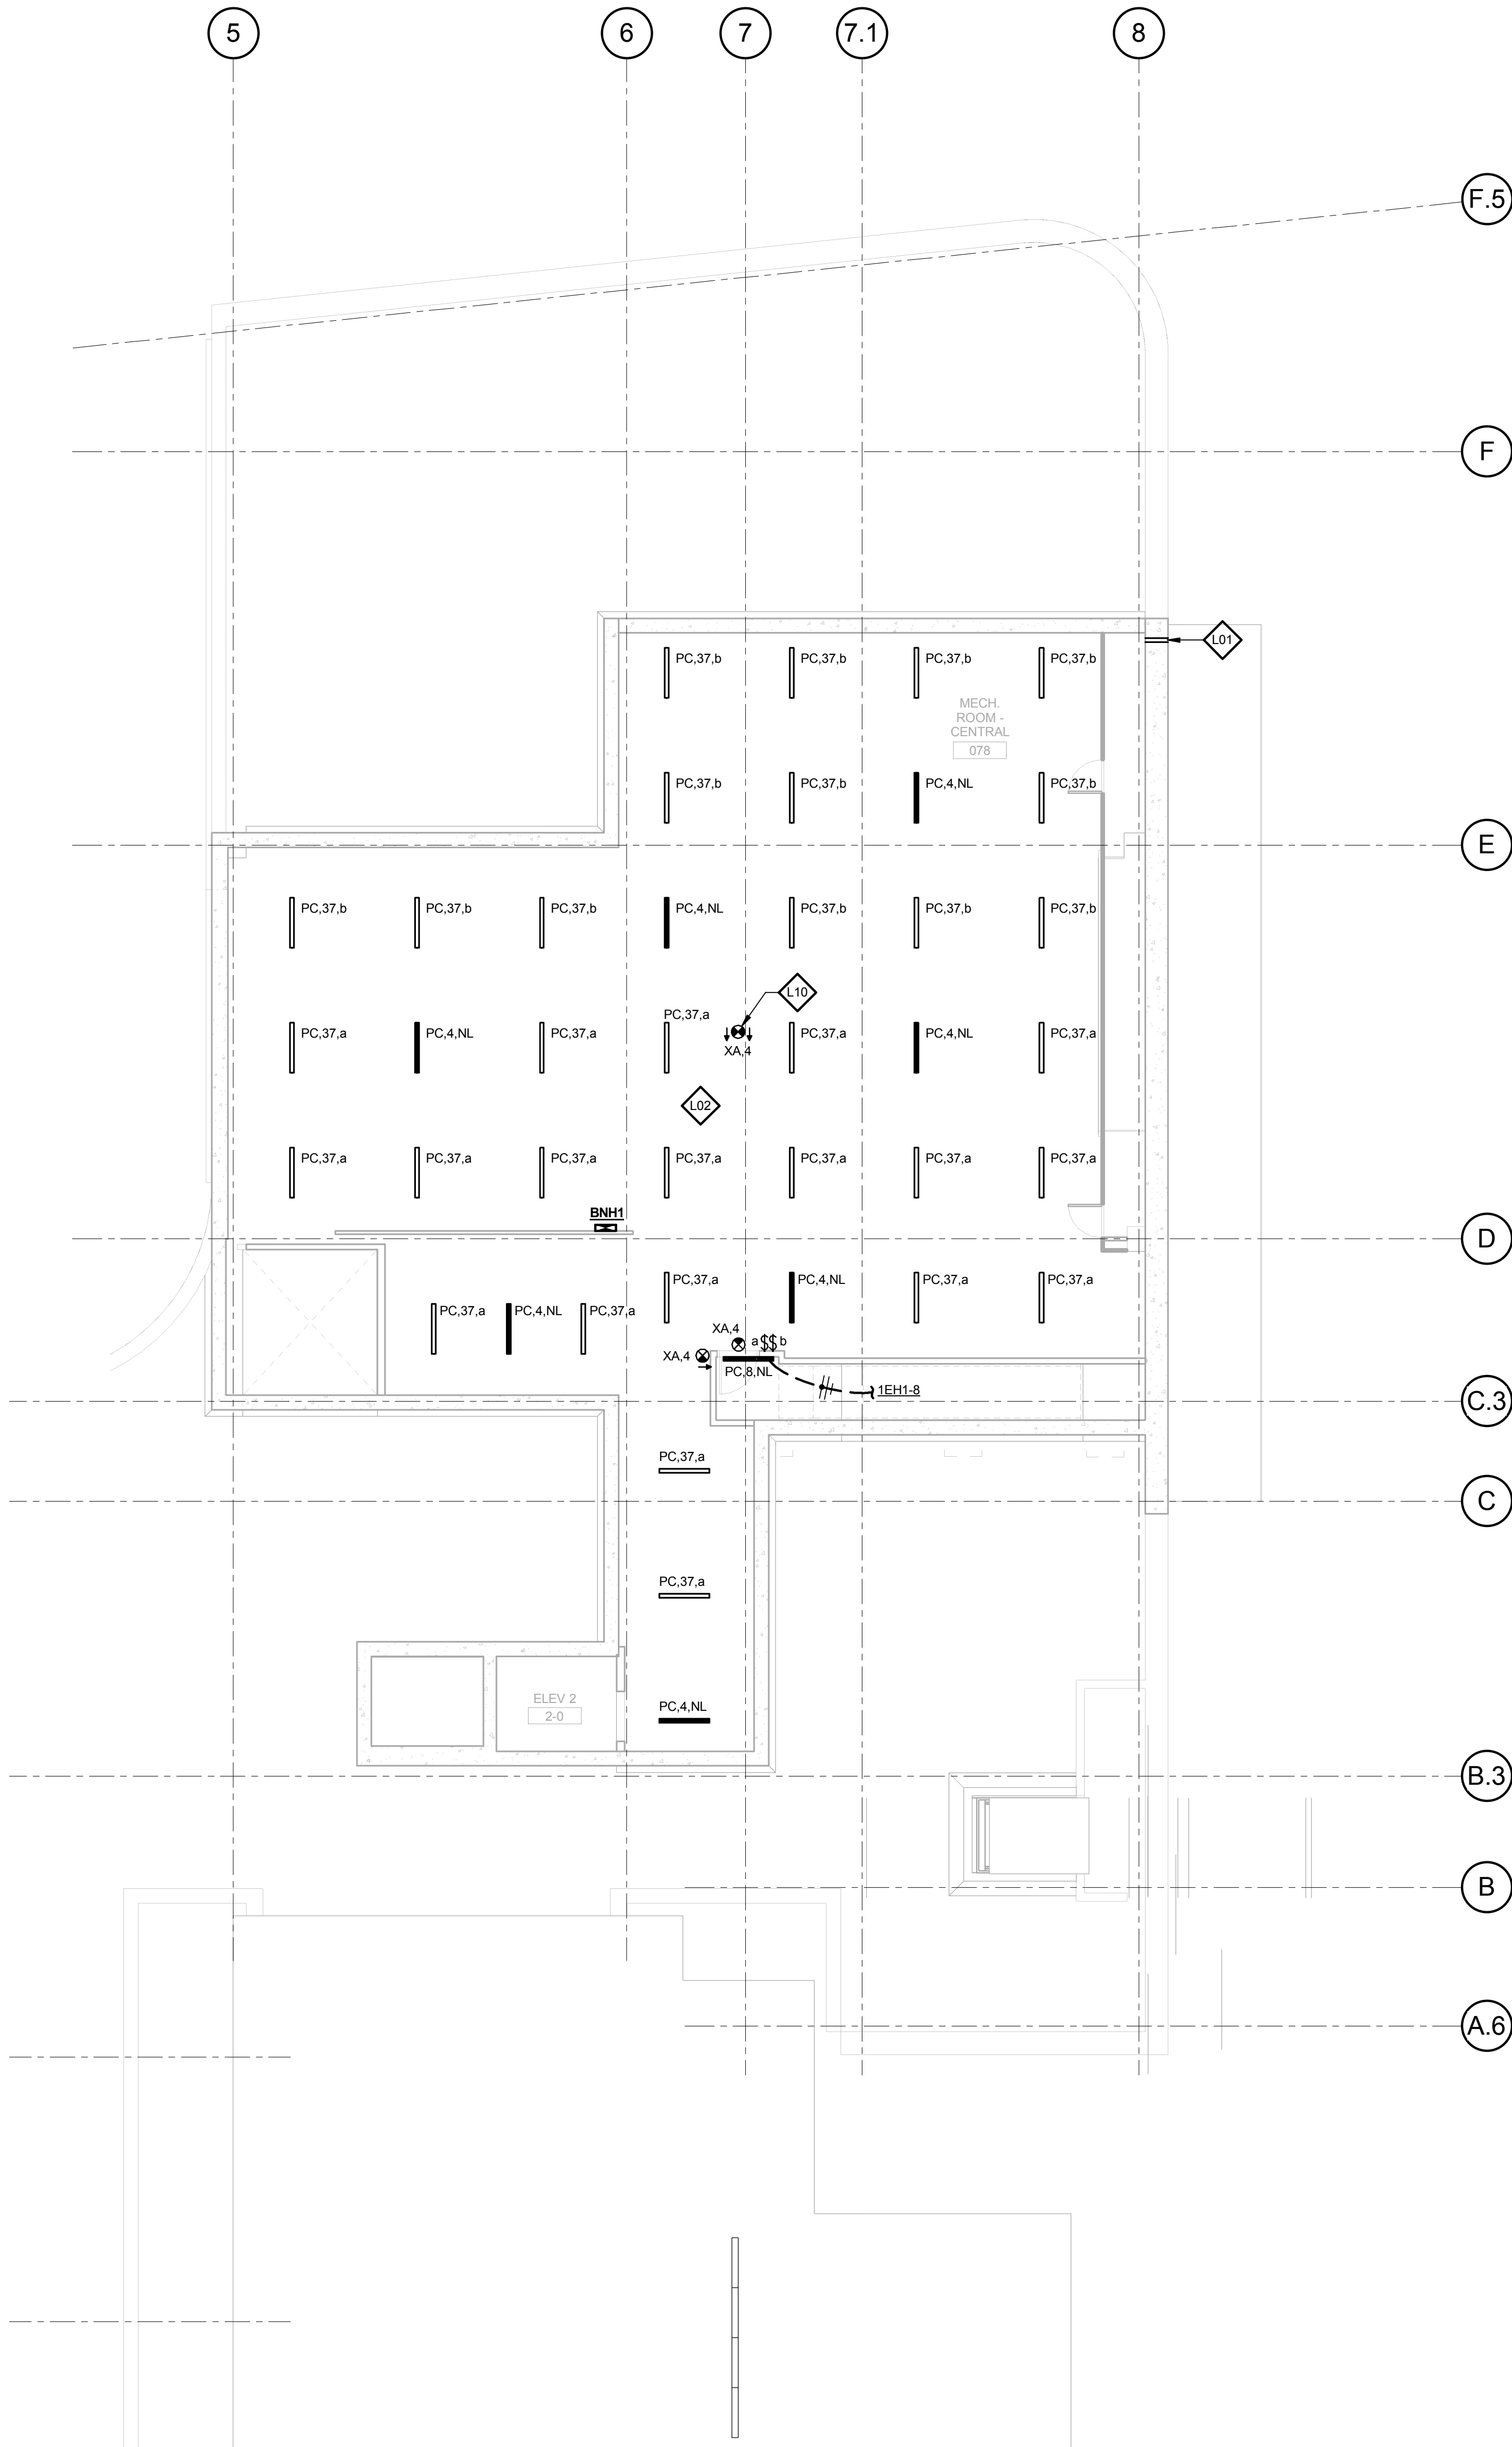

1 LEVEL 00 - AREA A - LIGHTING PLAN
1/8" = 1'-0"

GENERAL NOTES:

- A. DO NOT SCALE DRAWINGS. REFER TO ARCHITECTURAL PLANS AND ELEVATIONS FOR LOCATION AND ORIENTATION OF DEVICES. WHERE LOCATIONS ARE NOT INDICATED ON ARCHITECTURAL DRAWINGS, COORDINATE LOCATION AND ORIENTATION OF DEVICES IN FIELD WITH ARCHITECT PRIOR TO ROUGH-IN.
- B. CONTRACTOR SHALL VISIT PRIOR TO BID SUBMITTALS TO DETERMINE SITE CONDITIONS EFFECTING THE EXECUTION OF WORK. FAILURE TO BE ACQUAINTED WITH EXISTING CONDITIONS WILL NOT BE JUSTIFICATION FOR ADDITIONAL SERVICES.
- C. PROVIDE FACE PLATES ON ALL J-BOXES ABANDONED IN FINISHED FLOOR, WALL OR CEILINGS. COORDINATE COLOR AND FINISH WITH ARCHITECT. CONTRACTOR TO VERIFY QUANTITY IN THE FIELD.
- D. WHERE EXPOSED CONDUIT IS NOTED, CONTRACTOR SHALL IDENTIFY ROUTING IN FIELD AND OBTAIN ARCHITECT'S APPROVAL OF ROUTING PRIOR TO ROUGH-IN. EXPOSED CONDUIT SHALL BE ROUTED TIGHT TO STRUCTURE.
- E. MINIMUM 0-10V CONTROL WIRE SIZE SHALL BE #18 (#16 FOR RUNS LONGER THAN 400').
- F. ALL SINGLE PHASE BRANCH CIRCUITS SHOWN WITH COMMON NEUTRAL SHALL HAVE INDIVIDUAL 20A-1P CIRCUIT BREAKER. CONTRACTOR TO PROVIDE HANDLE TIES TO MEET NEC SECTION 210.4 MULTI-WIRE BRANCH CIRCUIT REQUIREMENTS. REFER TO DRAWINGS FOR CIRCUITS WITH DEDICATED NEUTRALS.
- G. SHADED FIXTURES AND FIXTURES NOTED WITH AN "E" ARE FOR EMERGENCY EGRESS. CONNECT FIXTURES TO LIFE SAFETY PANEL 1EH1.
- H. FIXTURES NOTED WITH "NL" ARE UN-SWITCHED NIGHT LIGHTS AND SHALL BE LEFT ON AFTER HOURS FOR WAY FINDING.
- I. CONNECT NON-EMERGENCY 277V LIGHTING ON THIS FLOOR TO PANEL BNH1.

KEYED NOTES

- L01 PROVIDE CONDUIT (SLEEVE(S) IN FOUNDATION WALL FOR WATER TIGHT SEAL OF ELECTRICAL SITE LIGHTING CONDUIT(S).
- L02 COORDINATE LOCATION OF PENDANT MOUNTED LIGHTS WITH OTHER TRADES, TO AVOID PIPING, DUCTWORK, AND OTHER EQUIPMENT.
- L10 PENDANT MOUNT EXIT SIGN.

THE SEAL(S) AND SIGNATURE(S) APPLY ONLY TO THE DOCUMENT TO WHICH THEY ARE AFFIXED, AND EXPRESSLY DISCLAIM ANY RESPONSIBILITY FOR ALL OTHER PLANS, SPECIFICATIONS, ESTIMATES, REPORTS OR OTHER DOCUMENTS OR INSTRUMENTS RELATING TO OR INTENDED TO BE USED FOR ANY PART OR PARTS OF THE ARCHITECTURAL OR ENGINEERING PROJECT.



Webster University
Interdisciplinary Science
Building

CANNONDESIGN

1100 Clark Avenue
St. Louis, Missouri 63102
T: 314.241.6250
F: 314.241.2570

William Tao & Associates, Inc.
MEP/FP Engineer
7955 Manchester Road, Suite 125
St. Louis, MO 63143
314-884-7600

David Mason & Associates, Inc.
Structural & Civil Engineer
800 South Vandeventer Avenue
St. Louis, MO 63110
314.534.1053

Faith Group
Technology
3101 S. Hanley Rd., Suite 100
St. Louis, MO 63143
314.591.2225

Kuhlmann Leavitt, Inc.
Environmental Graphics & Signage
7400 Pershing Ave.
St. Louis, MO 63130
314.725.6616

KWA Architects
Architecture
8721 Litzinger Road
St. Louis, MO 63124
314.962.2560


Spellman Brady & Company
Interior Designer
8251 Maryland Avenue, Suite 300
St. Louis, MO 63105
314.862.0070

SWT Design
Landscape Architect
7722 Big Bend Blvd
St. Louis, MO 63119
314.644.5700

Webb Engineering Services, Inc.
Plumbing & Fire Protection
1400 S. 3rd Street, Suite 201
St. Louis, MO 63104
314.588.0600

CONFORMED SET 01 JUL 2016

ISSUED FOR CONSTRUCTION (BP2) 01 MAR 2016

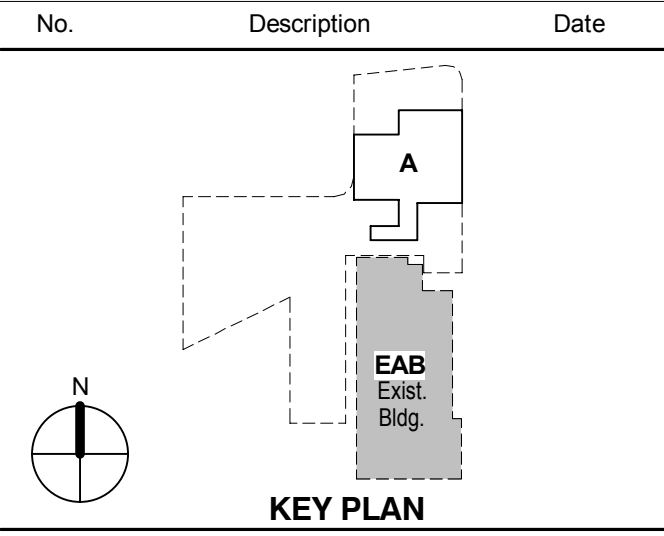

**LEVEL 00 FLOOR PLAN -
LIGHTING**

Project No.: 04561.01 Checked by:

E0200