

© Cannon Design 2015
All rights reserved. No part of this document may be reproduced or transmitted in any form without written authorization by The Cannon Corporation.
4/19/2016 11:16:06 AM

4/19/2016 11:16:06 AM WTA 14127.01 D:\Autodesk\Revit 2015 Local\14127.01.WU_WTA_ME_AJS.rvt

THE SEAL(S) AND SIGNATURE(S) APPLY ONLY TO THE DOCUMENT TO WHICH THEY ARE AFFIXED, AND EXPRESSLY DISCLAIM ANY RESPONSIBILITY FOR ALL OTHER PLANS, SPECIFICATIONS, ESTIMATES, REPORTS OR OTHER DOCUMENTS OR INSTRUMENTS RELATING TO OR INTENDED TO BE USED FOR ANY PART OR PARTS OF THE ARCHITECTURAL OR ENGINEERING PROJECT.



Webster University
Interdisciplinary Science Building

CANNONDESIGN

1100 Clark Avenue
St. Louis, Missouri 63102
T: 314.241.6250
F: 314.241.2570

William Tao & Associates, Inc.
MERFP Engineer
7955 Manchester Road, Suite 125
St. Louis, MO 63143
314-884-7600

David Mason & Associates, Inc.
Structural & Civil Engineer
800 South Vandeventer Avenue
St. Louis, MO 63110
314.534.1053

Faith Group
Technology
3101 S. Hanley Rd. Suite 100
St. Louis, MO 63143
314.991.2229

Kuhmann Leavitt, Inc.
Environmental Graphics & Signage
7400 Pershing Ave
St. Louis, MO 63130
314.725.6616

KWA Architects
Architecture
3721 Litzinger Road
St. Louis, MO 63124
314.962.2560

Spellman Brady & Company
Interior Designer
8251 Maryland Avenue, Suite 300
St. Louis, MO 63105
314.862.0070

SWT Design
Landscape Architect
7722 Big Bend Blvd
St. Louis, MO 63119
314.644.5700


Webb Engineering Services, Inc.
Plumbing & Fire Protection
1400 S. 3rd Street, Suite 201
St. Louis, MO 63104
314.588.0600

GENERAL NOTES:

- DO NOT SCALE DRAWINGS. REFER TO ARCHITECTURAL PLANS AND ELEVATIONS FOR LOCATION AND ORIENTATION OF DEVICES. WHERE LOCATIONS ARE NOT INDICATED ON ARCHITECTURAL DRAWINGS, COORDINATE LOCATION AND ORIENTATION OF DEVICES IN FIELD WITH ARCHITECT PRIOR TO ROUGH-IN.
- CONTRACTOR SHALL VISIT PRIOR TO BID SUBMITTALS TO DETERMINE SITE CONDITIONS EFFECTING THE EXECUTION OF WORK. FAILURE TO BE ACQUAINTED WITH EXISTING CONDITIONS WILL NOT BE JUSTIFICATION FOR ADDITIONAL SERVICES.
- PROVIDE FACE PLATES ON ALL J-BOXES ABANDONED IN FINISHED FLOOR, WALL OR CEILING. COORDINATE COLOR AND FINISH WITH ARCHITECT. CONTRACTOR TO VERIFY QUANTITY IN THE FIELD.
- WHERE EXPOSED CONDUIT IS NOTED, CONTRACTOR SHALL IDENTIFY ROUTING IN FIELD AND OBTAIN ARCHITECT'S APPROVAL OF ROUTING PRIOR TO ROUGH-IN. EXPOSED CONDUIT SHALL BE ROUTED TO THE STRUCTURE.
- MINIMUM 0-10V CONTROL WIRE SIZE SHALL BE #18 (#16 FOR RUNS LONGER THAN 400') DO NOT MIX 0-10V LOW VOLTAGE AND LINE VOLTAGE WIRING UNLESS APPROVED BY CONTRACT'S MANUFACTURER.
- ALL SINGLE PHASE BRANCH CIRCUITS SHOWN WITH COMMON NEUTRAL SHALL HAVE INDIVIDUAL 20A-1P CIRCUIT BREAKER. CONTRACTOR TO PROVIDE HANDLE TIES TO MEET NEC SECTION 210.4 MULTI-WIRE BRANCH CIRCUIT REQUIREMENTS. REFER TO DRAWINGS FOR CIRCUITS WITH DEDICATED NEUTRALS.
- SHADED FIXTURES AND FIXTURES NOTED WITH AN "E" ARE FOR EMERGENCY EGRESS. CONNECT FIXTURES TO LIFE SAFETY PANEL 1EH1.
- FIXTURES NOTED WITH "NL" ARE UN-SWITCHED NIGHT LIGHTS AND SHALL BE LEFT ON AFTER HOURS FOR WAY FINDING.
- WHERE A SWITCH WITH A "D" IS CALLED OUT, PROVIDE LUTRON DIVA 0-10V WALLBOX DIMMER WITH INTEGRAL RELAY. COORDINATE DIMMER VOLTAGE WITH CIRCUIT. WHERE A "3D" IS CALLED OUT, CONFIGURE DIMMER FOR 3-WAY DIMMING.
- CONNECT NON-EMERGENCY 277V LIGHTING ON THIS FLOOR TO PANEL 1NH1. CONNECT SHADES TO NEAREST 120V PANEL.

KEYED NOTES

- L03 THE LIGHTING CONTROLS IN THIS ROOM ARE CONNECTED TO THE BUILDING LIGHTING CONTROL SYSTEM.
- L13 PROVIDE SQUARE-D AUTOMATIC LOAD CONTROL RELAY (OR APPROVED EQUAL) TO CONTROL SWITCHED LIFE SAFETY LIGHTS IN THIS ROOM. CONFIGURE RELAY TO ENSURE LIGHTS ENERGIZE UPON LOSS OF NORMAL POWER. PROVIDE DIMMING RELAY WHERE A DIMMER CONTROLS THE LIGHTS.
- L19 OWNER FURNISHED, CONTRACTOR INSTALLED EXAM LIGHTS. SEE ARCHITECTURAL PLANS FOR EXACT LOCATIONS AND DETAILS FOR MOUNTING STRUCTURE.
- L21 PROVIDE 120 VOLT CIRCUIT FOR MOTORIZED SHADES. COORDINATE WIRING REQUIREMENTS AND LOCATIONS WITH SHADE VENDOR.
- L22 PROVIDE MOTORIZED SHADE SYSTEM CONTROL KEYPAD AND CONFIGURE TO OPERATE MOTORIZED SHADES. REFER TO APPROVED SHOP DRAWINGS FOR SYSTEM WIRING.
- L30 REFER TO SHEET A0501.B FOR STAIR DETAILS. LOCATE REMOTE DRIVERS FOR STAIRWELL FIXTURES IN AN ACCESSIBLE LOCATION. COORDINATE REMOTING DISTANCE WITH MANUFACTURER.
- L33 AIM ADJUSTABLE LIGHTING UNDER THE DIRECTION OF THE ENGINEER.

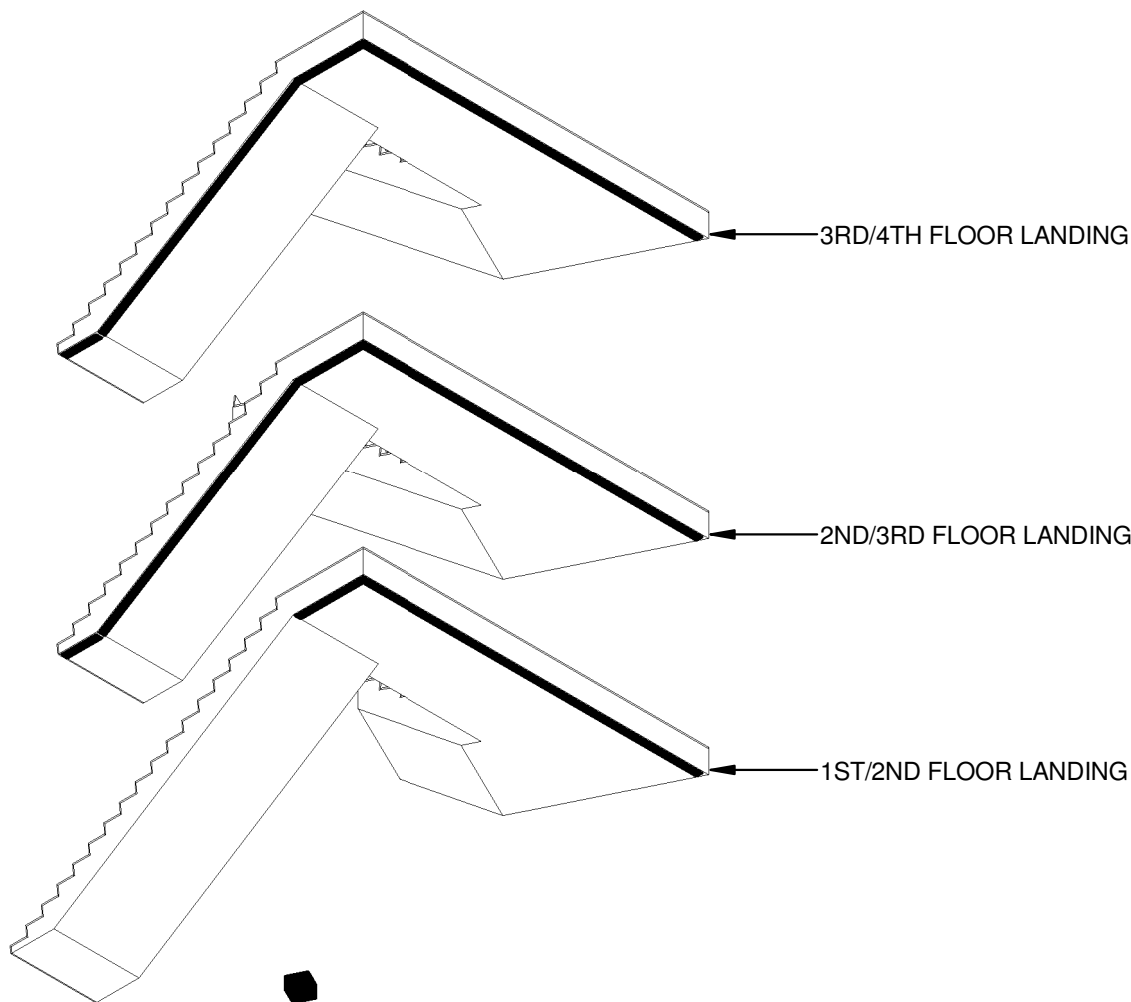

REFER TO ARCHITECTURAL STAIR SECTIONS FOR FIXTURE MOUNTING.


2 STAIRWELL LIGHTING CONCEPT

1 LEVEL 01 - AREA B - LIGHTING PLAN

1/8" = 1'-0"

CONFORMED SET 01 JUL 2016

2	ADDENDUM 2-2	19 APRIL 2016
1	ADDENDUM 2-1	17 MAR 2016
1	ISSUED FOR CONSTRUCTION (BP2)	01 MAR 2016
No.	Description	Date

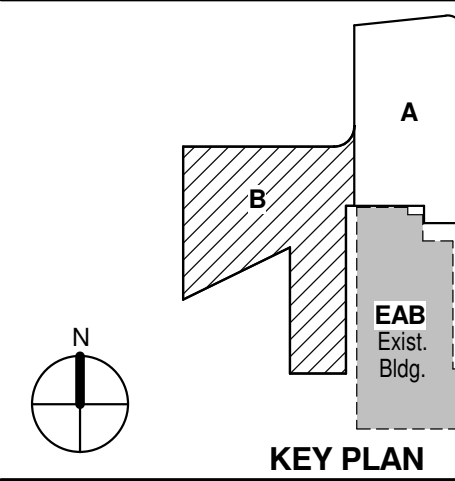

Drawing Title:

LEVEL 01 AREA B FLOOR PLAN - LIGHTING

Project No.: 04561.01 Checked by:

E0201.B

© Cannon Design 2015