

CONFORMED SET 01 JUL 2016

1	ADDENDUM 2-1	17 MAR 2016
1	ISSUED FOR CONSTRUCTION (BP2)	01 MAR 2016
No.	Description	Date


Drawing Title:

RISERS - PLUMBING


Project No.: 04561.01

Checked by:


P0401

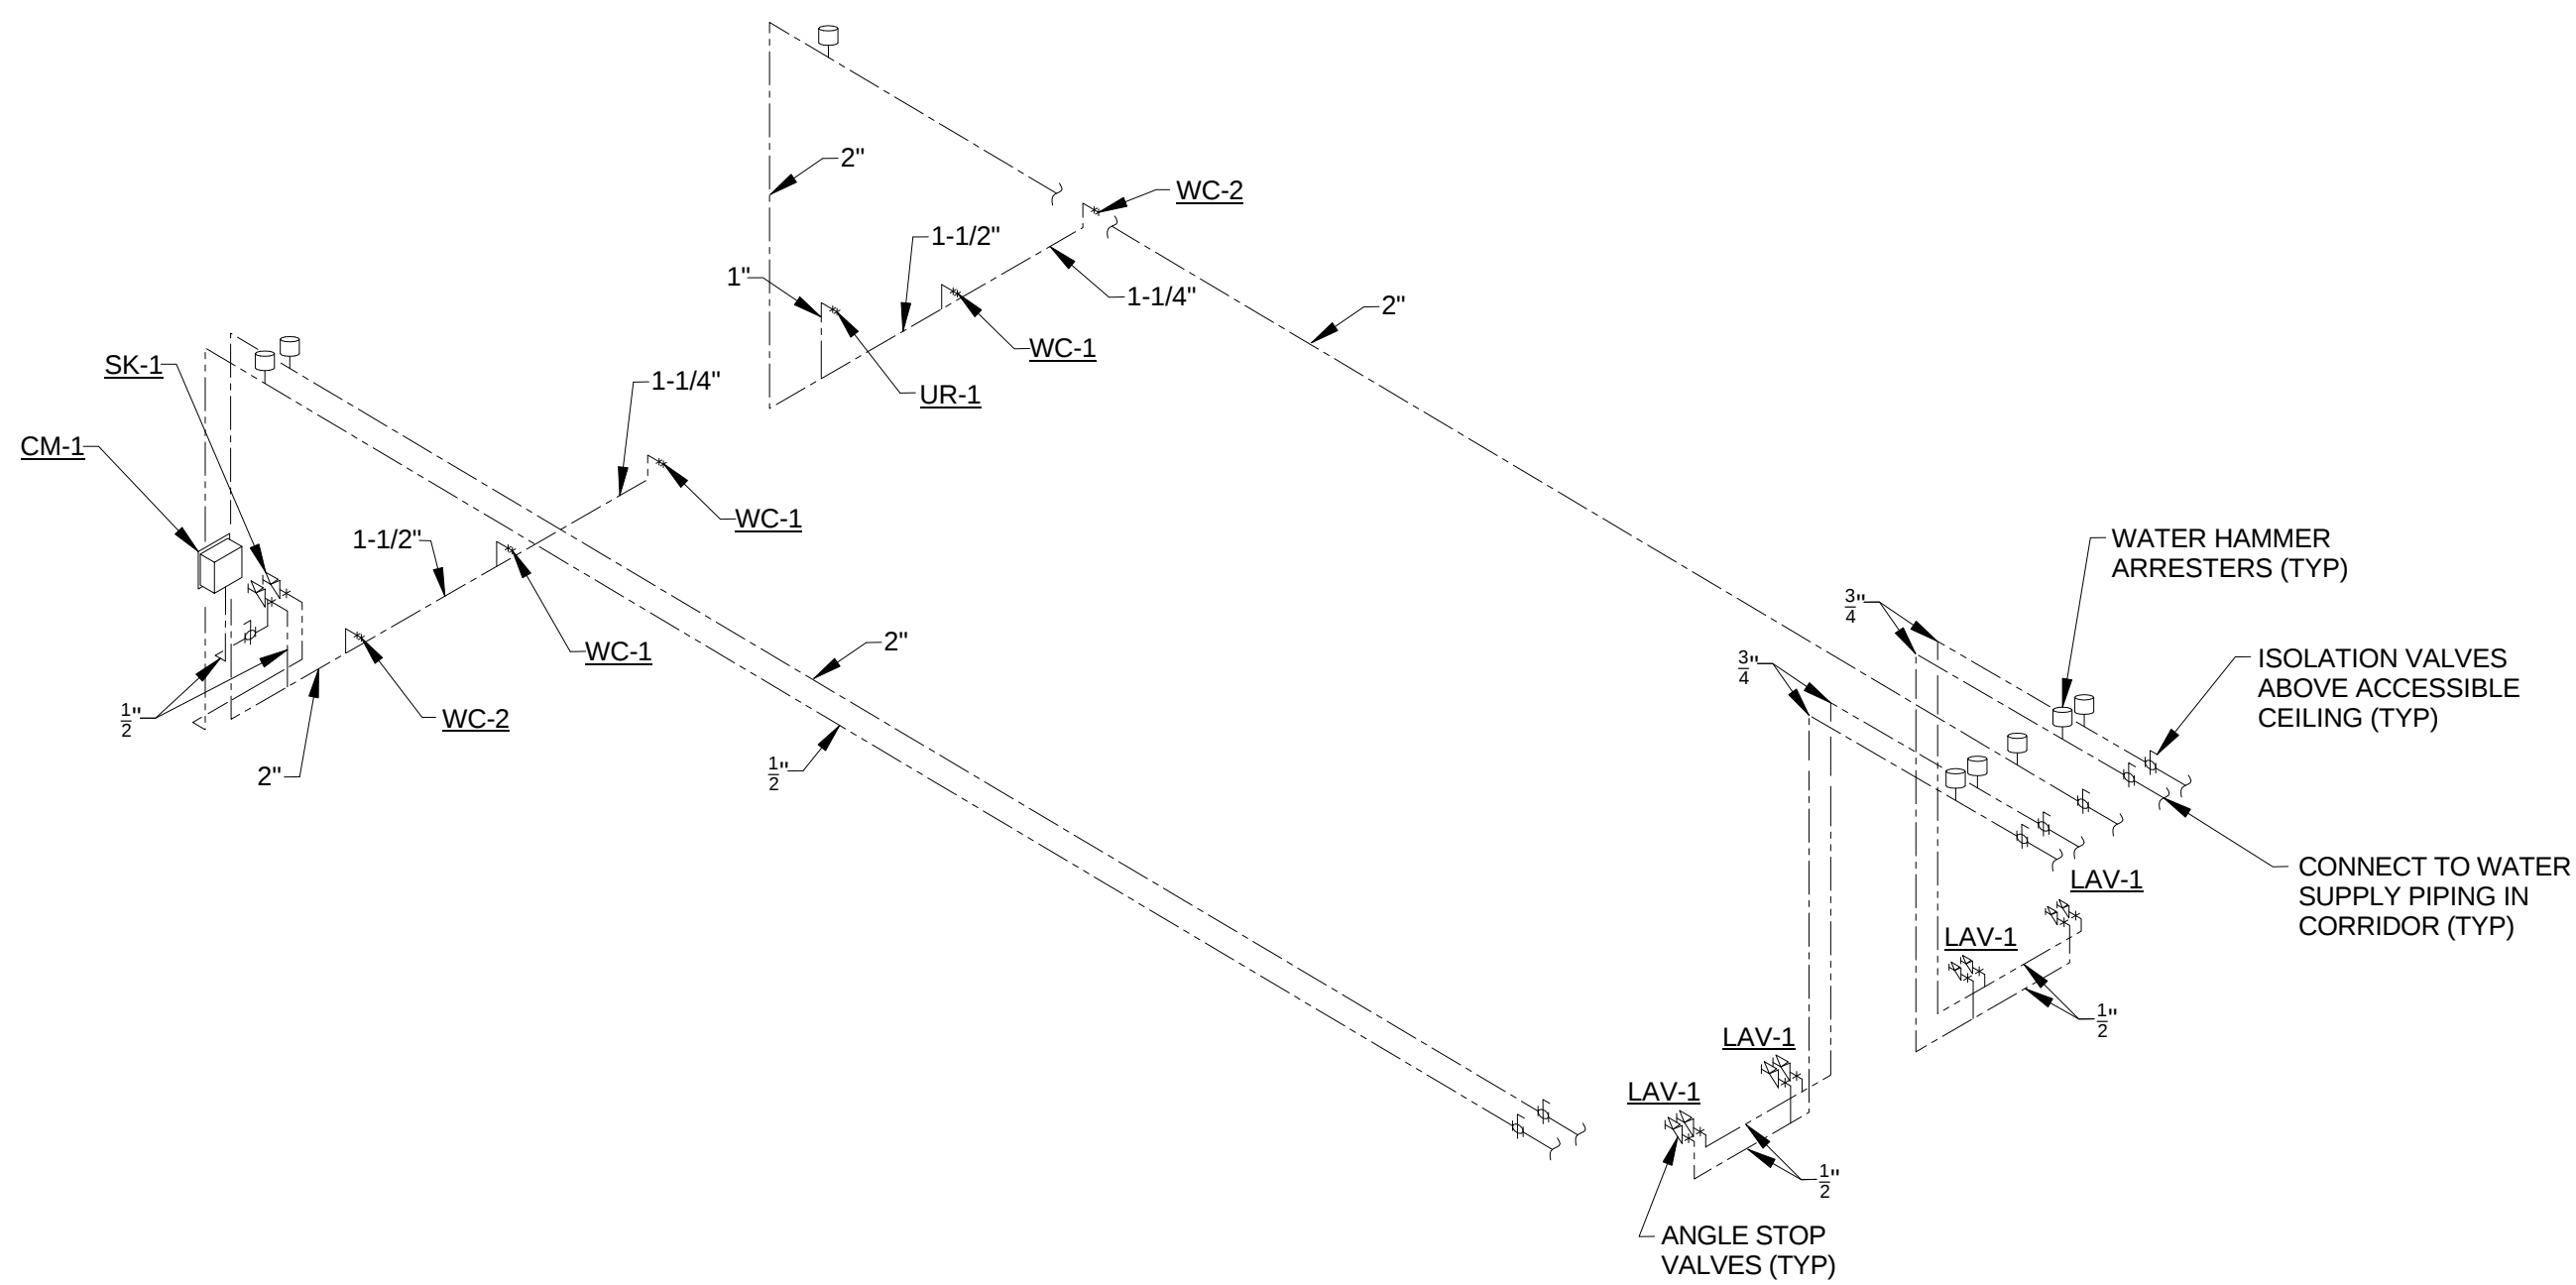


TYPICAL PUBLIC TOILET ROOM WATER SUPPLY DIAGRAM

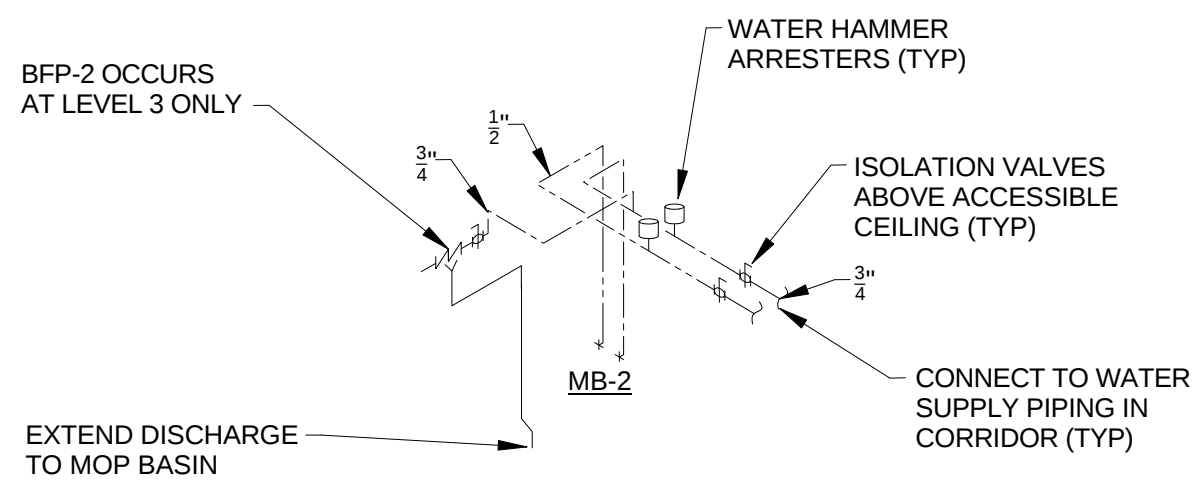

TYPICAL MOP BASIN WATER SUPPLY DIAGRAM

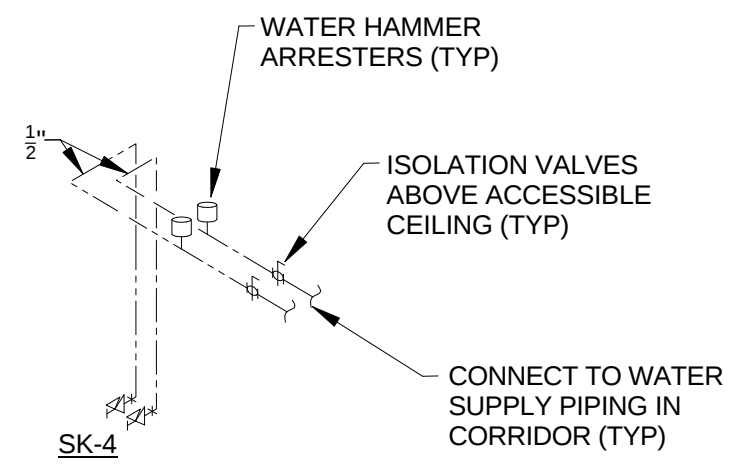

ROOM 275 SINGLE BOWL SINK WATER SUPPLY DIAGRAM

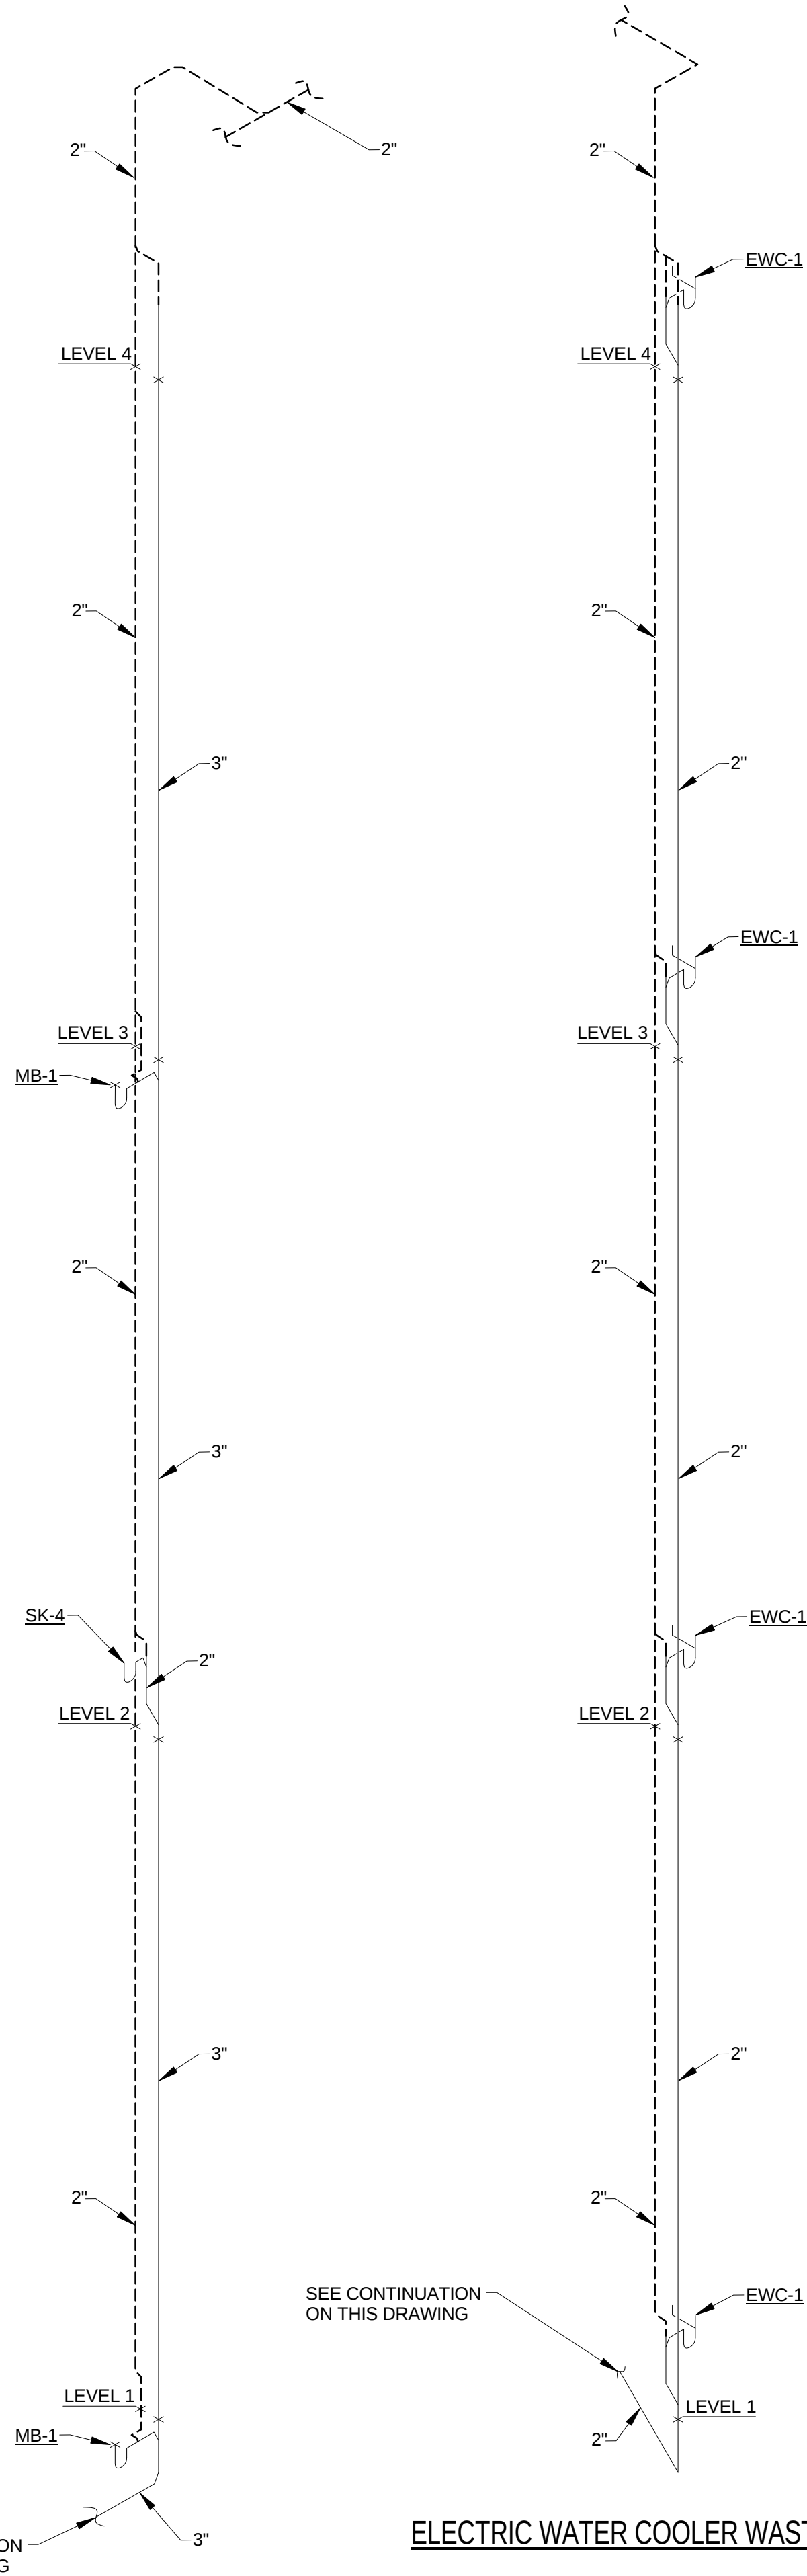

MOP BASIN AND SINK WASTE AND VENT

ELECTRIC WATER COOLER WASTE AND VENT

PUBLIC TOILET ROOM WASTE AND VENT

1 CENTER CORE PLUMBING RISERS
P0401 SCALE: N.T.S.