

CONFORMED SET

01 JUL 2016

2	ADDENDUM 2-4	24 MAY 2016
1	ADDENDUM 2-2	19 APR 2016
	ISSUED FOR CONSTRUCTION (BP2)	01 MAR 2016
No.	Description	Date

Drawing Title:

RISERS - PLUMBING

Project No.: 04561.01


Checked by:

P0404


© Cannon Design 2015

KEYED NOTES (THIS SHEET ONLY)


- 1 REFER TO DRAWING P0503, DETAIL 2/P0503 FOR TYPICAL LAB SINK WASTE CONNECTION DETAIL.
- 2 REFER TO DRAWING P0403, DETAIL 3/P0403 FOR TYPICAL EMERGENCY SHOWER PIPING DIAGRAM. COORDINATE PENETRATION THROUGH THE FLOOR WITH THE STRUCTURE BELOW AND THE ARCHITECTURAL DRAWINGS, OFF-SET THE PIPING AS REQUIRED.
- 3 OFF-SET VENT PIPING INTO THE WALL CAVITY TO EXTEND ABOVE THE CEILING. TYPICAL FOR LAB SINKS OR WHERE APPLICABLE.
- 4 WASTE PIPING TO BE LOCATED IN THE UTILITY SPACE BETWEEN THE WALL AND BACK OF CASEWORK. COORDINATE PENETRATION THROUGH THE FLOOR WITH THE STRUCTURE BELOW AND THE ARCHITECTURAL DRAWINGS, OFF-SET PIPING AS REQUIRED. TYPICAL FOR LAB SINKS OR WHERE APPLICABLE.
- 5 COORDINATE ROUTING AND INSTALLATION OF THE WASTE AND VENT PIPING ABOVE THE CEILING WITH STRUCTURAL ELEMENTS AND OTHER TRADES ON THIS PROJECT. HOLD PIPING AS HIGH AS POSSIBLE, WHERE POSSIBLE. TYPICAL FOR ALL ABOVE THE CEILING PIPING.
- 6 EXTEND WASTE FROM EMERGENCY SHOWER HORIZONTAL IN WALL CAVITY TO AN AREA BEHIND THE LABORATORY CASE WORK. TURN PIPING OUT OF WALL WITHIN UTILITY SPACE BEHIND THE CASEWORK TO TURN DOWN THROUGH THE FLOOR. COORDINATE PENETRATION THROUGH THE FLOOR WITH THE STRUCTURE BELOW AND THE ARCHITECTURAL DRAWINGS, OFF-SET PIPING AS REQUIRED.

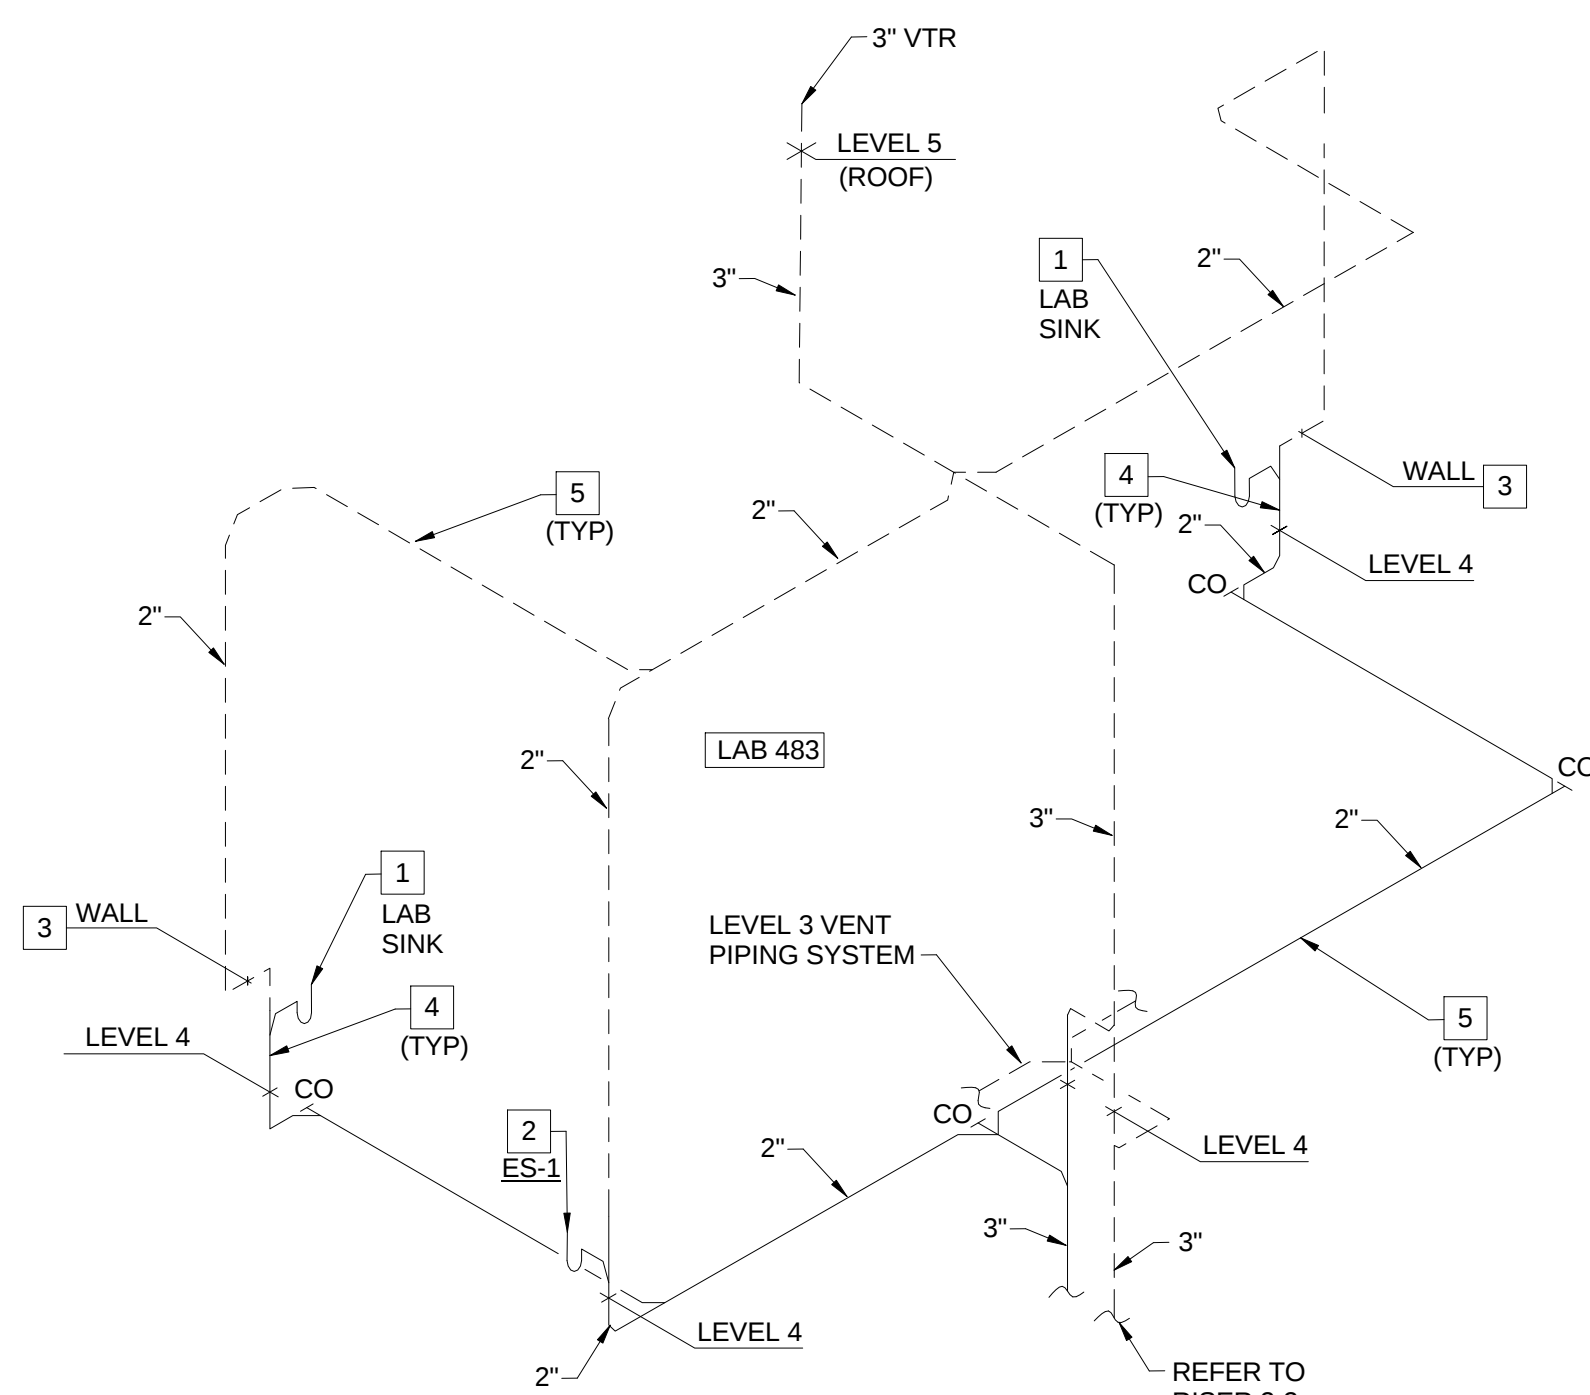

2-4 SANITARY WASTE AND VENT RISER - LAB 483

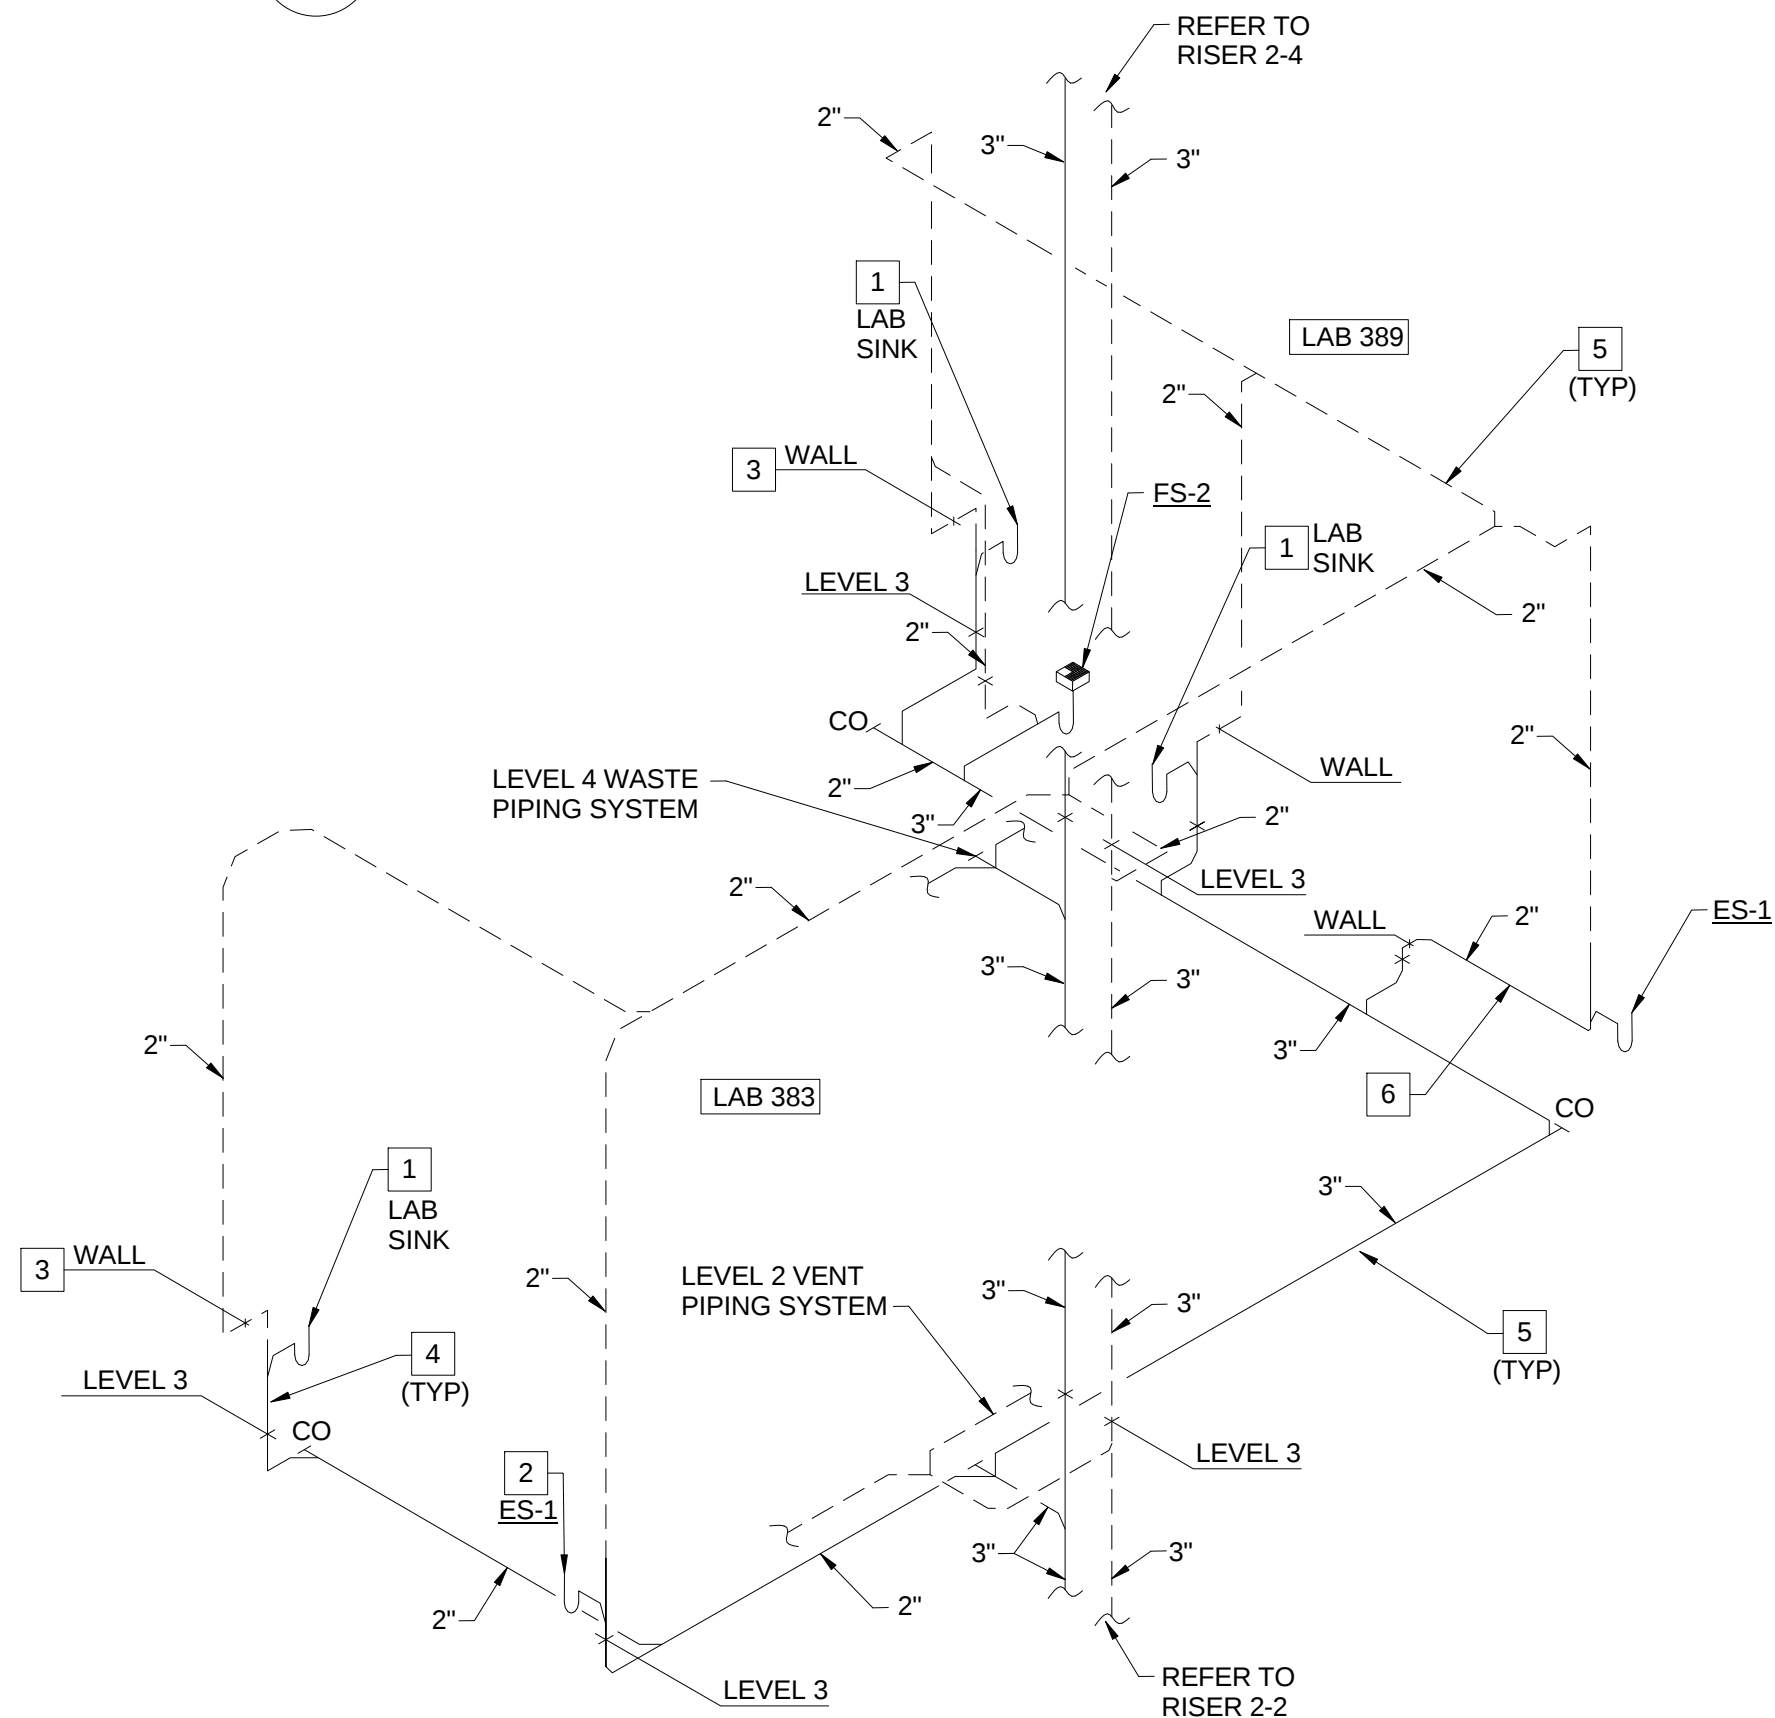


2-3 SANITARY WASTE AND VENT RISER - LAB 383 AND PREP 389

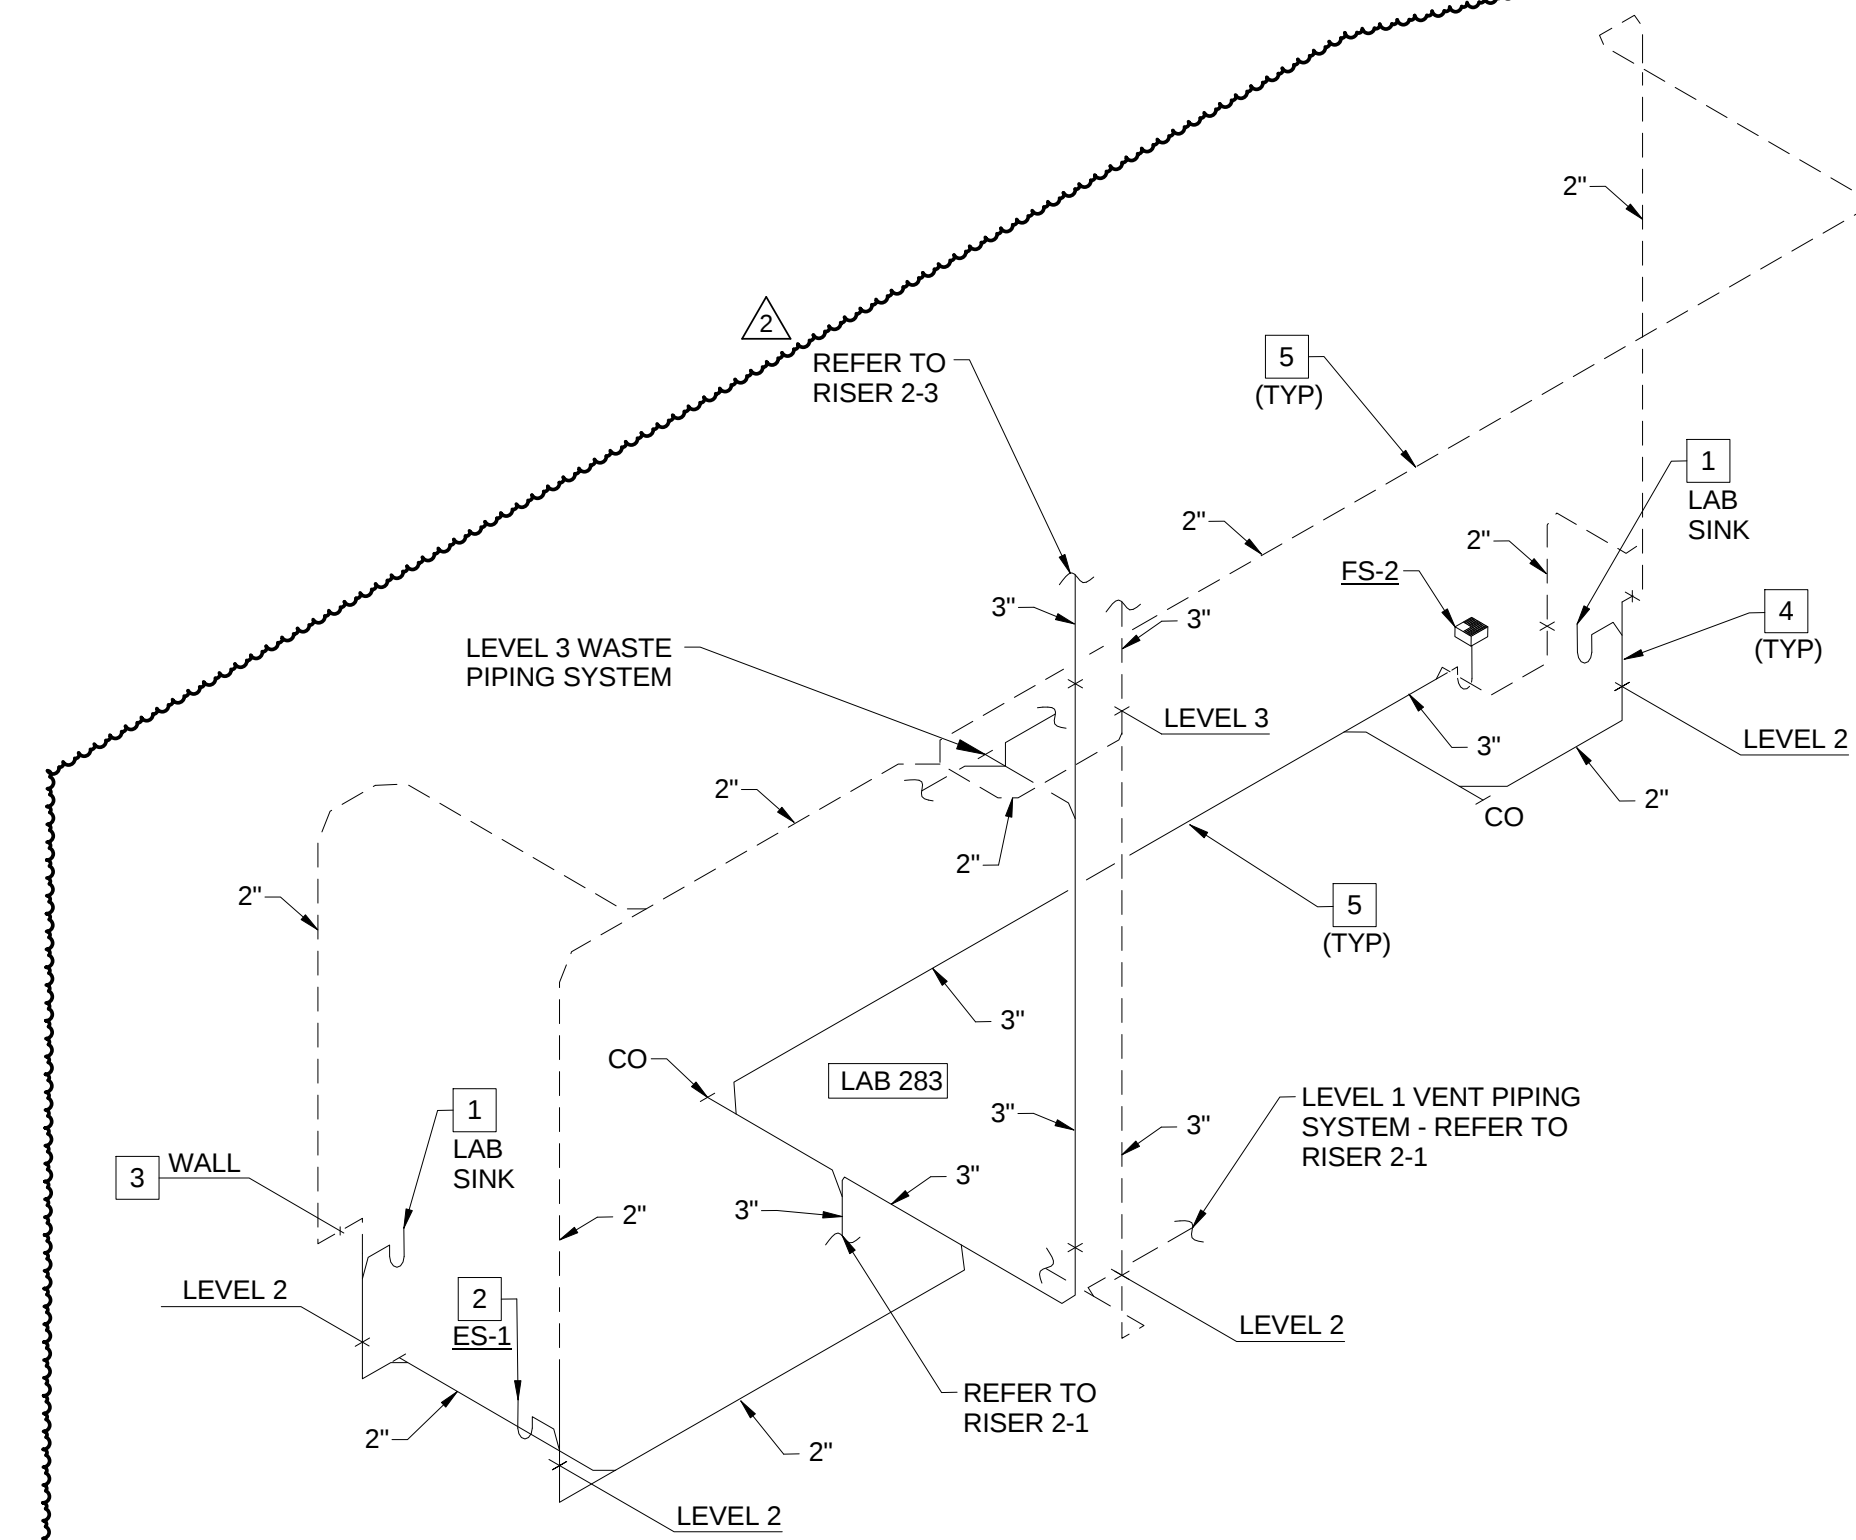

2-2 SANITARY WASTE AND VENT RISER - LAB 283

PLUMBING WASTE AND VENT FOR PLUMBING RISER PR-2

SCALE: N.T.S.

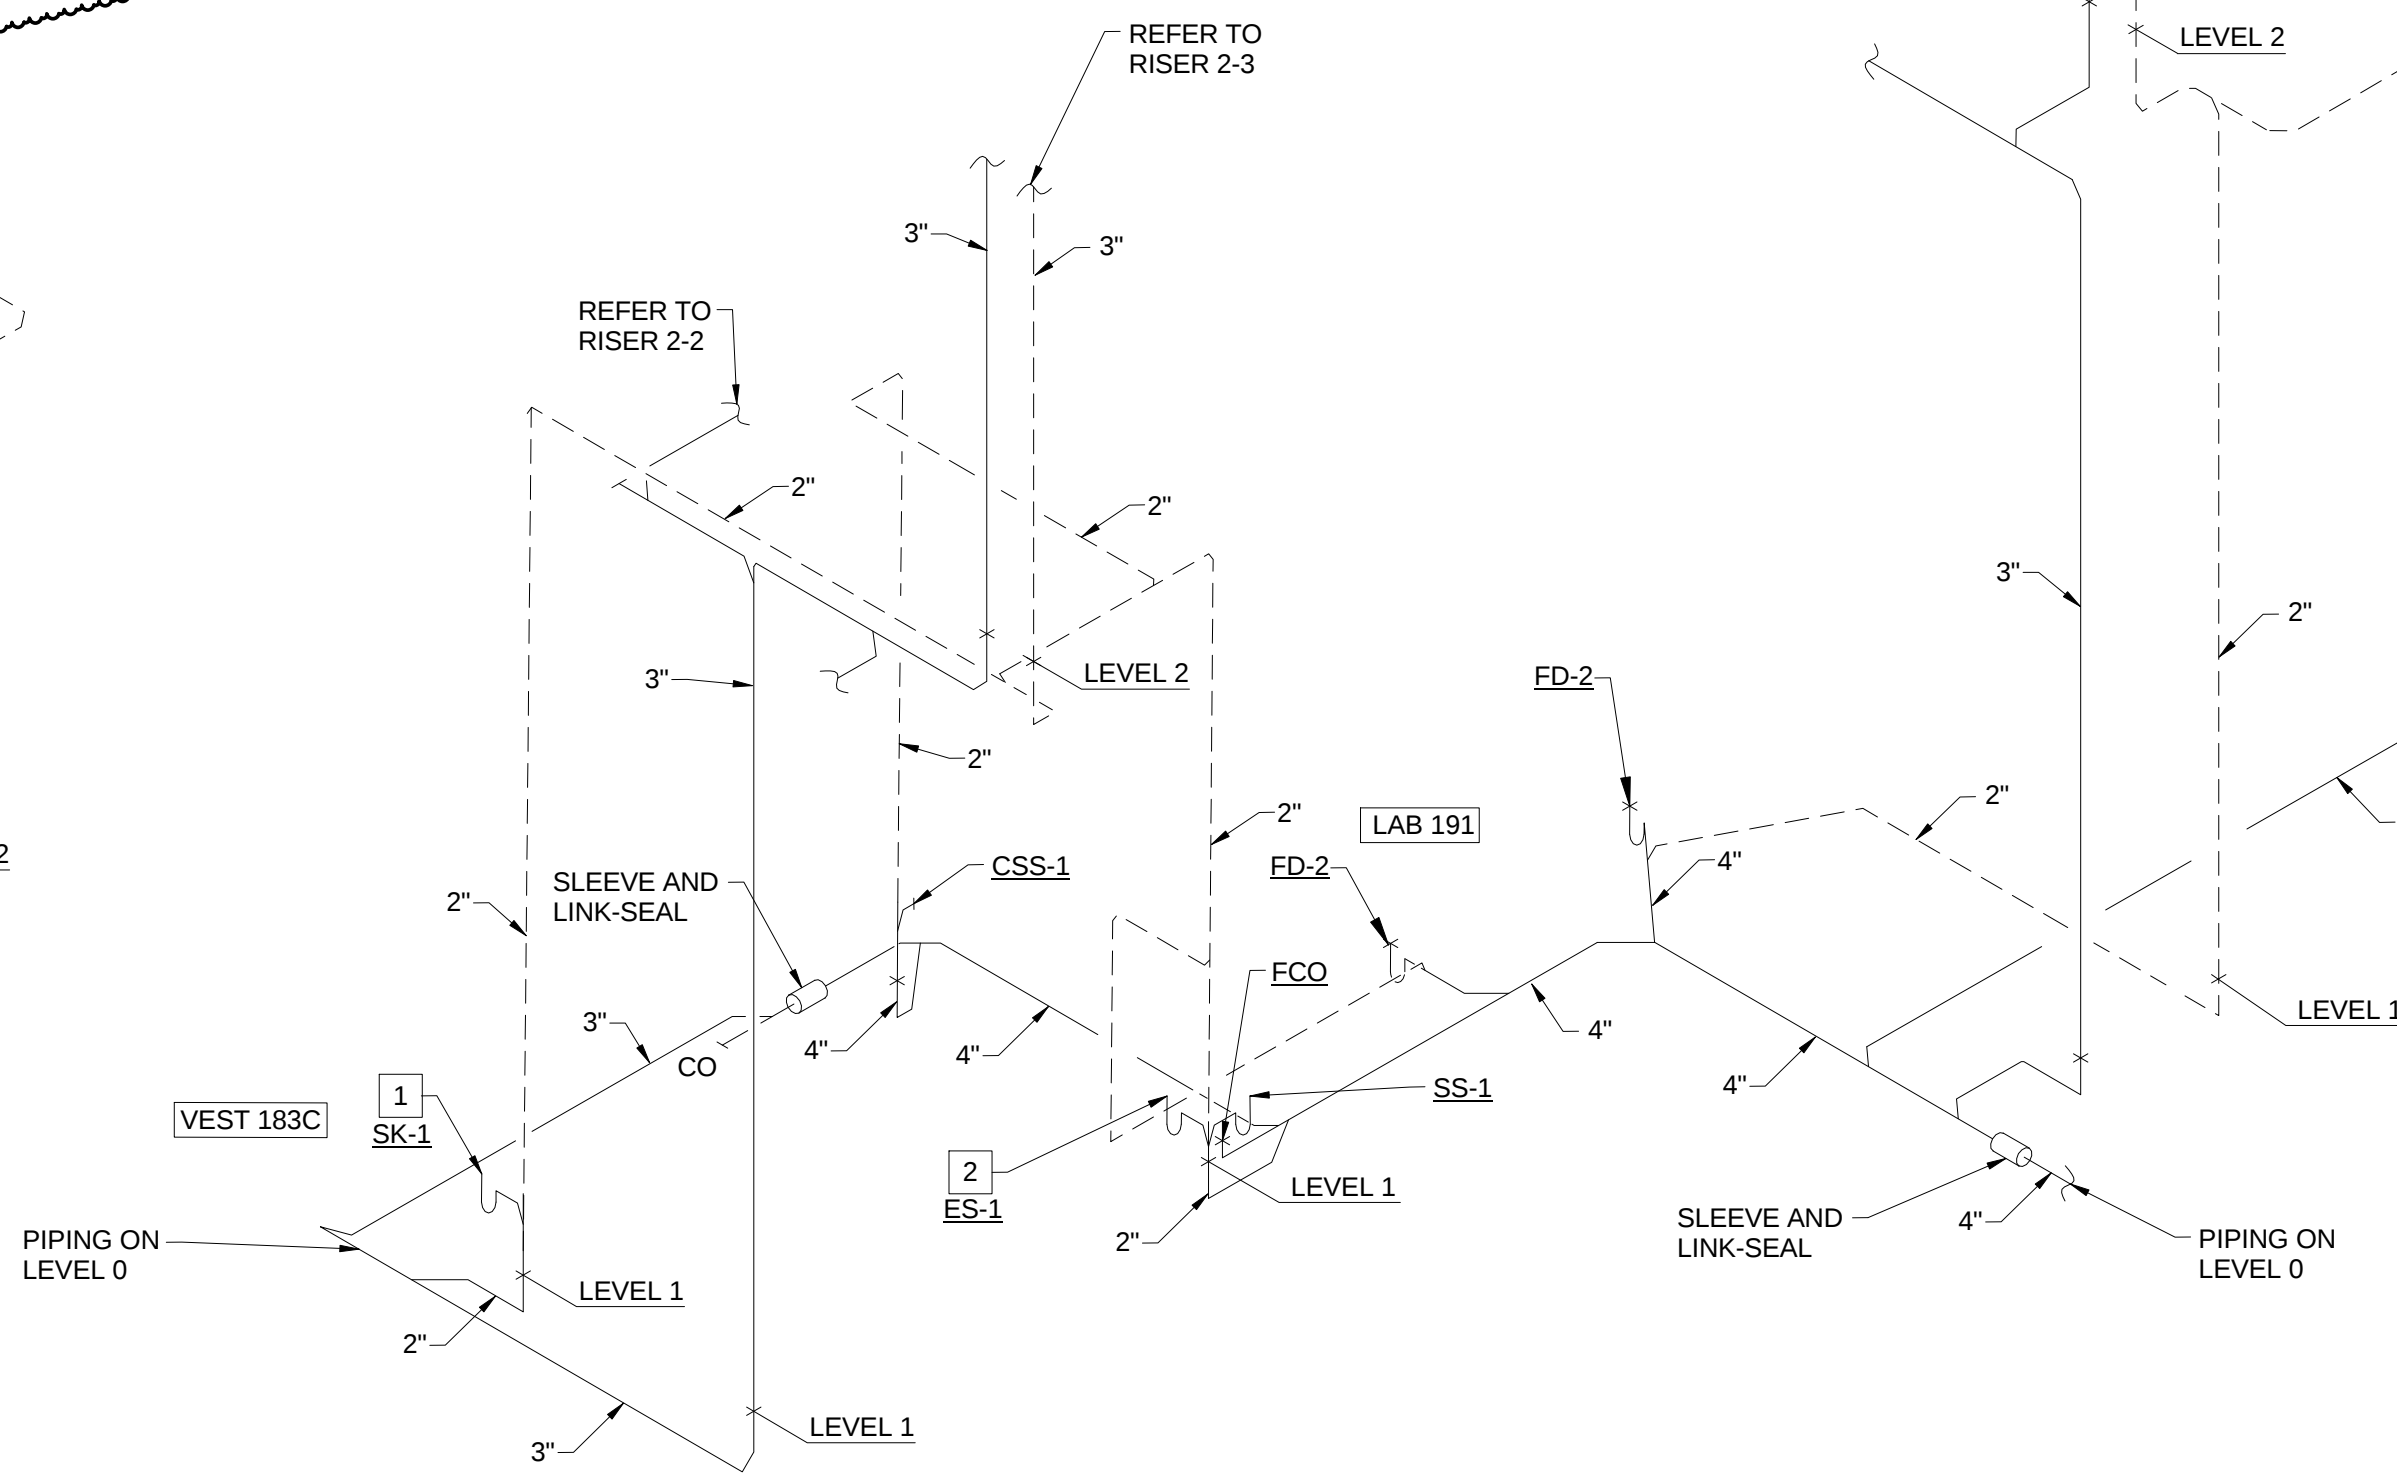


2-1 SANITARY WASTE AND VENT RISER - VESTIBULE 183C AND LAB 191


1 PLUMBING WASTE AND VENT RISERS FOR PLUMBING RISERS PR-1 AND PR-2

P0404


SCALE: N.T.S.

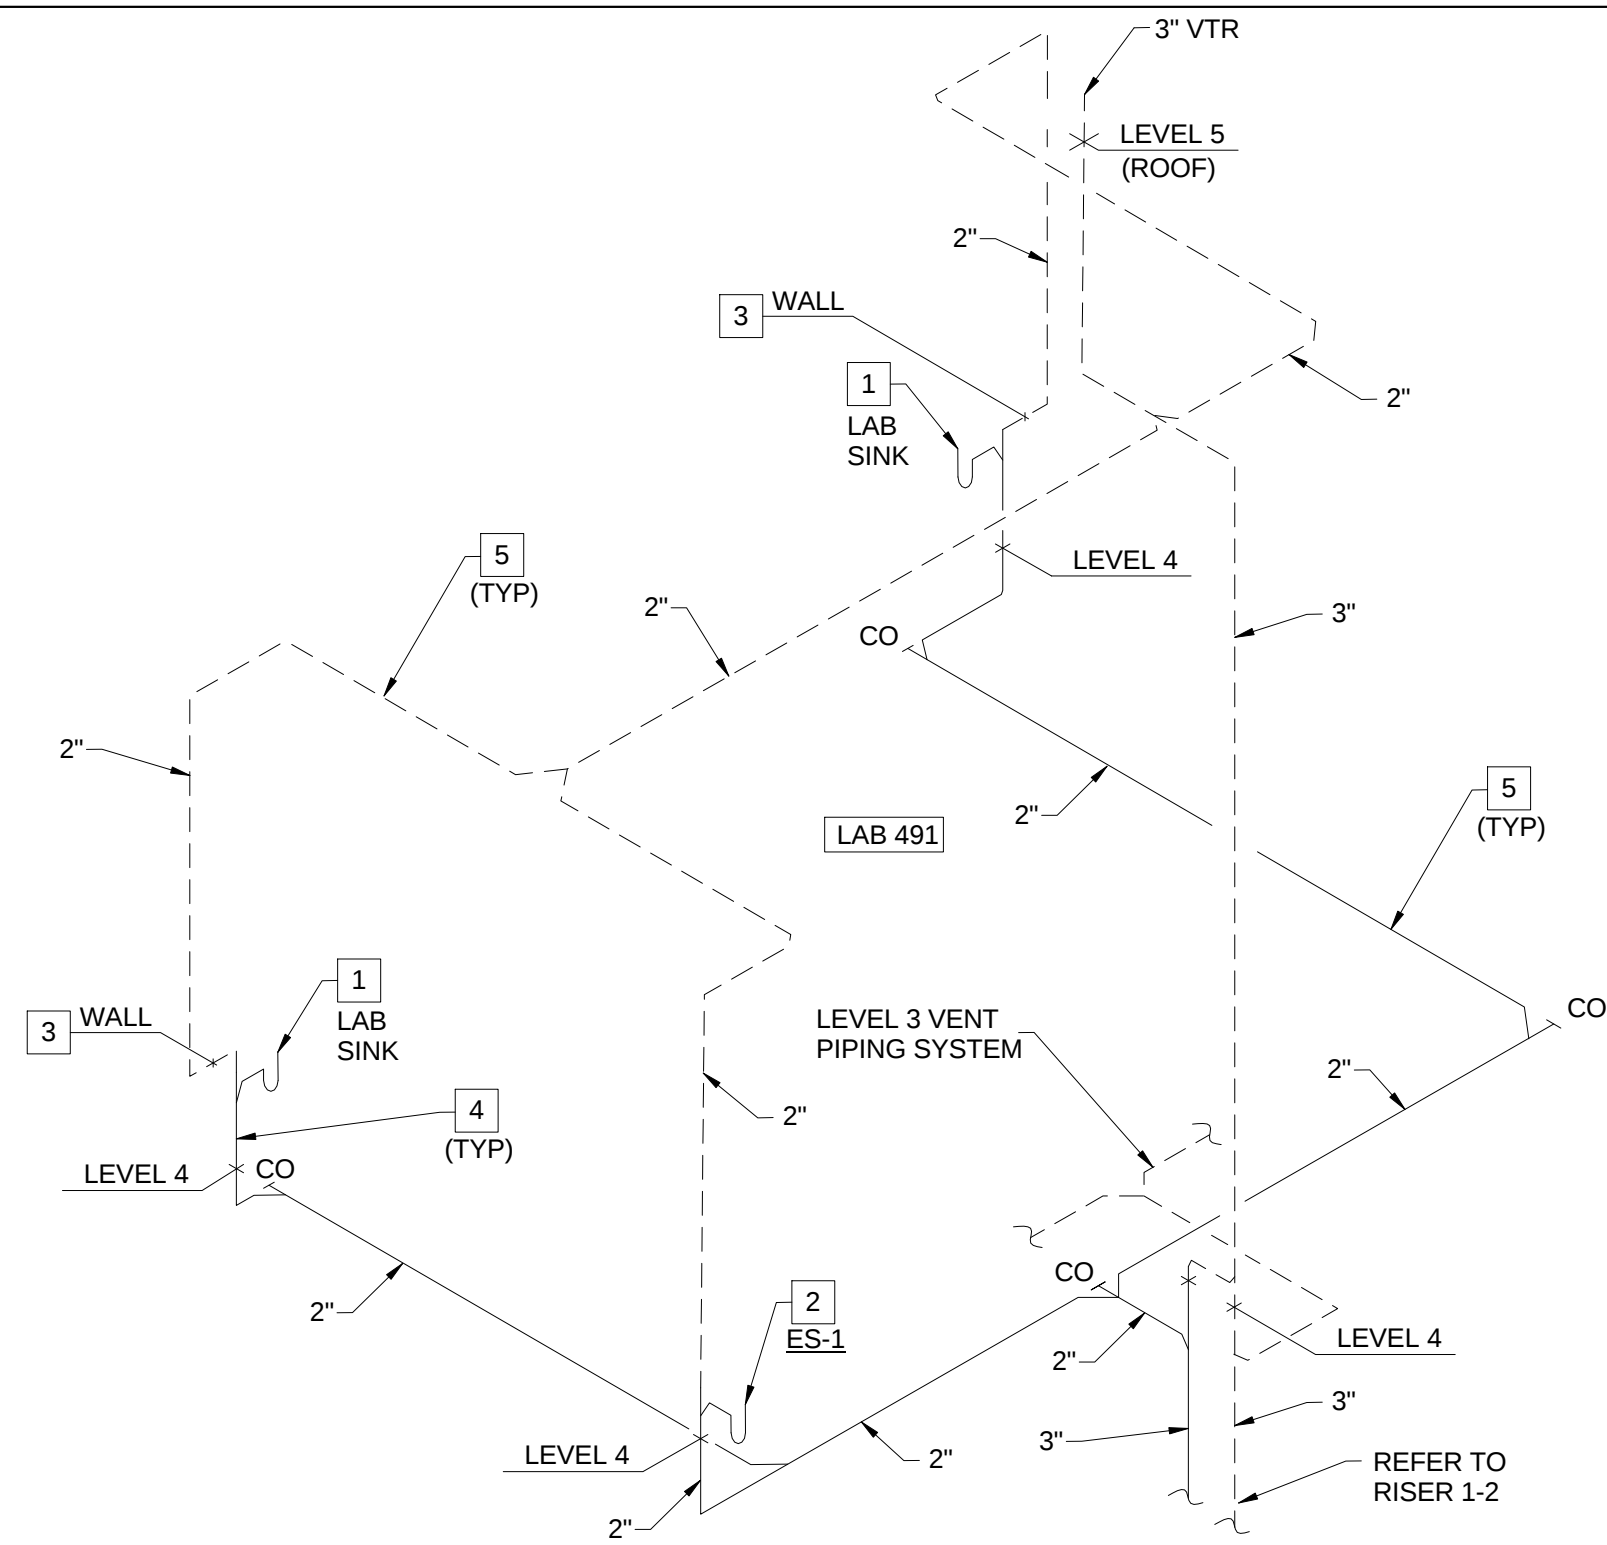

1-3 SANITARY WASTE AND VENT RISER - LAB 491

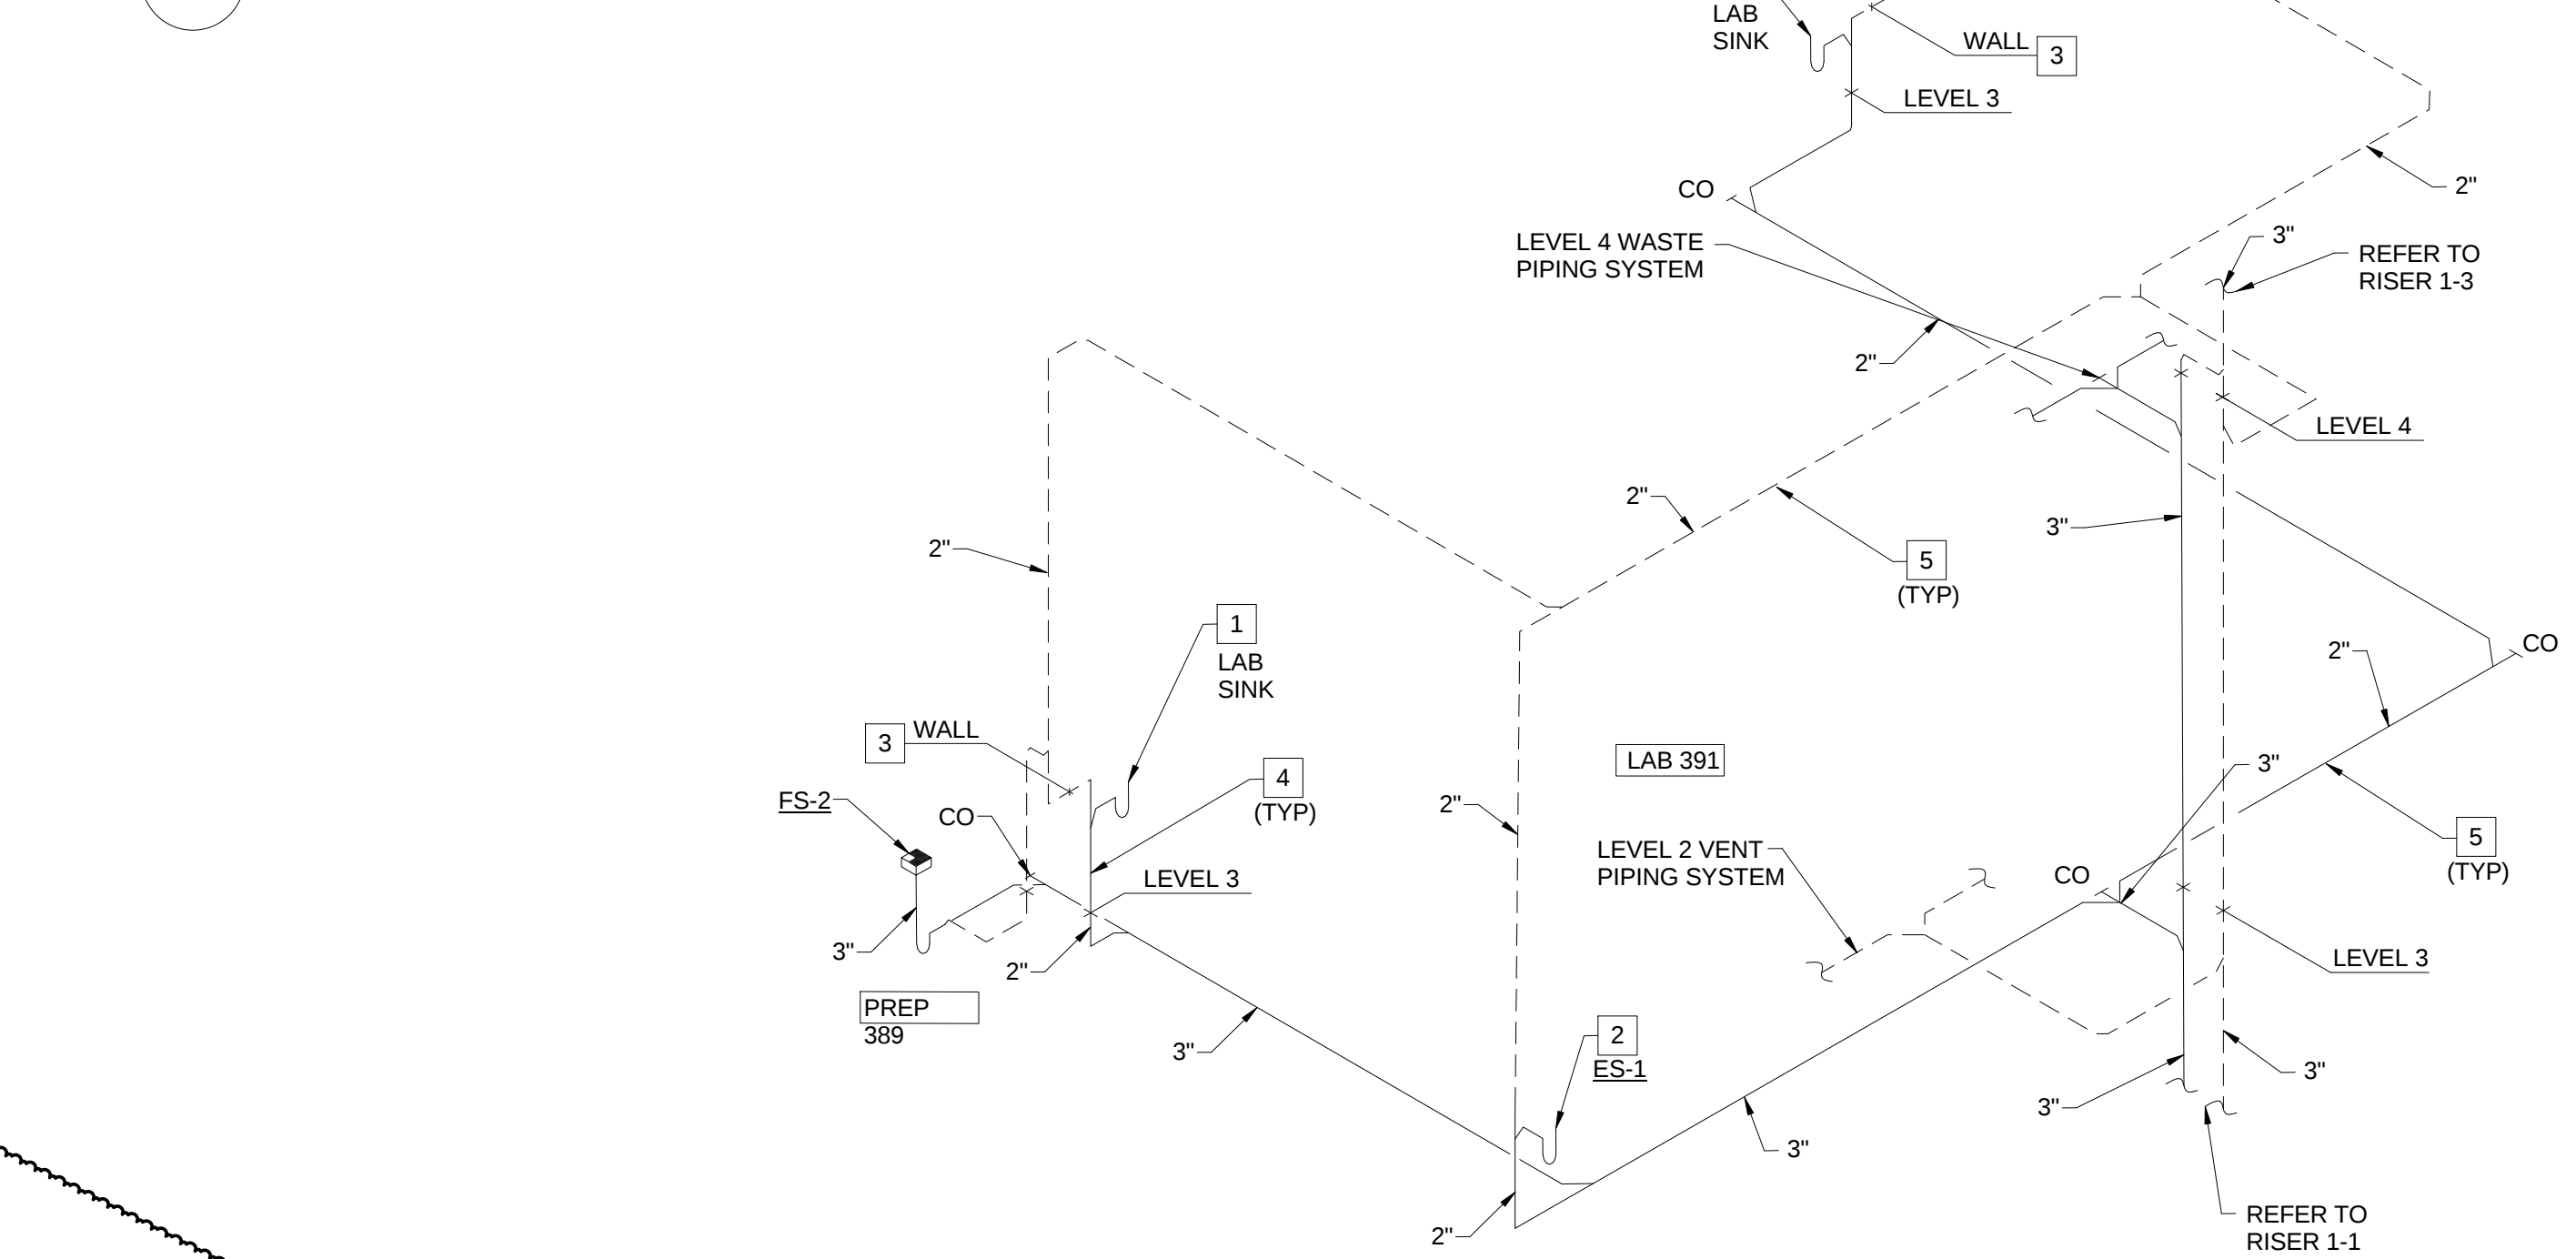

1-2 SANITARY WASTE AND VENT RISER - PREP 389 AND LAB 391

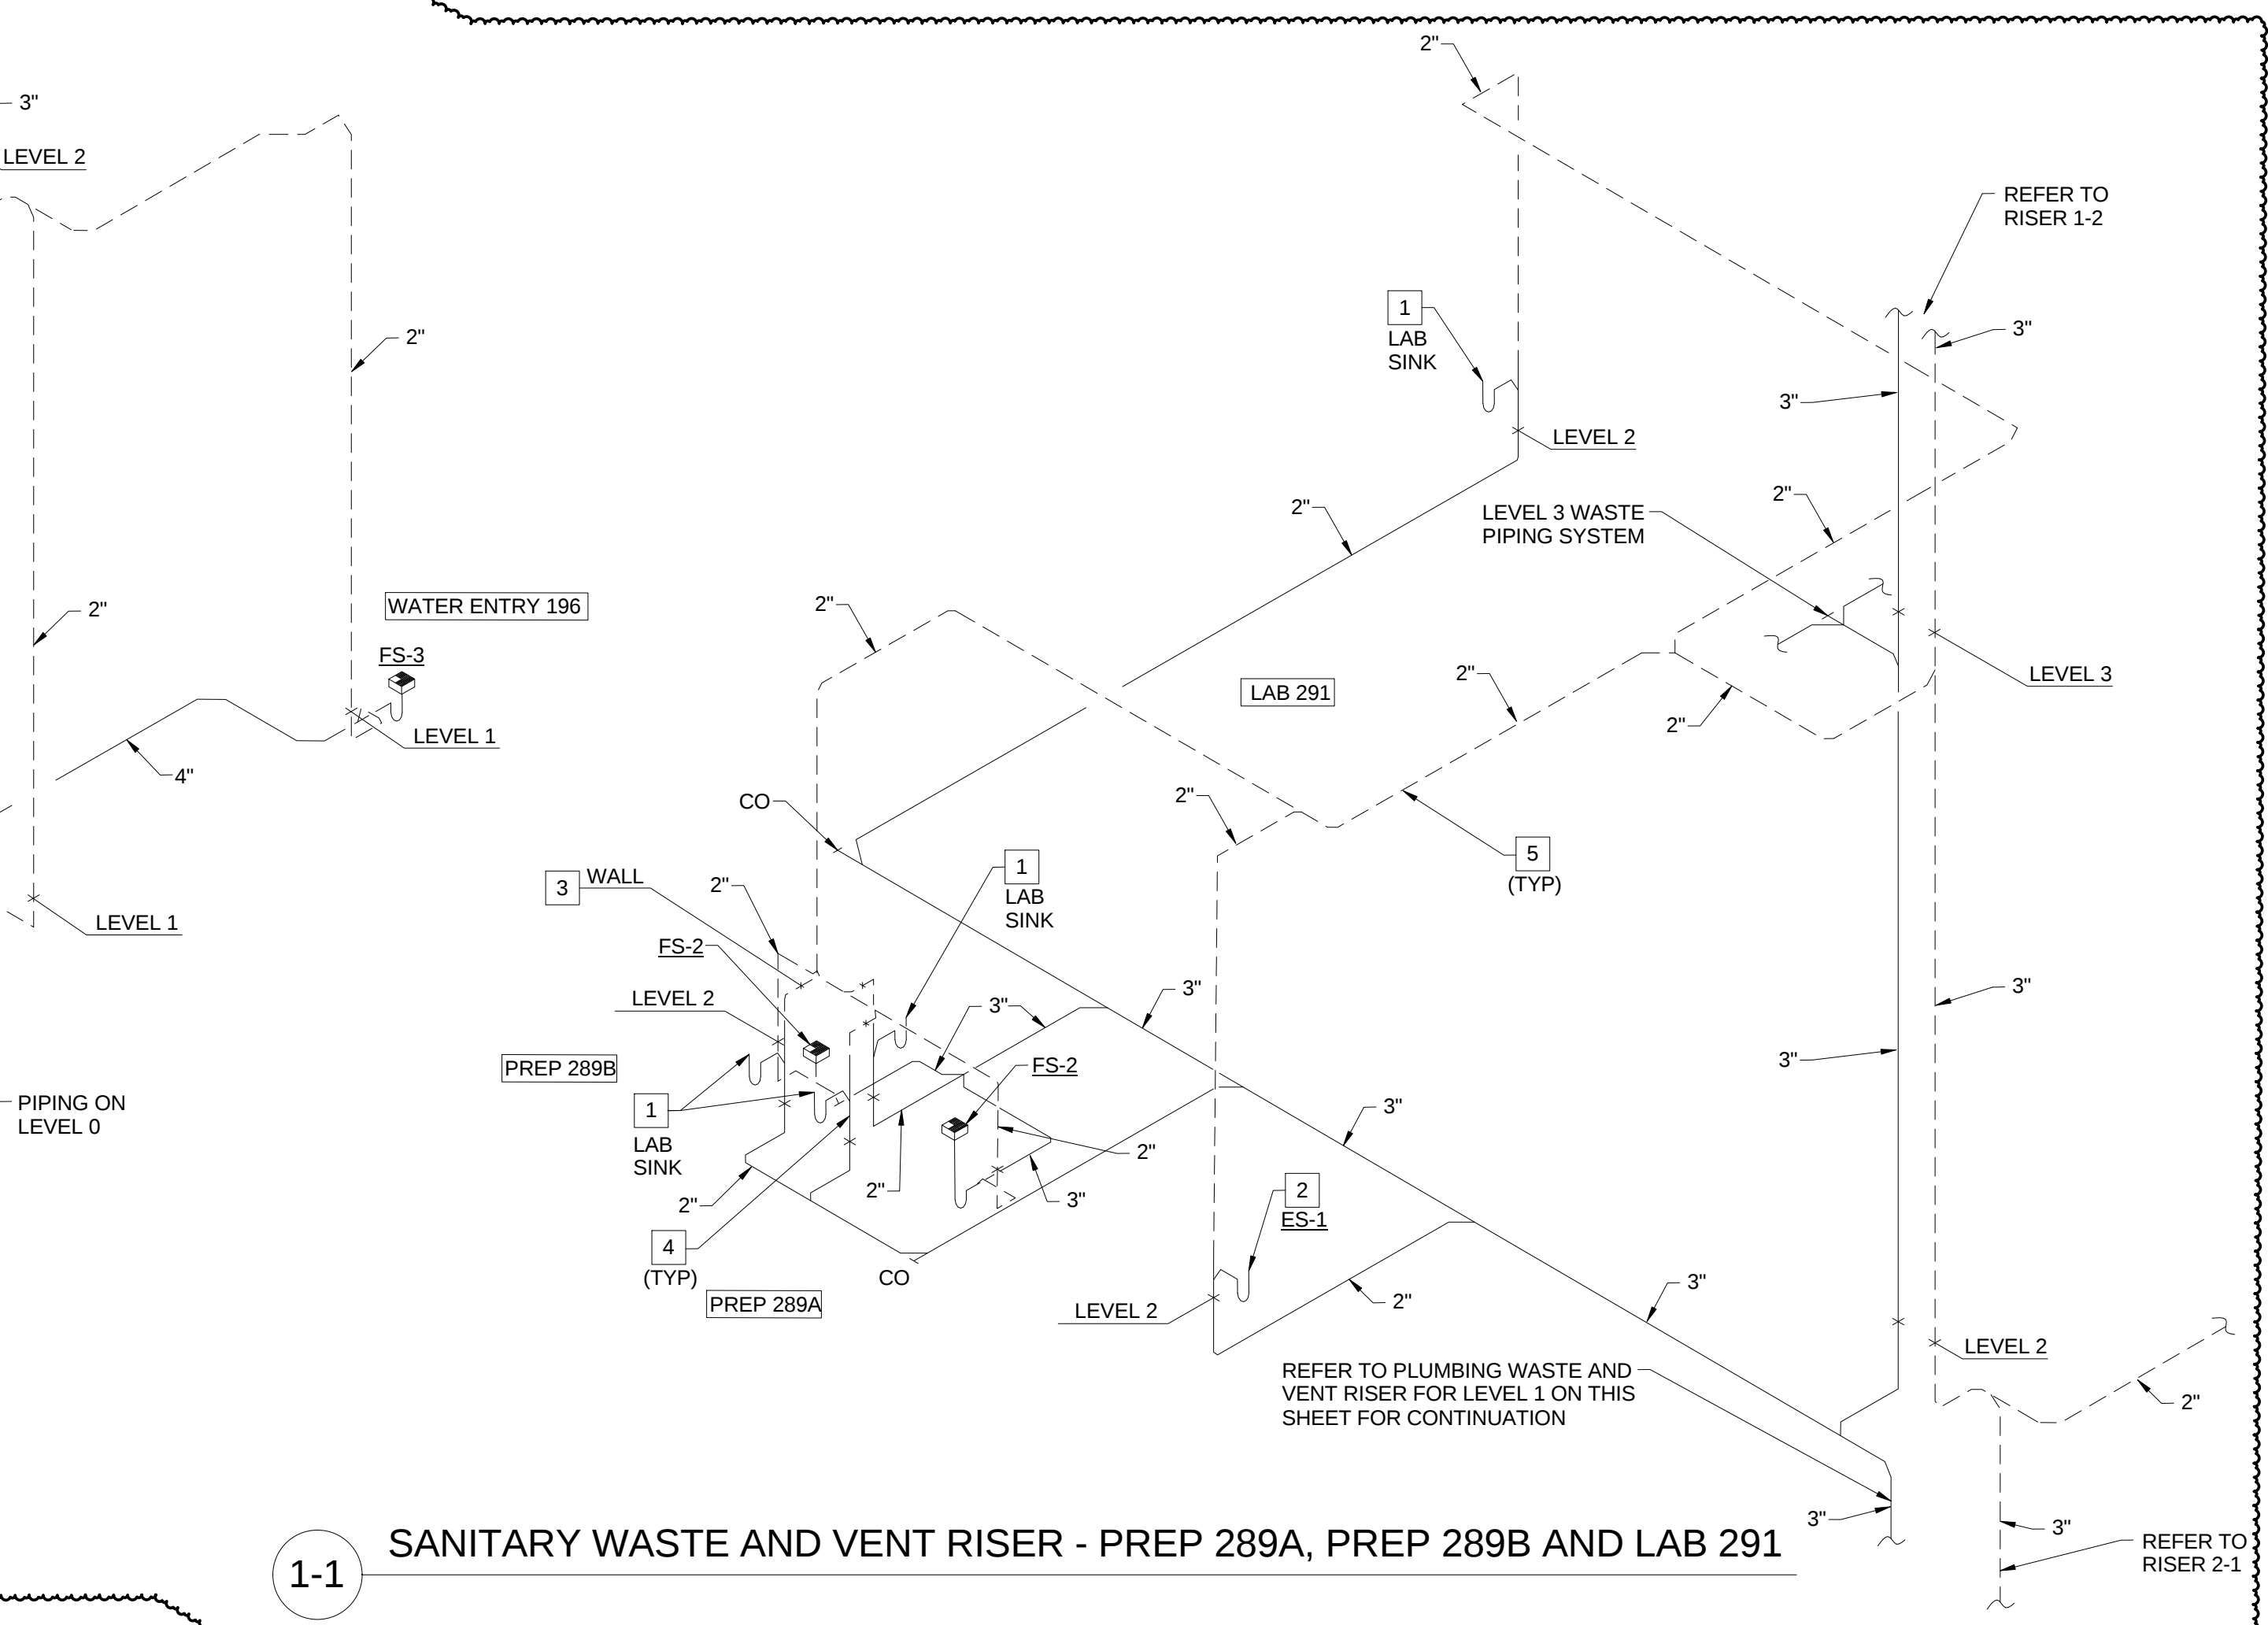

1-1 SANITARY WASTE AND VENT RISER - PREP 289A, PREP 289B AND LAB 291

PLUMBING WASTE AND VENT FOR PLUMBING RISER PR-1

SCALE: N.T.S.