



PARIC CORPORATION
77 Westport Plaza Suite 250
St. Louis, MO 63146
TEL: 636-561-9500
FAX: 636-561-9501

REQUEST FOR INFORMATION	DATE: October 27, 2016	NO.: RFI-337
--------------------------------	-------------------------------	---------------------

To: Cannon Design

Attn: Kelvin Patel

From: Paric Corporation

Requested By: Devin Gates

Project Name:	15051-Webster University Interdisciplinary Science Building	Project No.: 15051
---------------	---	--------------------

Subject: Room 407 floor box clarification

Response Required By: November 03, 2016

Drawing / Spec Reference:

Information Requested:

RFI 162 showed 2 floor boxes in room 407, this was never included in any electrical drawing change. Please confirm we are to follow RFI 162.

Response:

Provide two floor boxes as called for in RFI-162. See attached drawing update.

ARCHITECT'S RESPONSE:

This information is provided as an interpretation of the Contract Documents for implementation. It is not an authorization for change to the Contract Sum or Contract Time. If this information results in a claim for a change to the Contract, the Contractor shall notify the [Construction Manager][Architect] of a change through the change process.

Answered By: Mark de la Fuente, WTA


Date: 10/28/16

© Cannon Design 2015
All rights reserved. No part of this document may be reproduced or transmitted in any form without written authorization by The Cannon Corporation.
10/28/2016 11:45:01 AM

1

LEVEL 04 - AREA B - FLOOR PLAN - POWER AND AUXILLARY

1/8" = 1'-0"

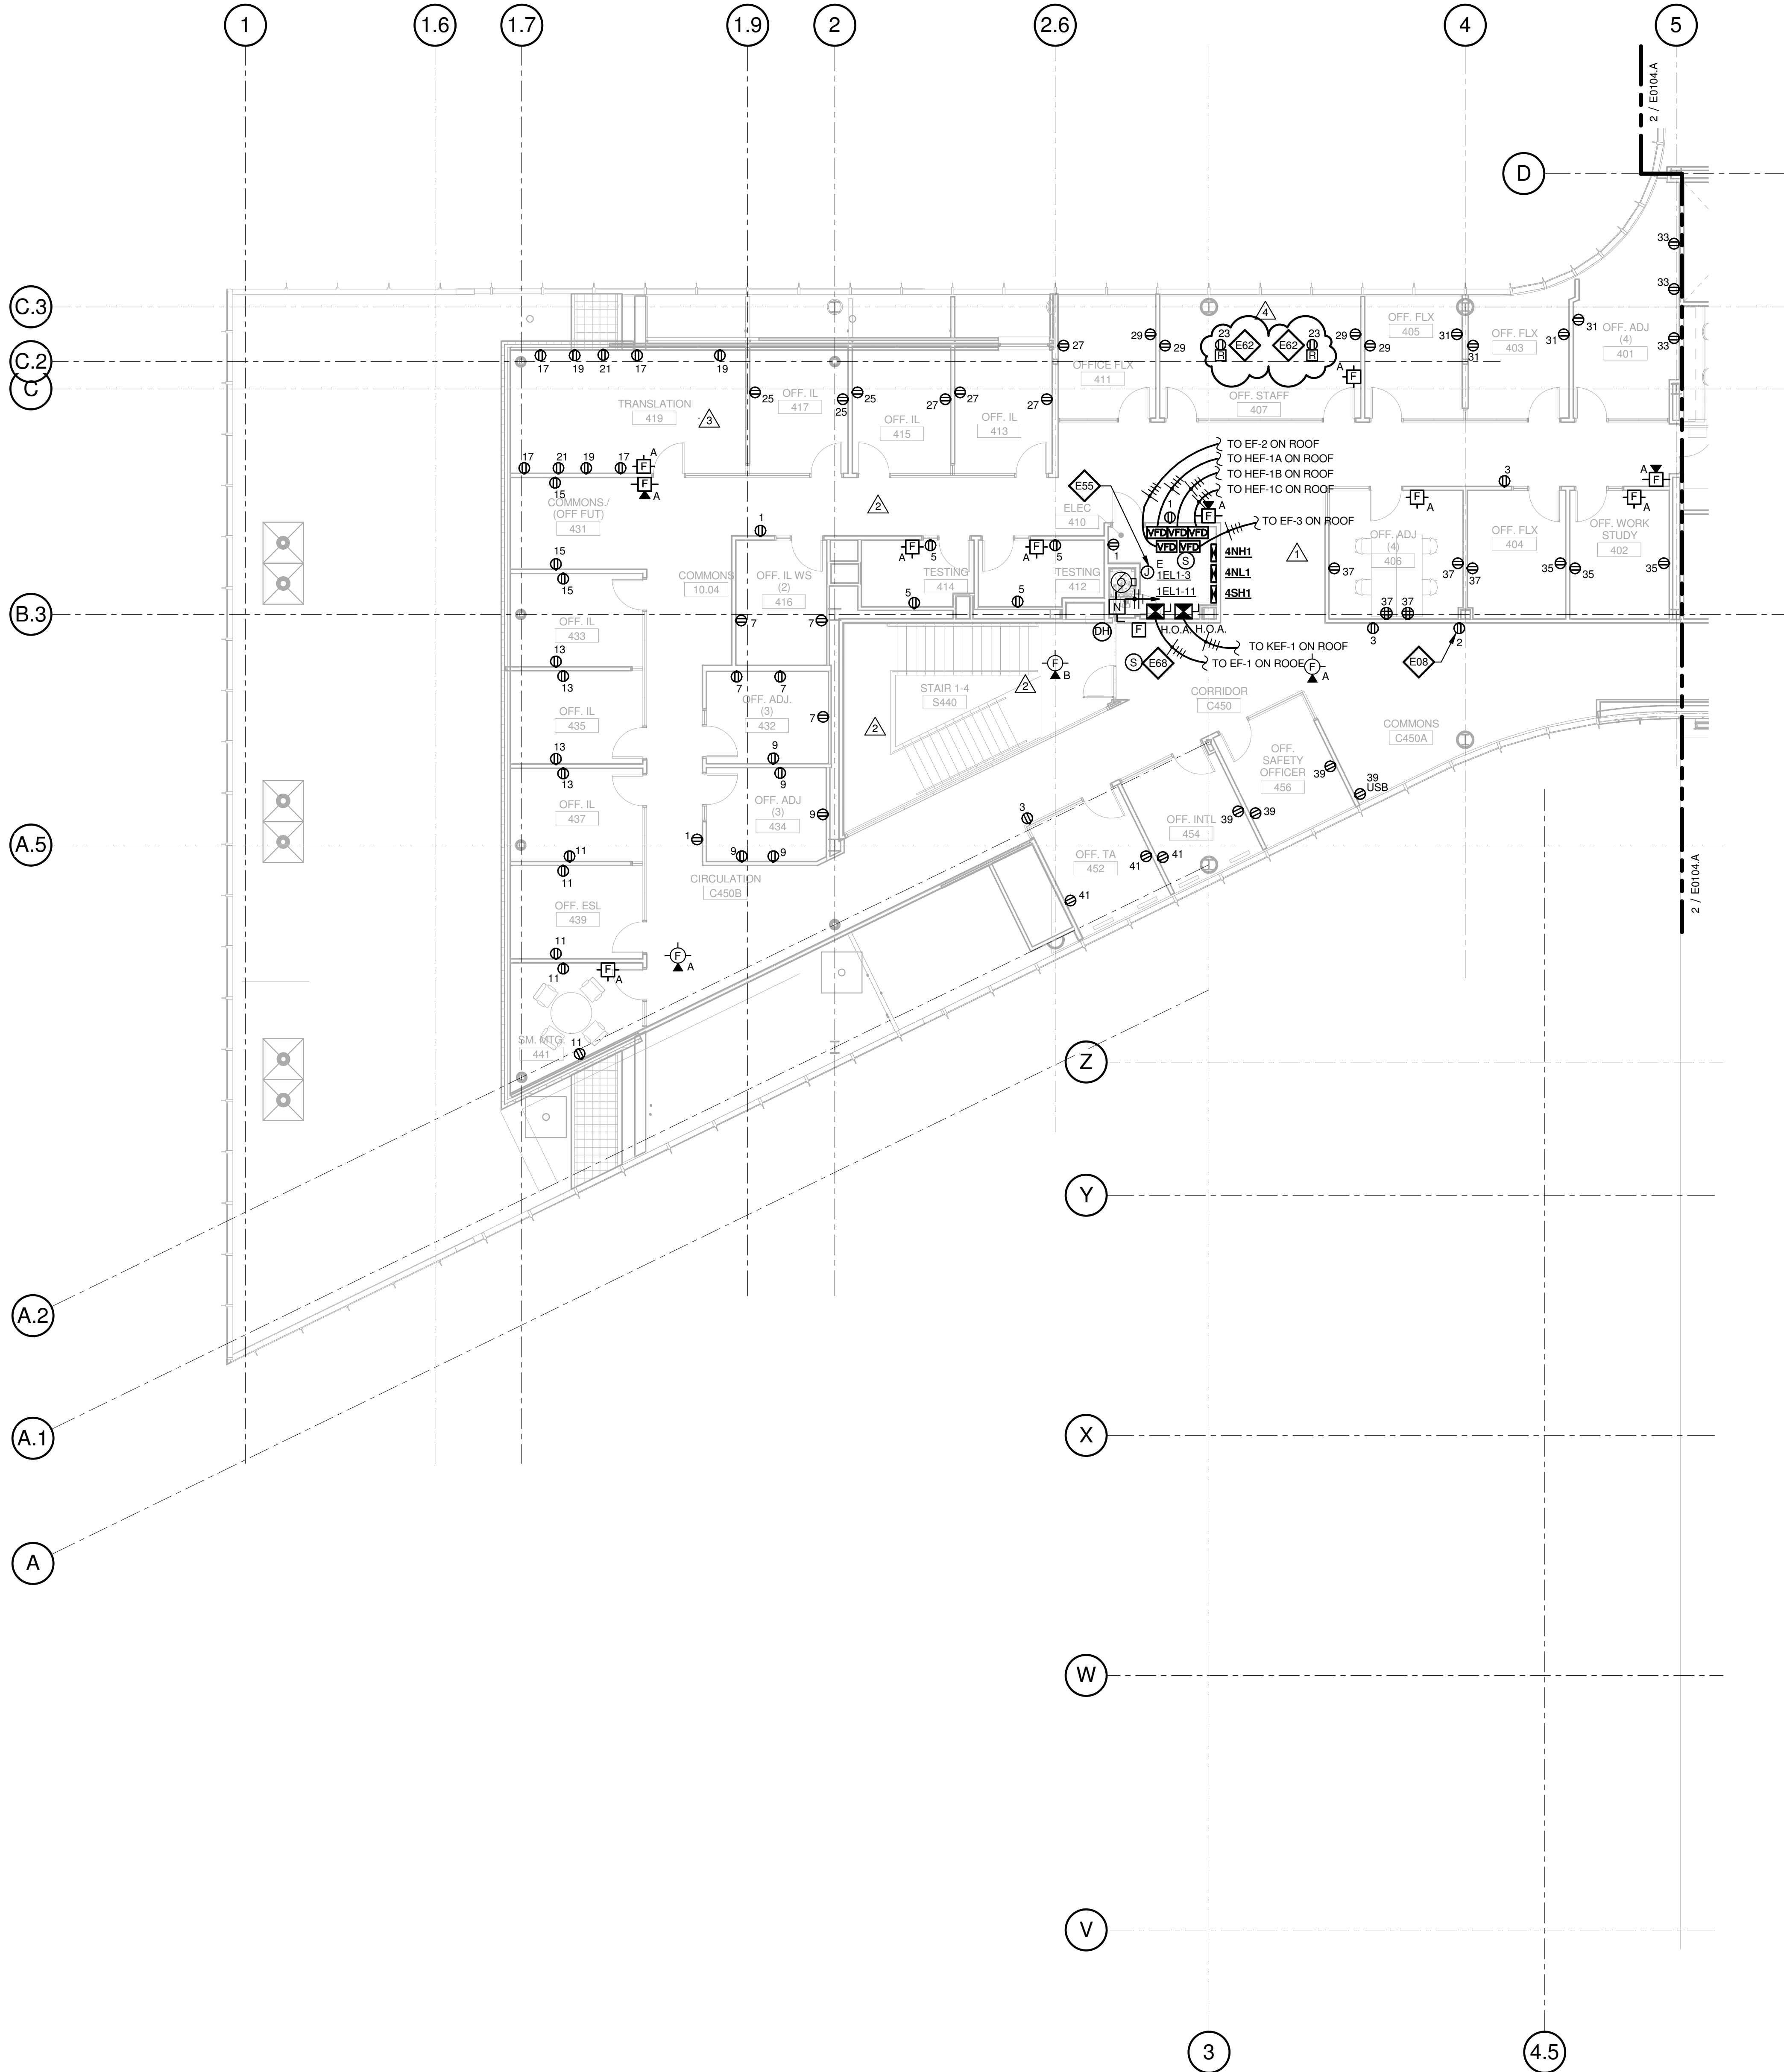

GENERAL NOTES:

- DO NOT SCALE DRAWINGS. REFER TO ARCHITECTURAL PLANS AND ELEVATIONS FOR LOCATION AND ORIENTATION OF DEVICES. WHERE LOCATIONS ARE NOT INDICATED ON ARCHITECTURAL DRAWINGS, COORDINATE LOCATION AND ORIENTATION OF DEVICES IN FIELD WITH ARCHITECT PRIOR TO ROUGH-IN.
- ALL DEVICES SHOWN ARE NEW UNLESS NOTED OTHERWISE.
- ALL DEVICES TO REMAIN ARE INDICATED WITH A THIN SOLID LINE WEIGHT AND SUBSCRIPT "EX".
- CONTRACTOR SHALL VISIT PRIOR TO BID SUBMITTALS TO DETERMINE SITE CONDITIONS EFFECTING THE EXECUTION OF WORK. FAILURE TO BE ACQUAINTED WITH EXISTING CONDITIONS WILL NOT BE JUSTIFICATION FOR ADDITIONAL SERVICES.
- PROVIDE FACE PLATES ON ALL J-BOXES ABANDONED IN FINISHED FLOOR, WALL OR CEILINGS. COORDINATE COLOR AND FINISH WITH ARCHITECT. CONTRACTOR TO VERIFY QUANTITY IN THE FIELD.
- WHERE EXPOSED CONDUIT IS NOTED, CONTRACTOR SHALL IDENTIFY ROUTING IN FIELD AND OBTAIN ARCHITECT'S APPROVAL OF ROUTING PRIOR TO ROUGH-IN. EXPOSED CONDUIT SHALL BE ROUTED TIGHT TO STRUCTURE.
- ALL SINGLE PHASE BRANCH CIRCUITS SHOWN SHALL HAVE DEDICATED NEUTRALS TO MEET NEC SECTION 210.4 MULTI-WIRE BRANCH CIRCUIT REQUIREMENTS.
- REFER TO TECHNOLOGY DRAWINGS FOR CONDUIT ROUGH-IN OF DATA, VOICE AND A/V.

- ALL 120V BRANCH CIRCUITS ON THIS SHEET SHALL BE FED FROM PANEL 4NL1 UNLESS NOTED OTHERWISE.

KEYED NOTES

- E06** OUTLET SHALL BE MOUNTED TO THE BACK SIDE OF THE TELECOMMUNICATION RACK AND FED FROM ABOVE. COORDINATE EXACT MOUNTING HEIGHT AND LOCATION WITH TELECOMMUNICATIONS CONTRACTOR PRIOR TO INSTALLATION.
- E08** OUTLET FOR DIGITAL SIGNAGE. COORDINATE MOUNTING HEIGHT AND EXACT LOCATION WITH ARCHITECTURAL ELEVATIONS AND A/V DRAWINGS.
- E55** PROVIDE POWER TO BUILDING AUTOMATION SYSTEM PANEL. COORDINATE LOCATION WITH AUTOMATION CONTRACTOR.
- E62** PROVIDE A 2HR FIRE CLASSIFIED 2-GANG MULTI-SERVICE STEEL RECESSED FLOOR BOX EQUAL TO WIREMOLD CAT. NO. RF82S-FC WITH A BRASS FLANGED COVER CAT. NO. FPBTGBS-NA. THE FLOOR BOX SHALL HAVE ALL NECESSARY MOUNTING BRACKET'S FOR (2) 20A STANDARD DUPLEX RECEPTACLES, NEMA 5-20R. THE BOX SHALL BE INSTALLED PER MANUFACTURERS WRITTEN INSTRUCTIONS SO THAT THE COVER IS FLUSH WITH THE FLOOR.
- E68** PROVIDE FIRE ALARM CONTROL MODULE TO RELEASE POWER TO ELECTRICALLY HELD OPEN FIRE DOOR UPON ACTIVATION OF ASSOCIATED SMOKE DETECTOR.

THE SEALS(S) AND SIGNATURE(S) APPLY ONLY TO THE DOCUMENT TO WHICH THEY ARE AFFIXED, AND EXPRESSLY DISCLAIM ANY RESPONSIBILITY FOR ALL OTHER PLANS, SPECIFICATIONS, ESTIMATES, REPORTS OR OTHER DOCUMENTS OR INSTRUMENTS RELATING TO OR INTENDED TO BE USED FOR ANY PART OR PARTS OF THE ARCHITECTURAL OR ENGINEERING PROJECT.

Webster
UNIVERSITY

Webster University
Interdisciplinary Science
Building

CANNONDESIGN

1100 Clark Avenue
St. Louis, Missouri 63102
T: 314.241.6250
F: 314.241.2570

William Tao & Associates, Inc.
ME/PFP Engineer
7955 Manchester Road, Suite 125
St. Louis, MO 63143
314.884.7600

David Mason & Associates, Inc.
Structural & Civil Engineer
800 South Vandeventer Avenue
St. Louis, MO 63110
314.534.1053

Faith Group
Technology
3101 S. Hanley Rd, Suite 100
St. Louis, MO 63143
314.991.2229

Kuhmann Leavitt, Inc.
Environmental Graphics & Signage
7400 Pershing Ave.
St. Louis, MO 63130
314.725.6616

KWA Architects
Architecture
9721 Litzinger Road
St. Louis, MO 63124
314.962.2560


Spellman Brady & Company
Interior Designer
8251 Maryland Avenue, Suite 300
St. Louis, MO 63105
314.862.0070

SWT Design
Landscape Architect
7722 Big Bend Blvd
St. Louis, MO 63119
314.644.5700

Webb Engineering Services, Inc.
Plumbing & Fire Protection
1400 S. 3rd Street, Suite 201
St. Louis, MO 63104
314.568.0600

4	RFI-337	26 OCT 2016
3	ASH-030	14 OCT 2016
2	ADDENDUM 2-2	19 APRIL 2016
1	ADDENDUM 2-1	17 MAR 2016
-	ISSUED FOR CONSTRUCTION (BP2)	01 MAR 2016

No.	Description	Date
-----	-------------	------

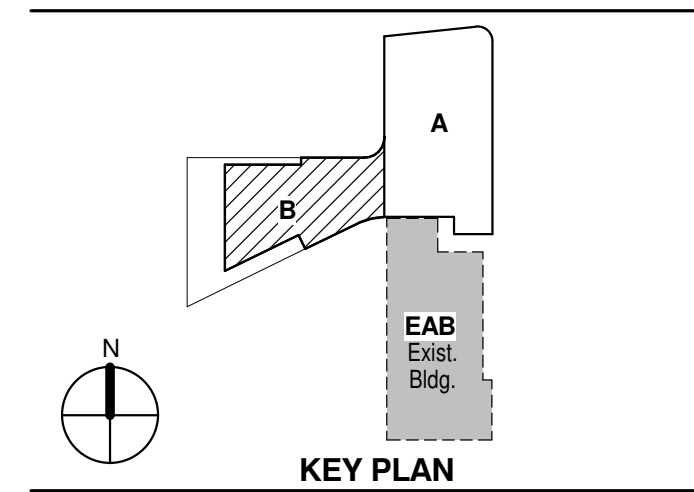

Drawing Title:

**LEVEL 04 AREA B FLOOR
PLAN - ELECTRICAL &
AUXILIARY**

Project No.: 04561.01 Checked by:

E0104.B

© Cannon Design 2015