


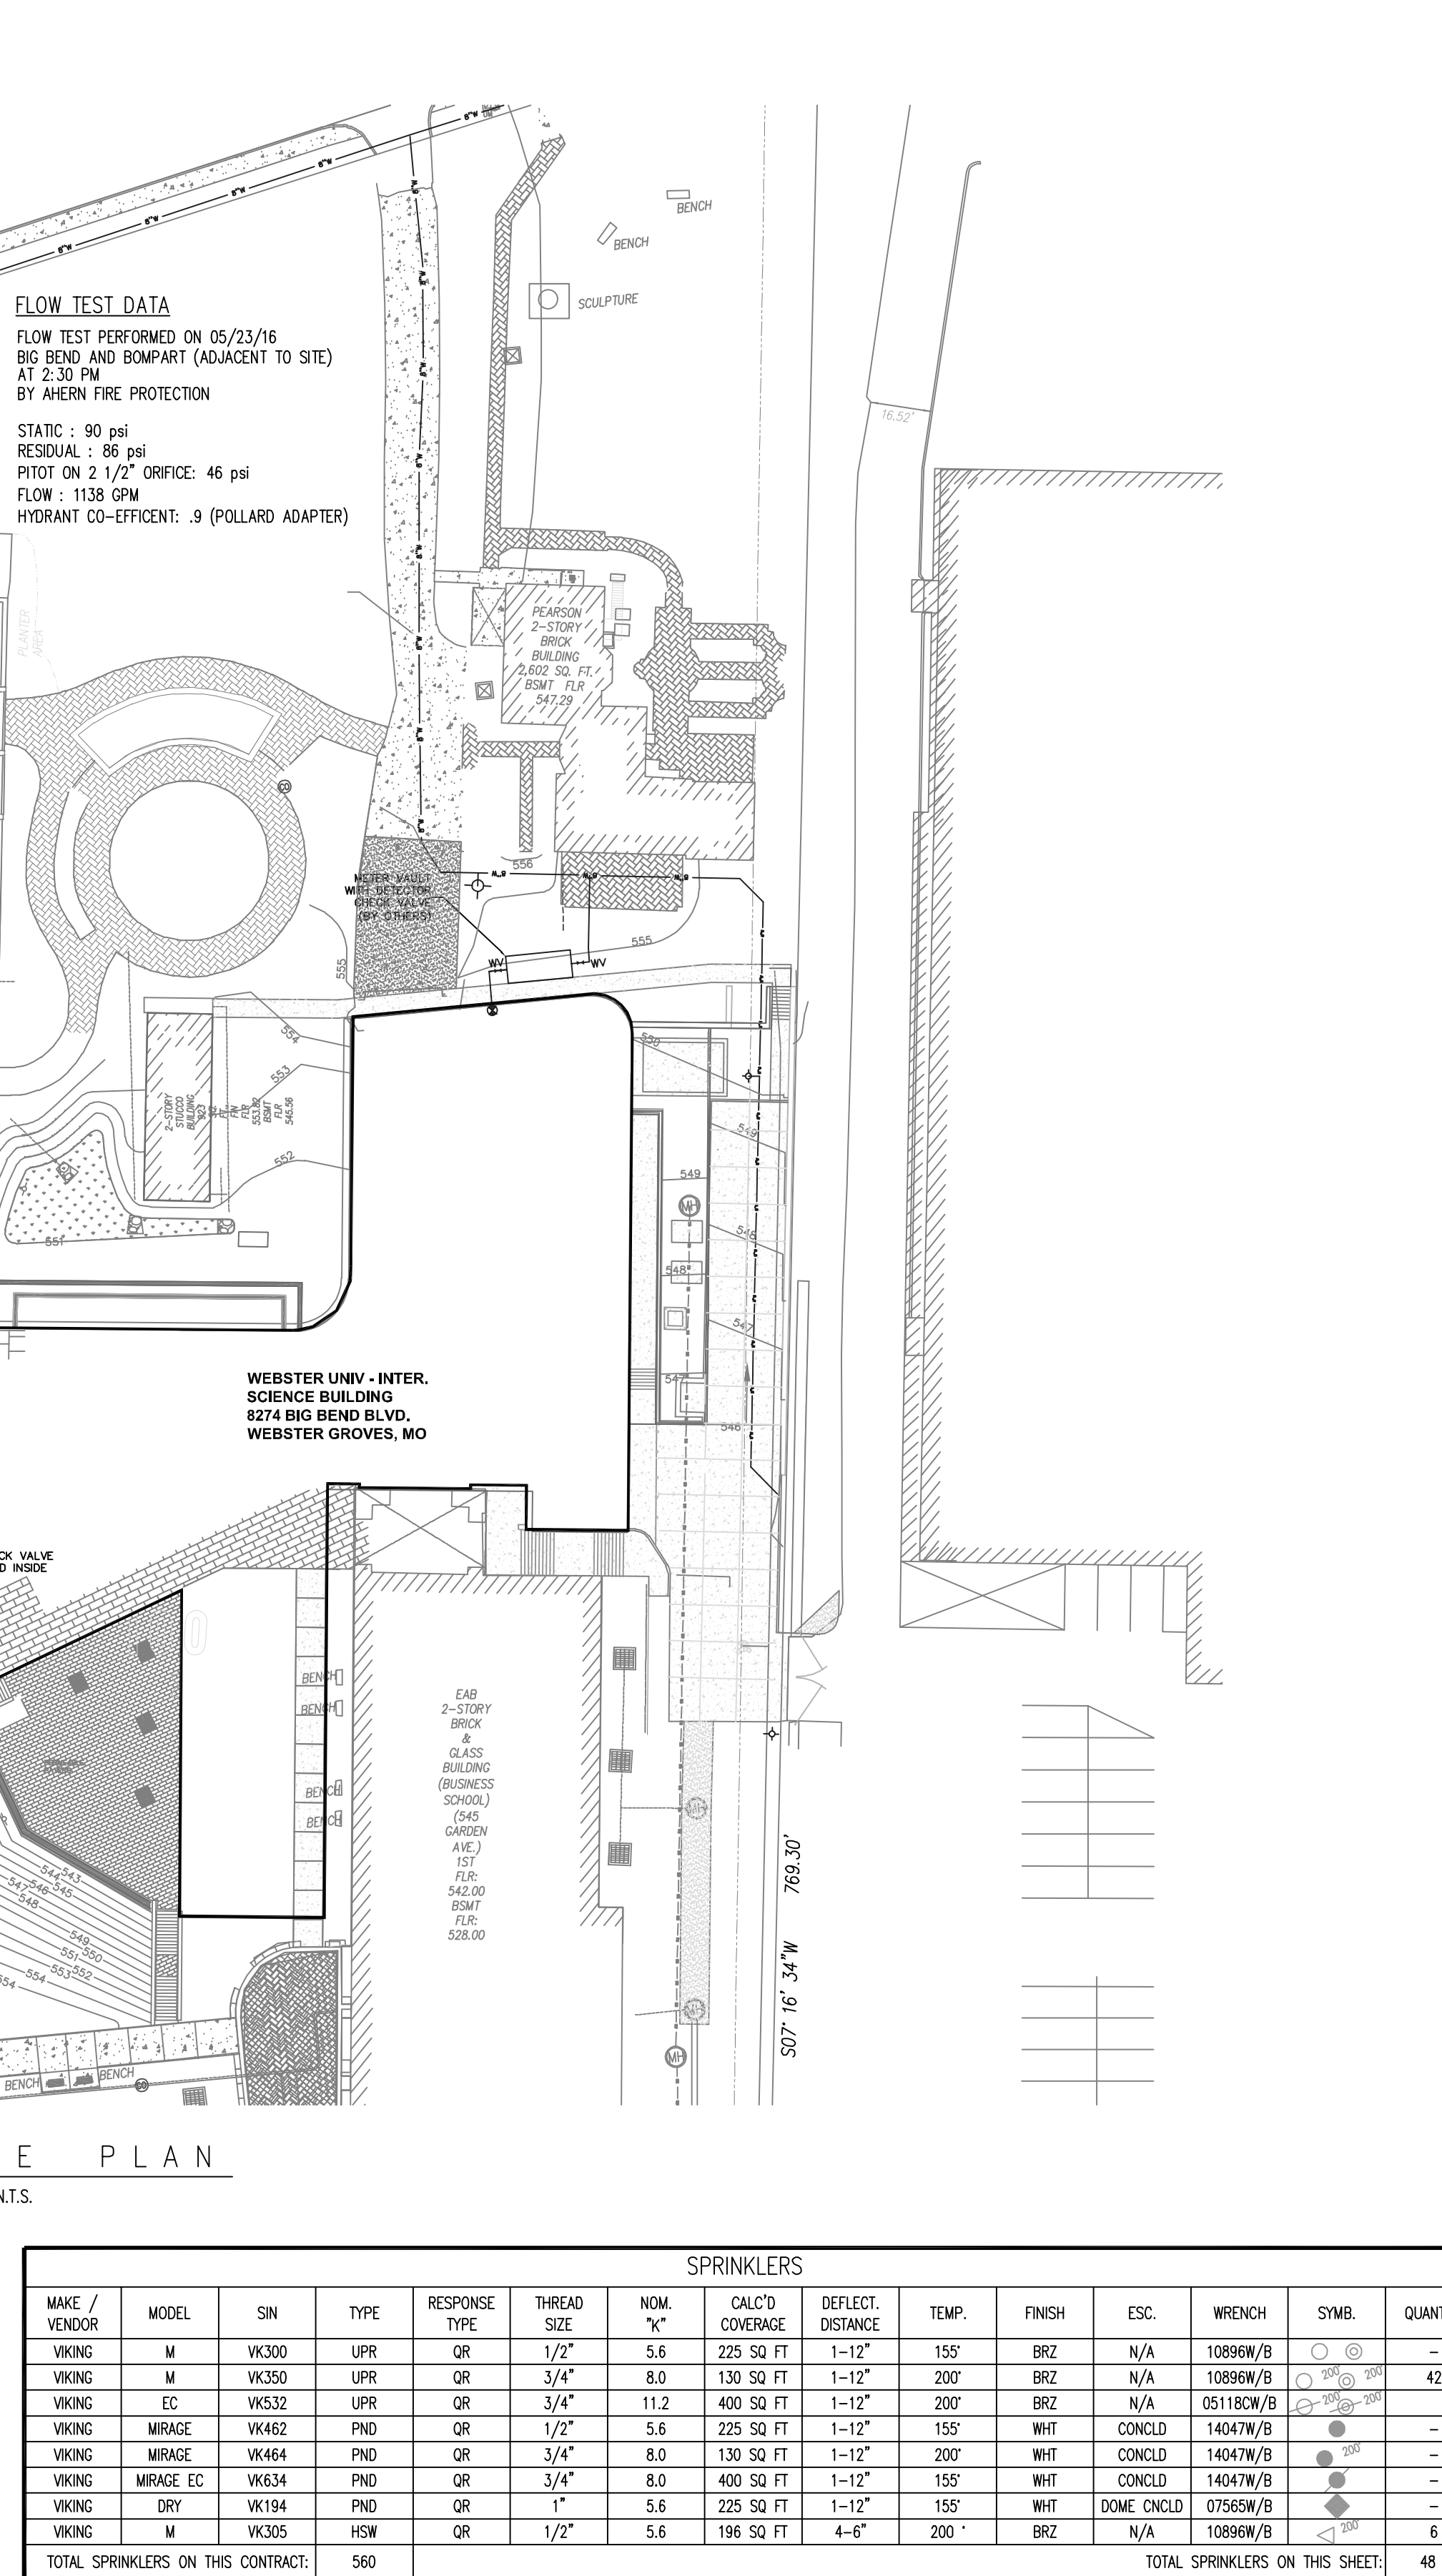
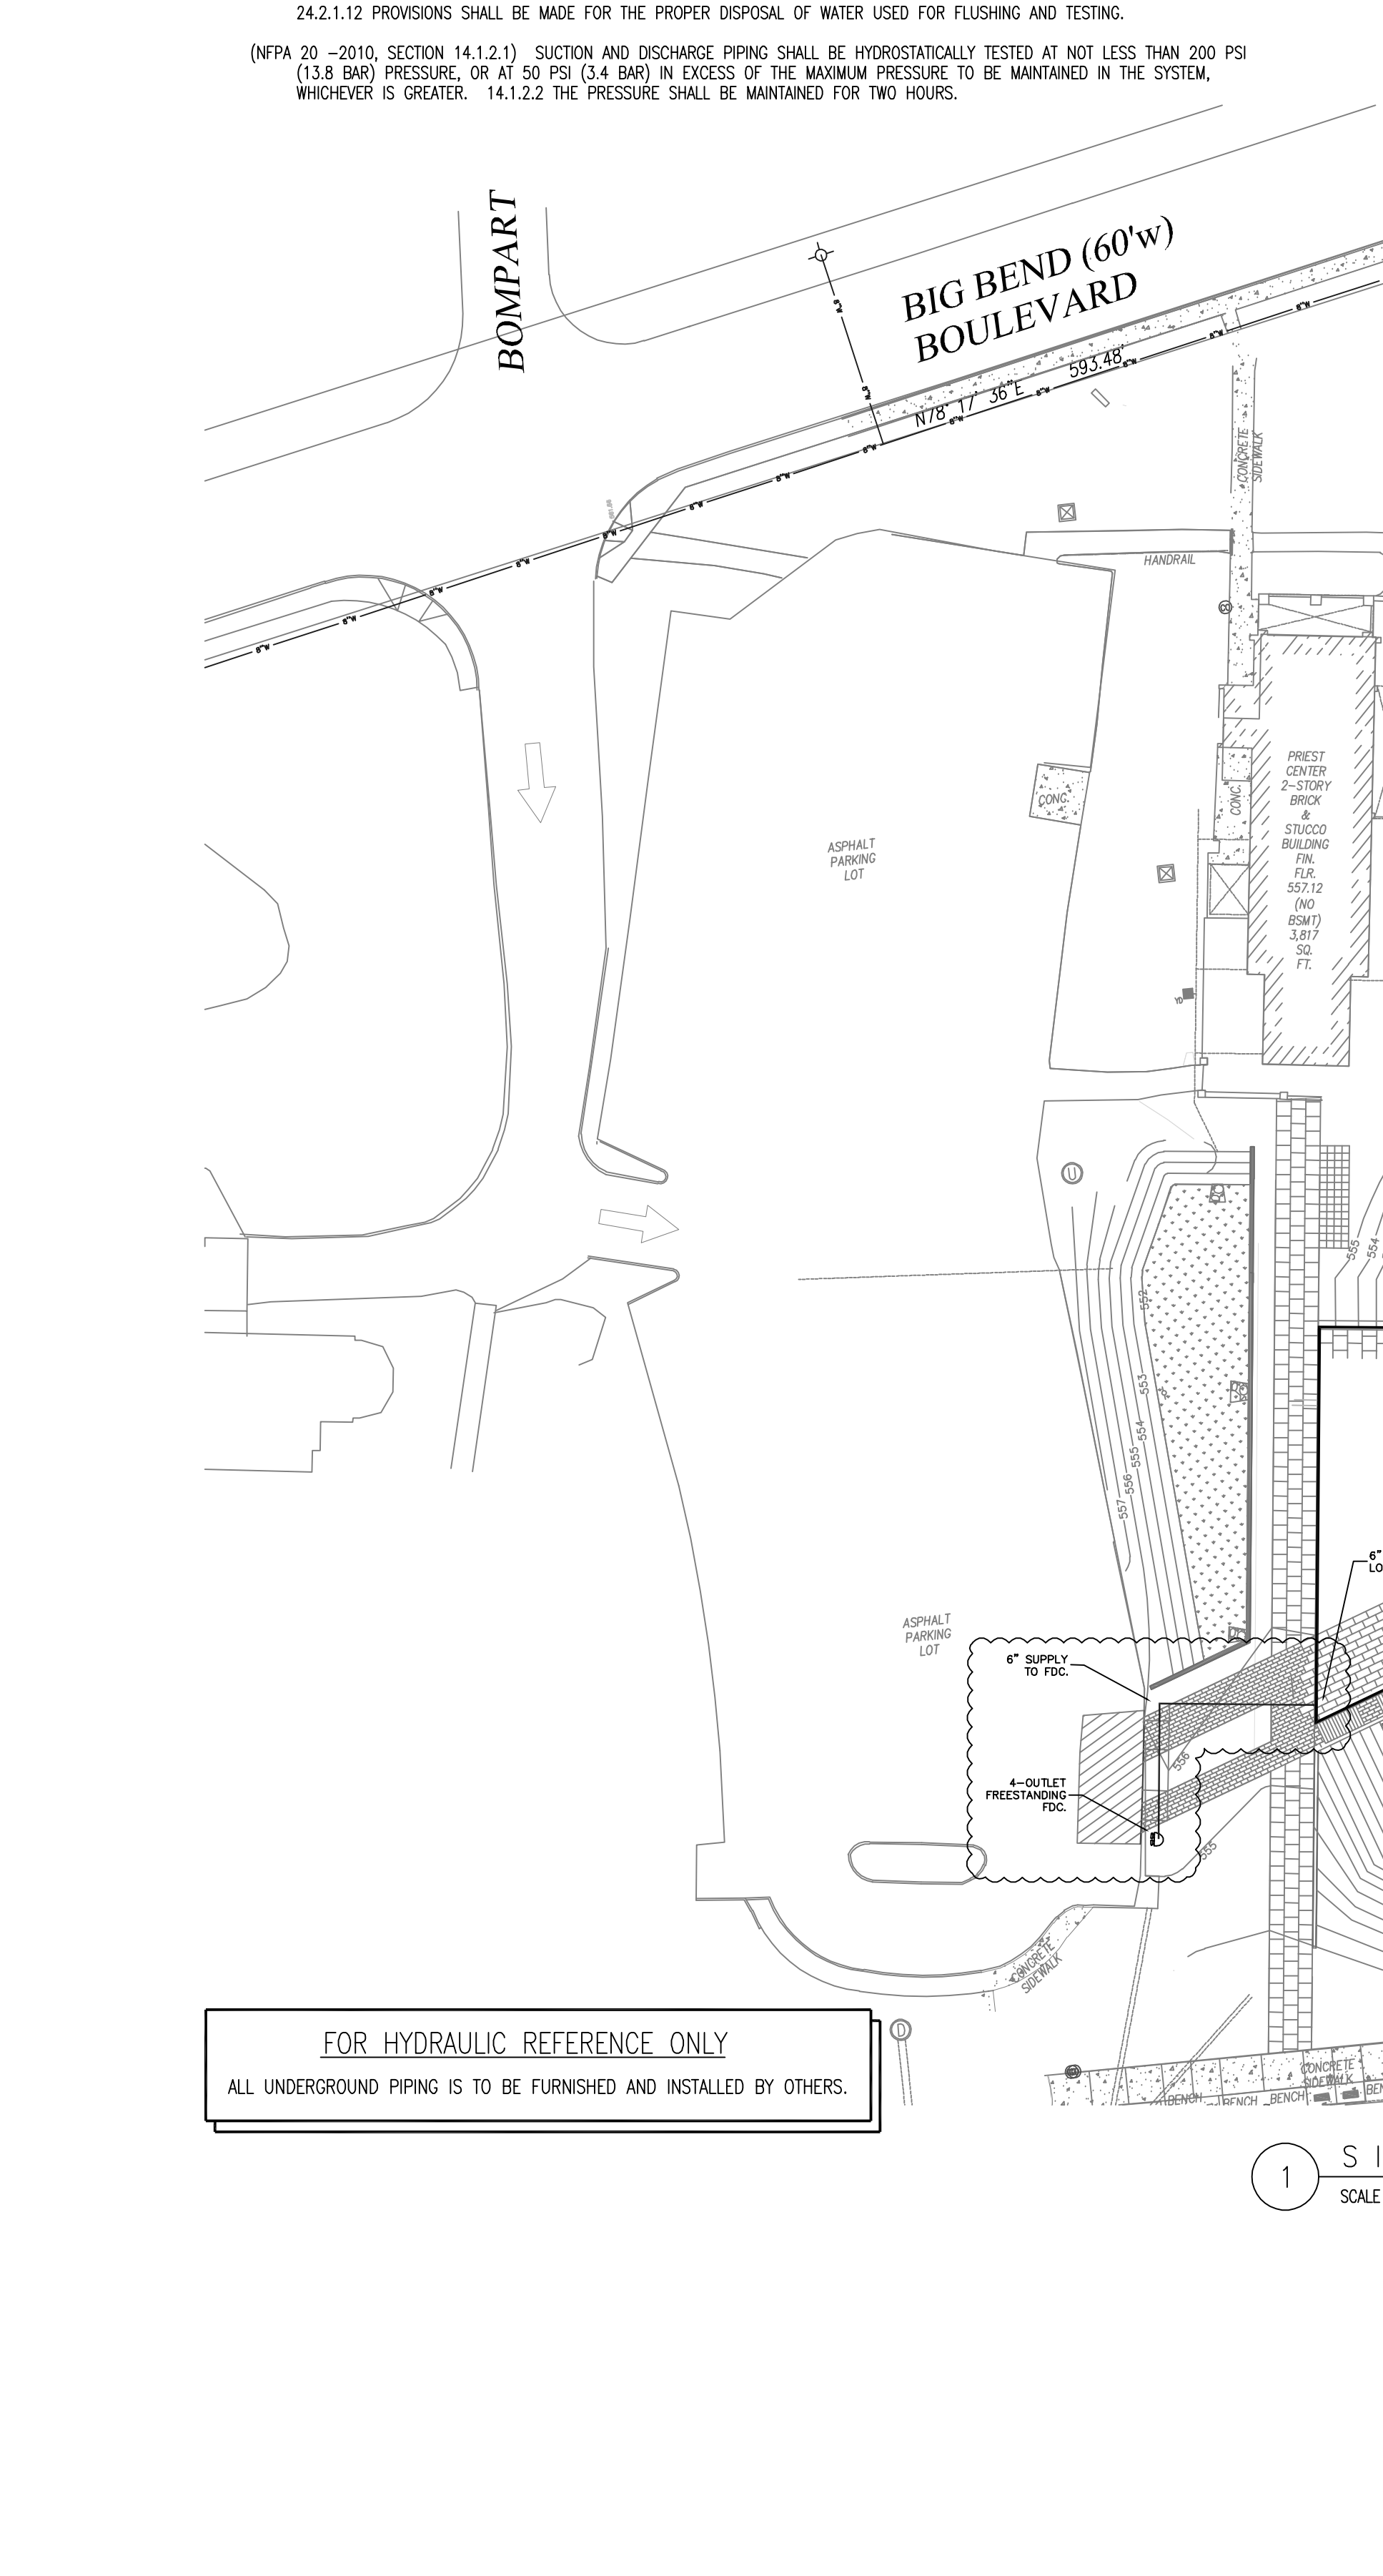
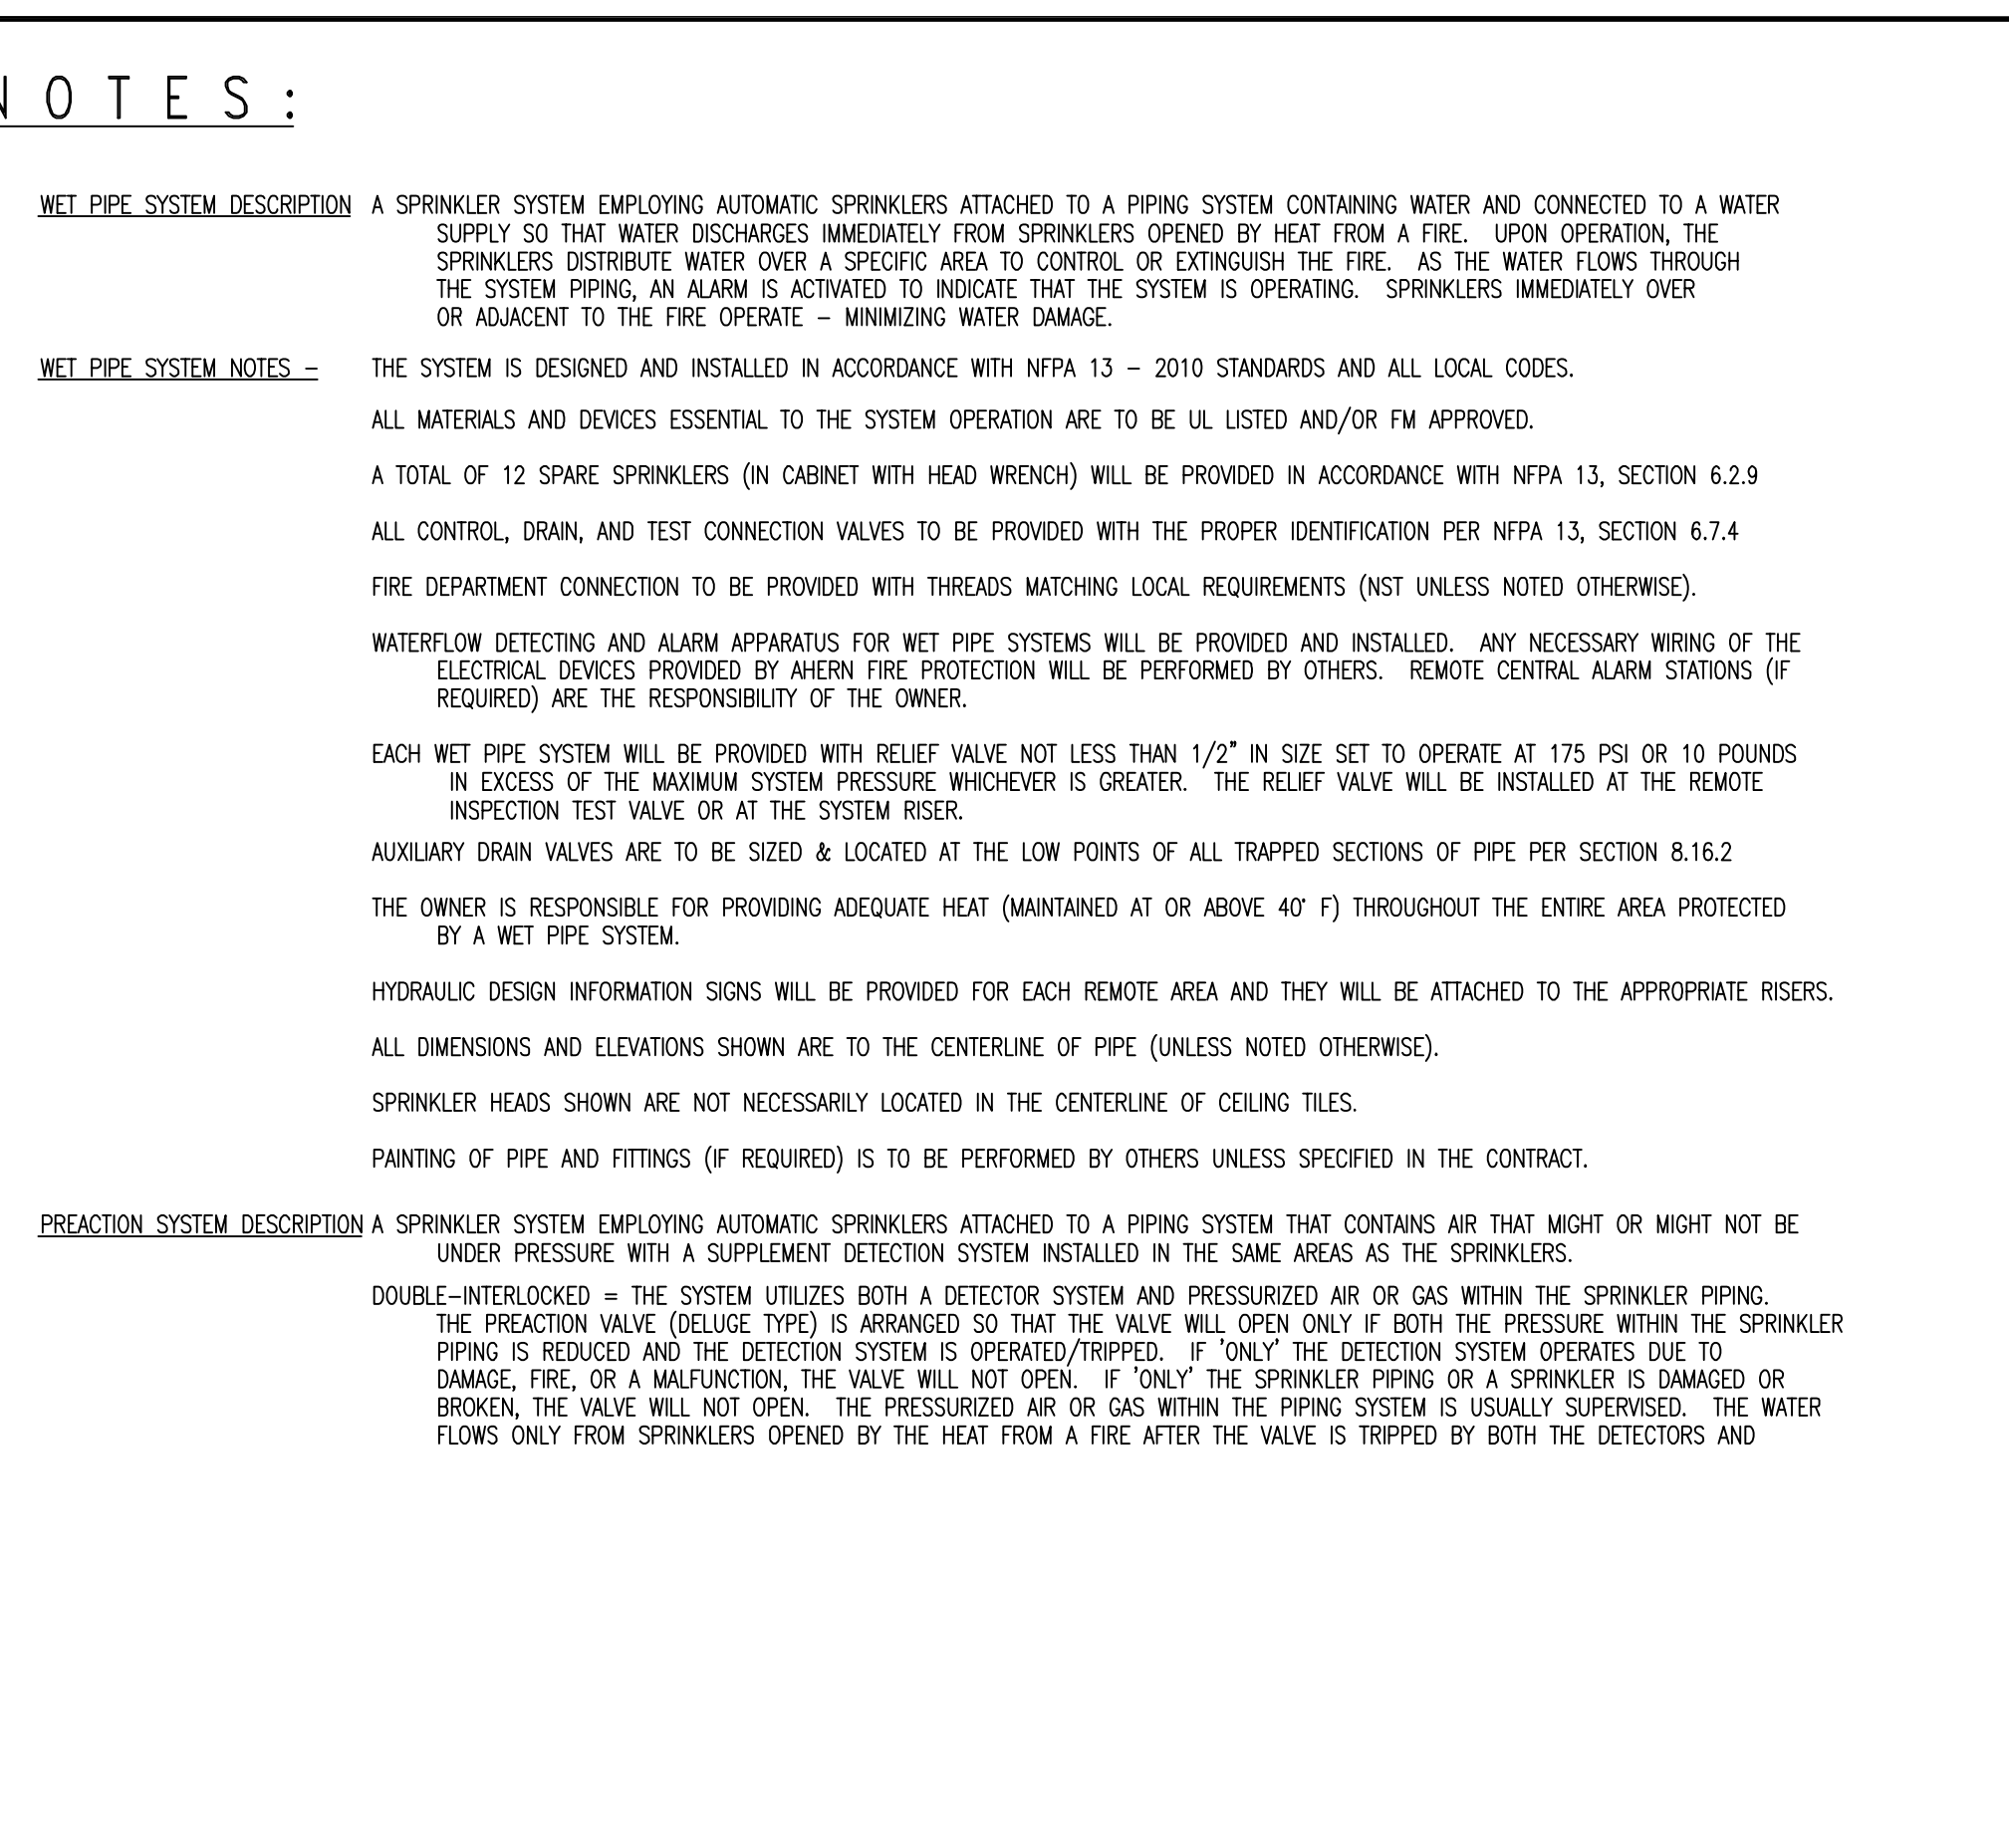
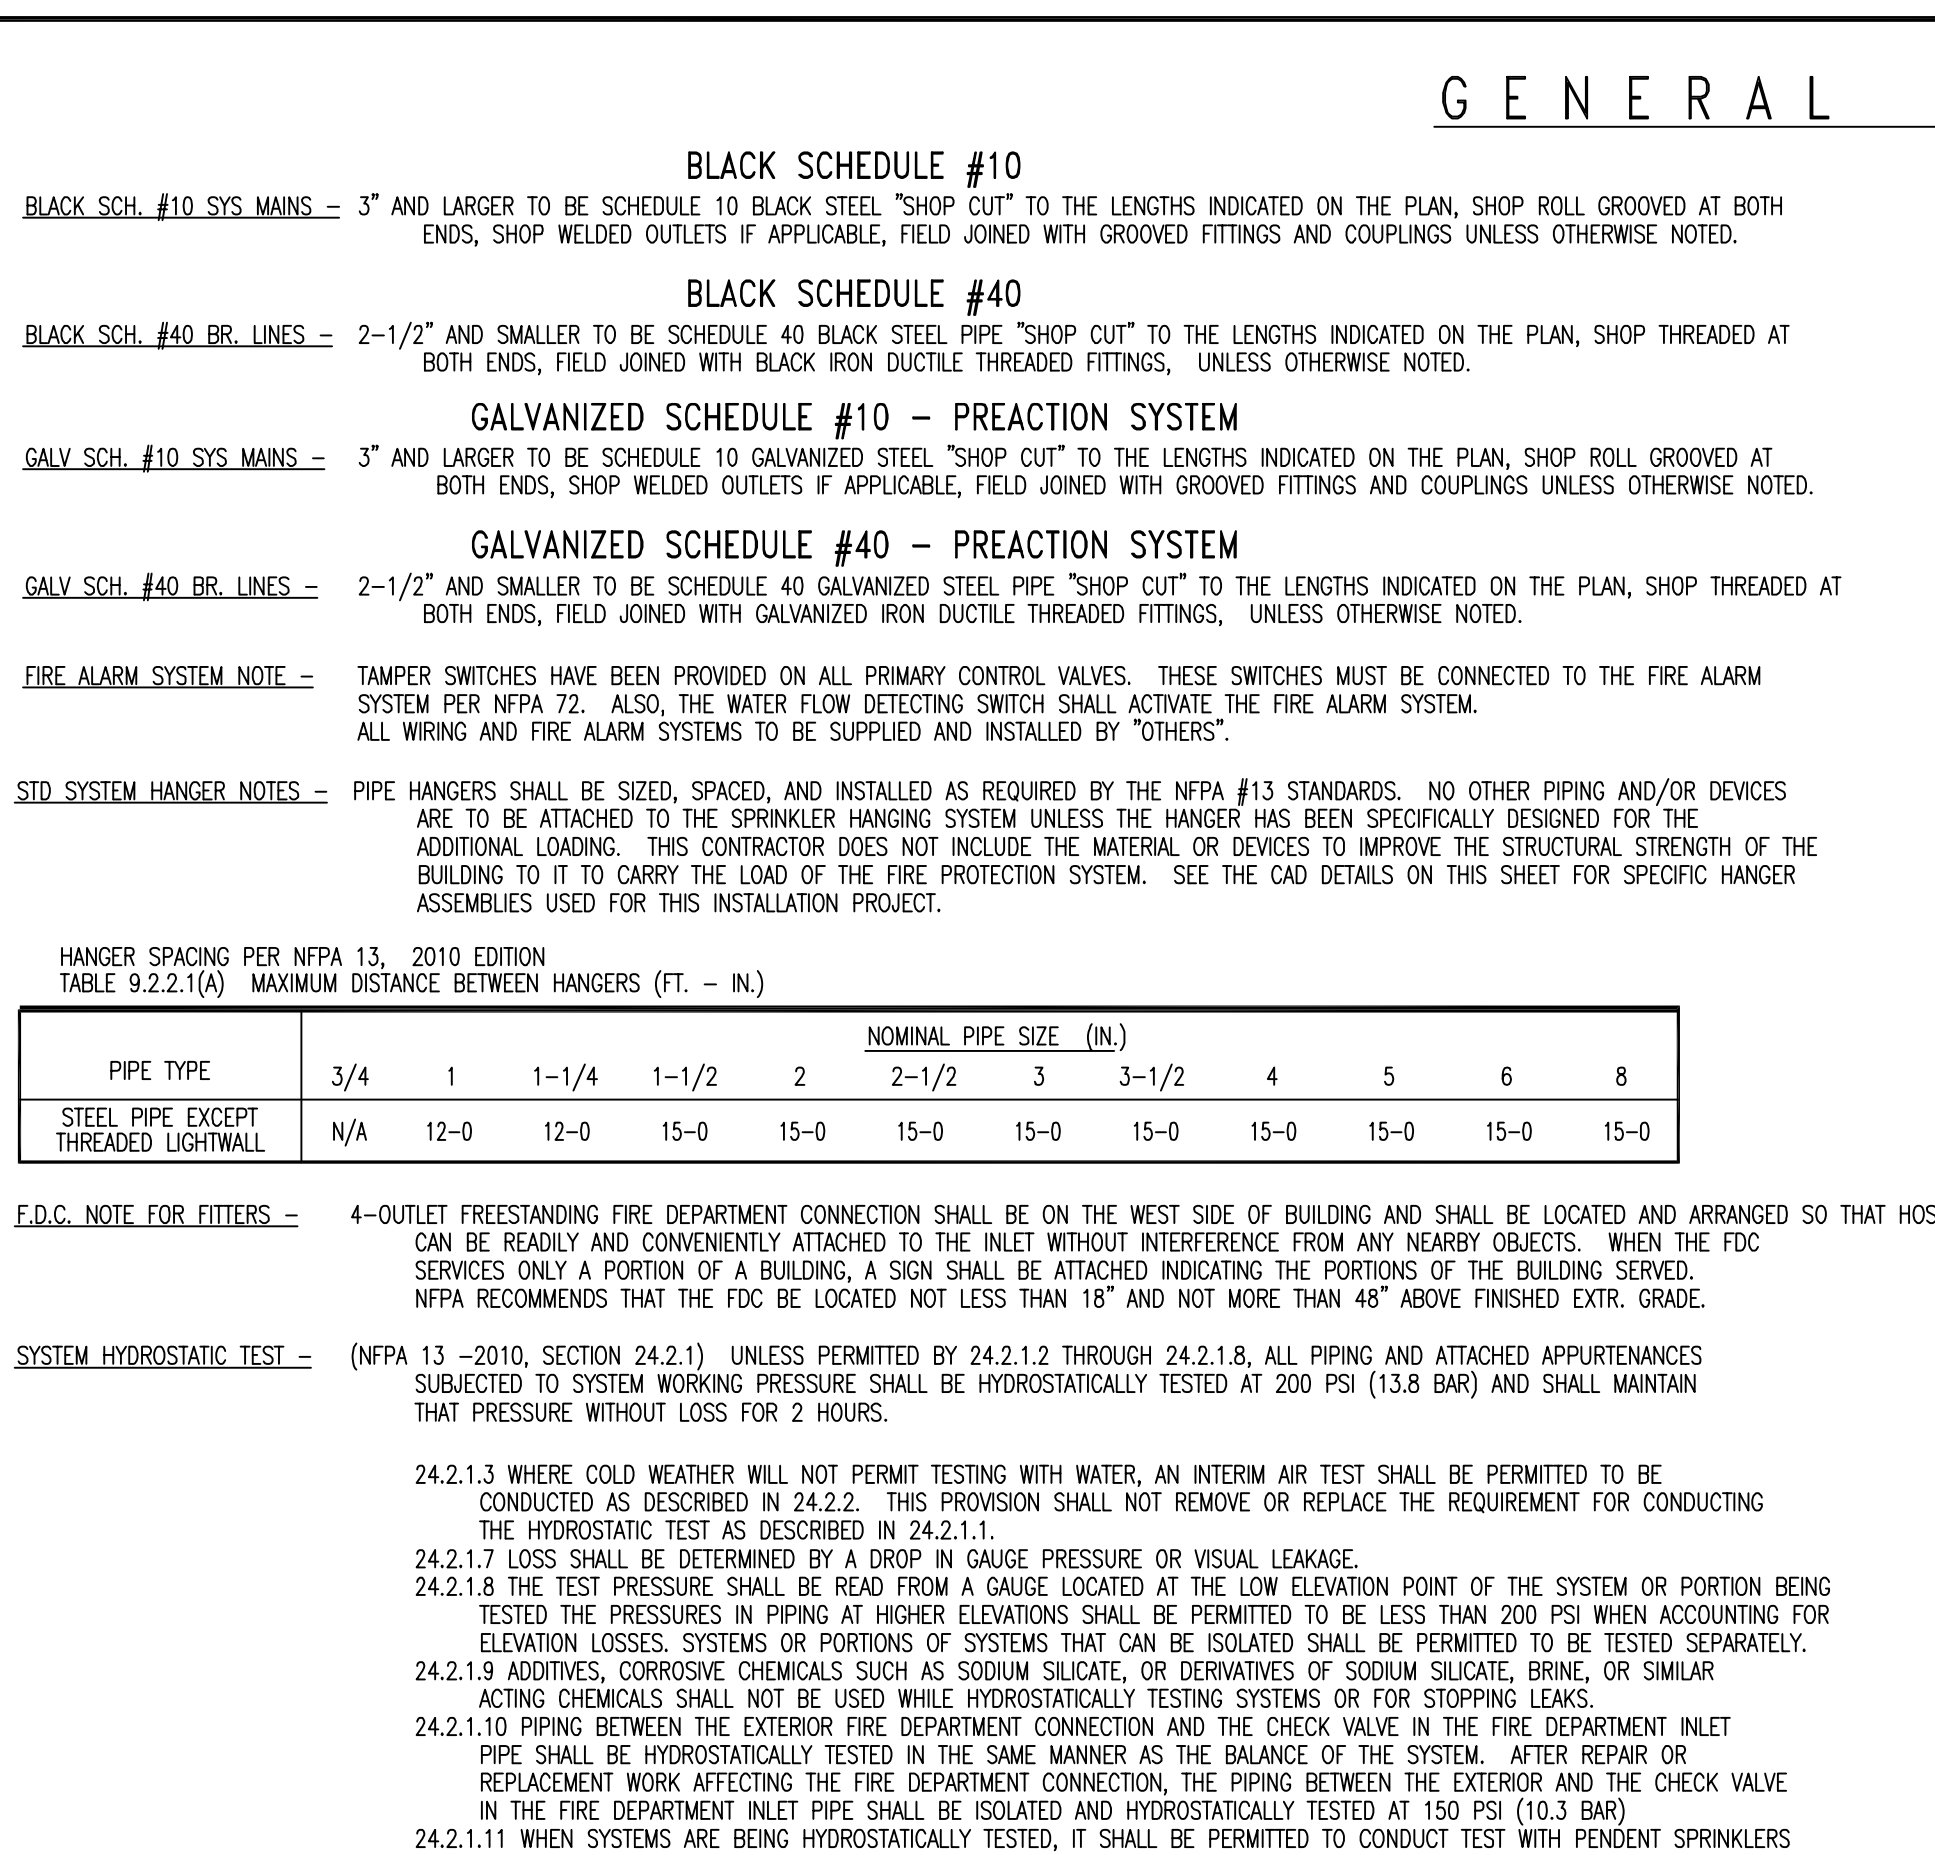
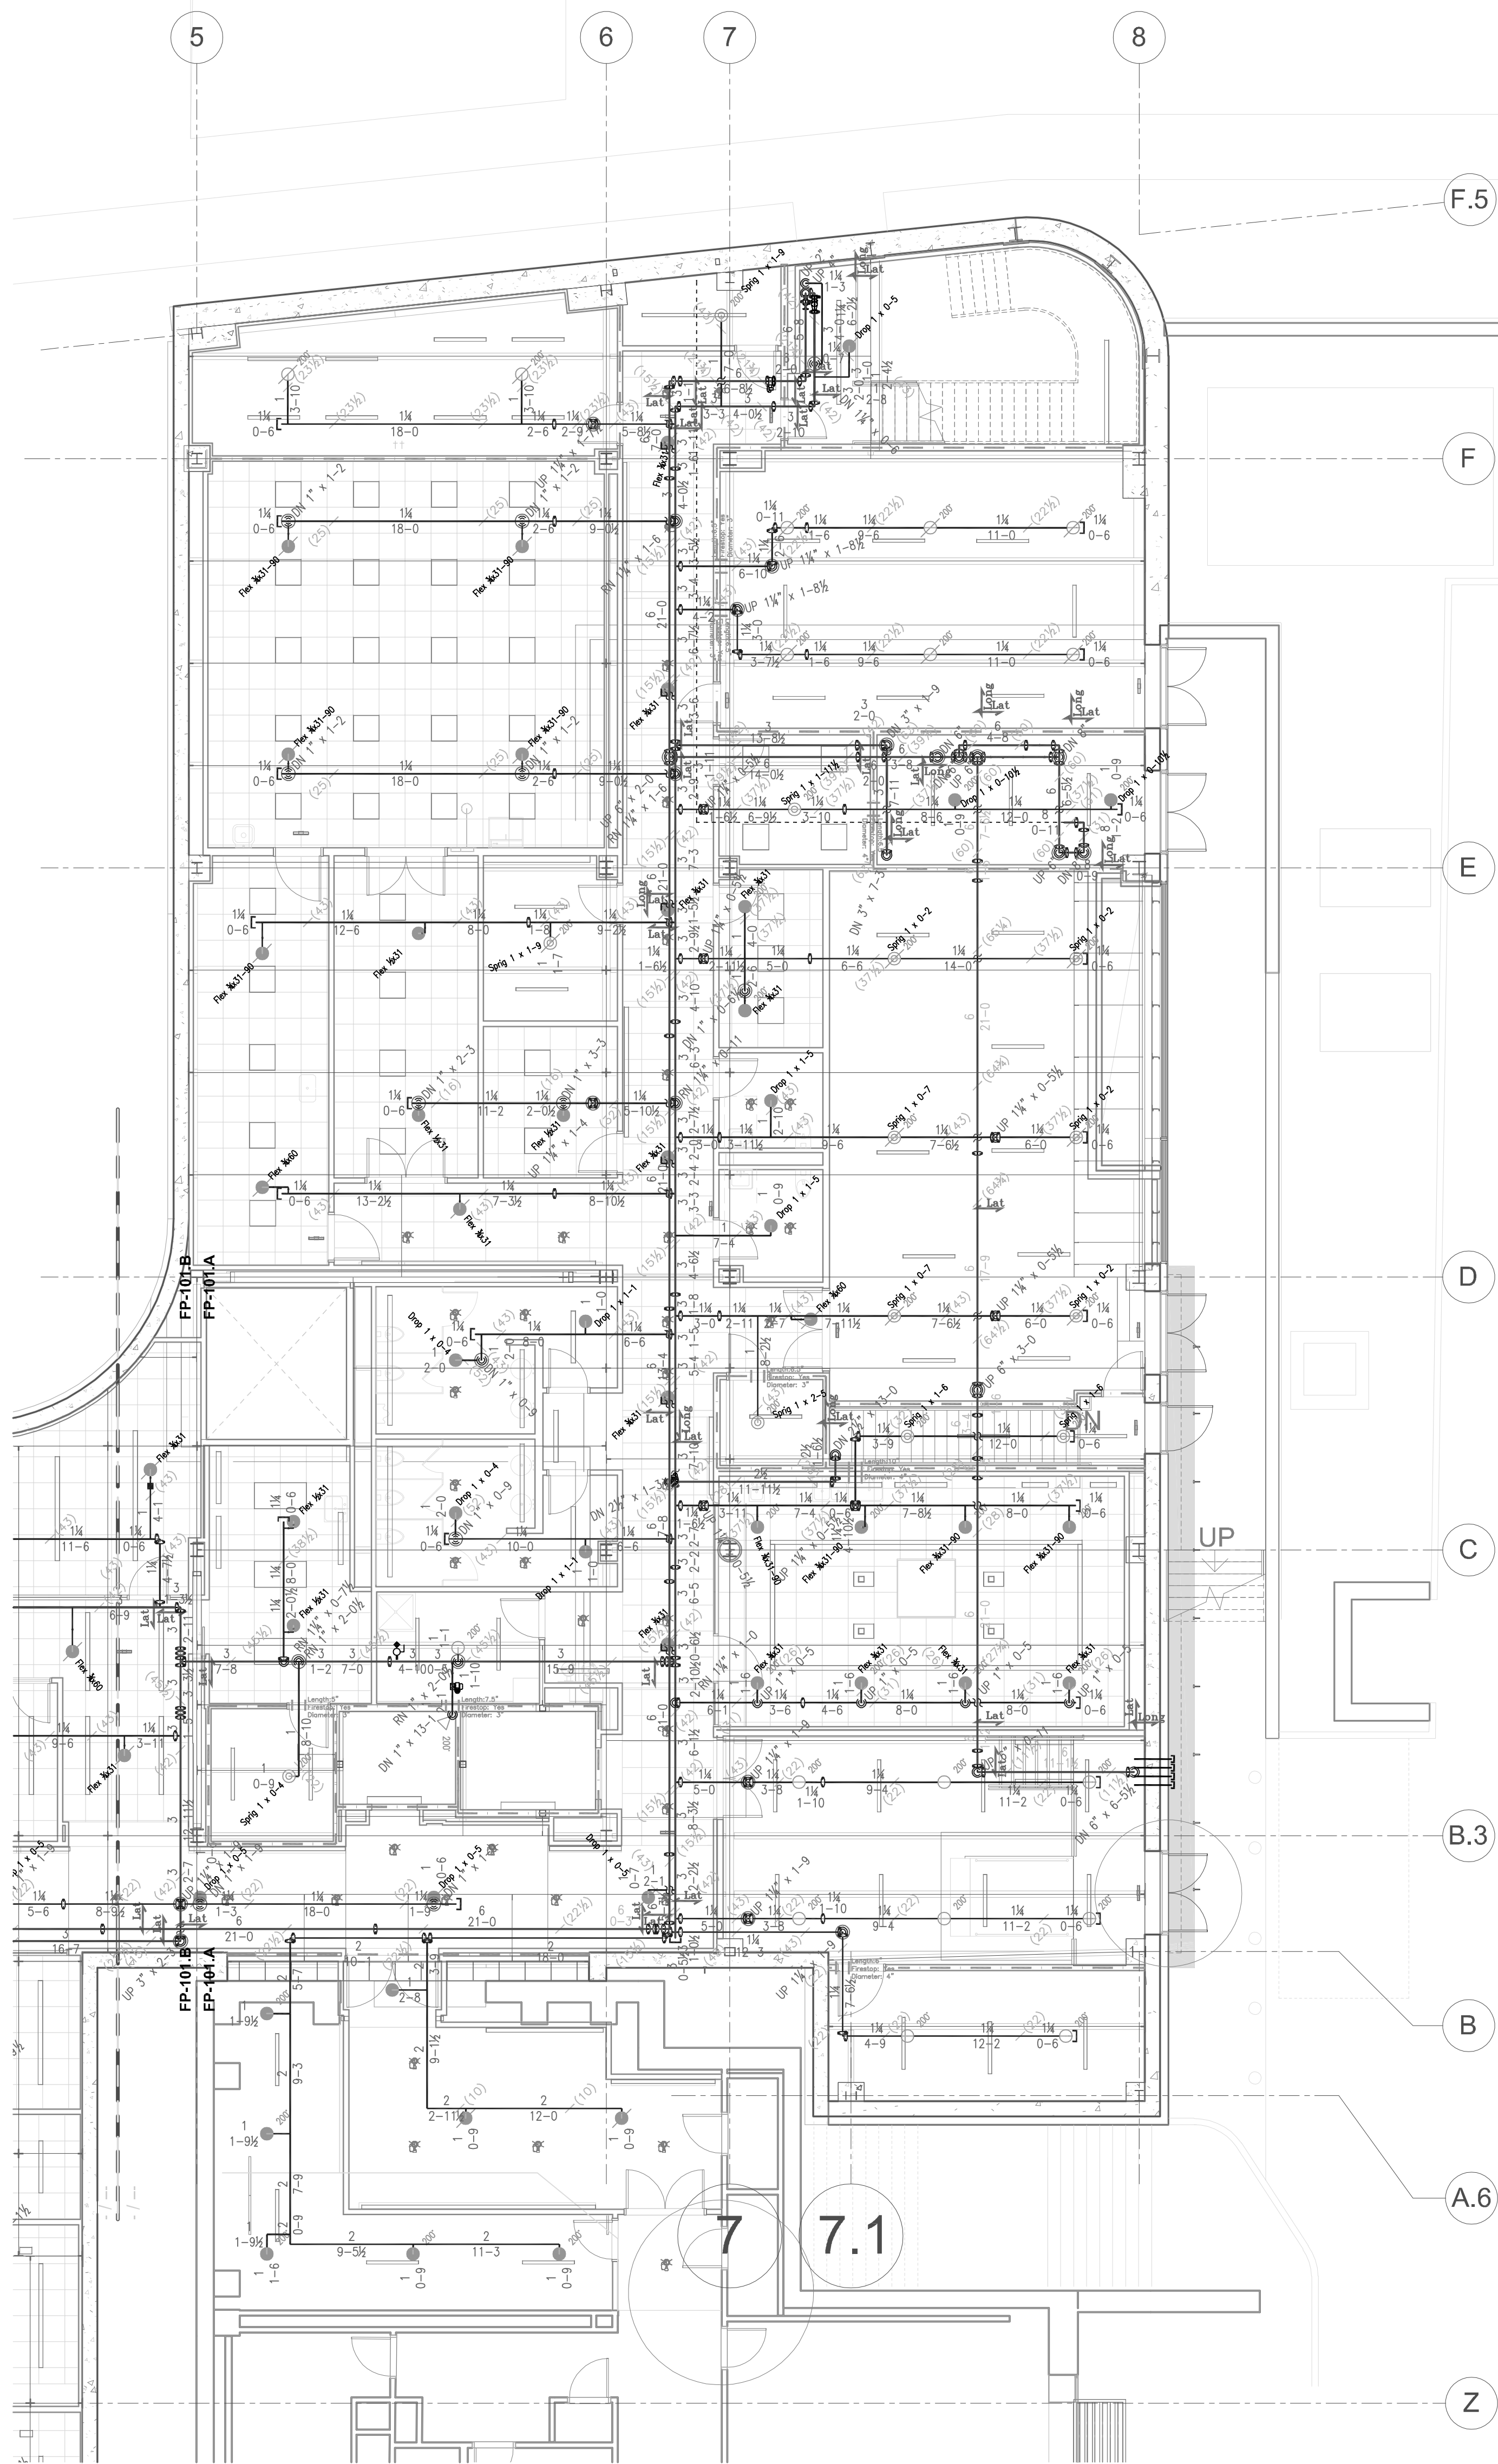
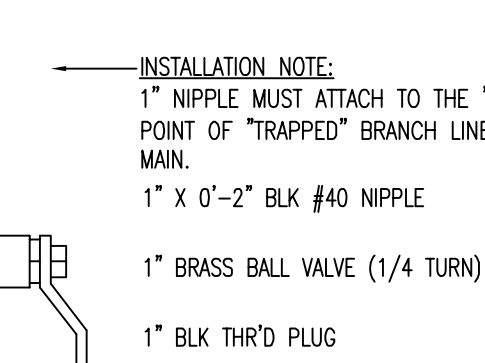
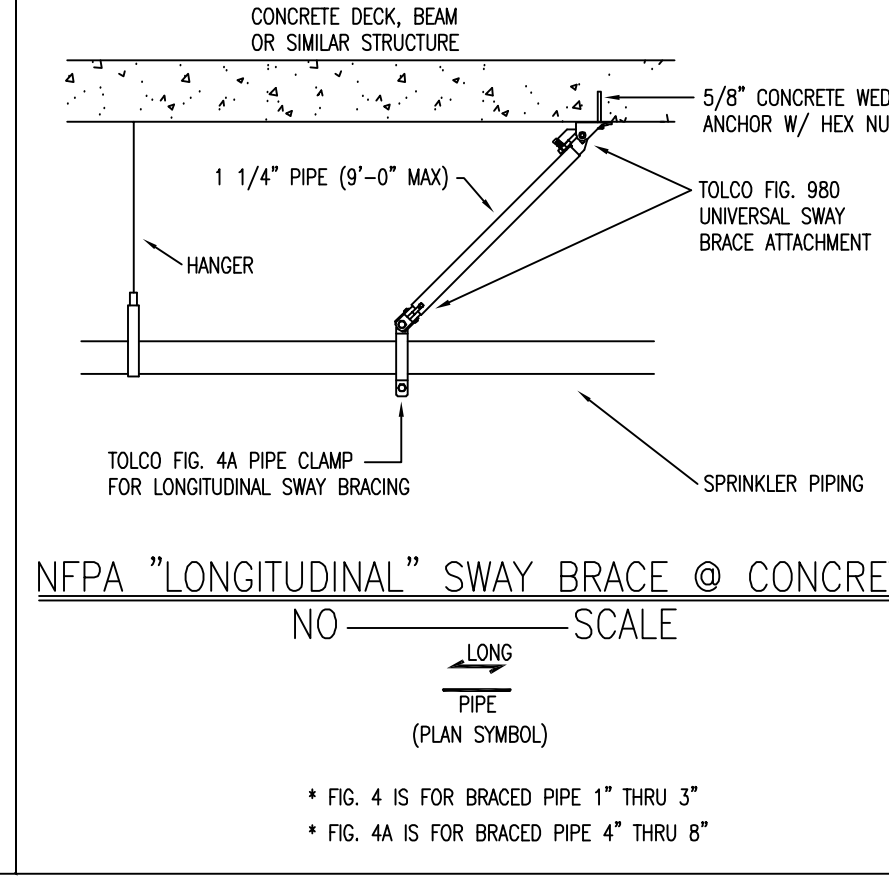


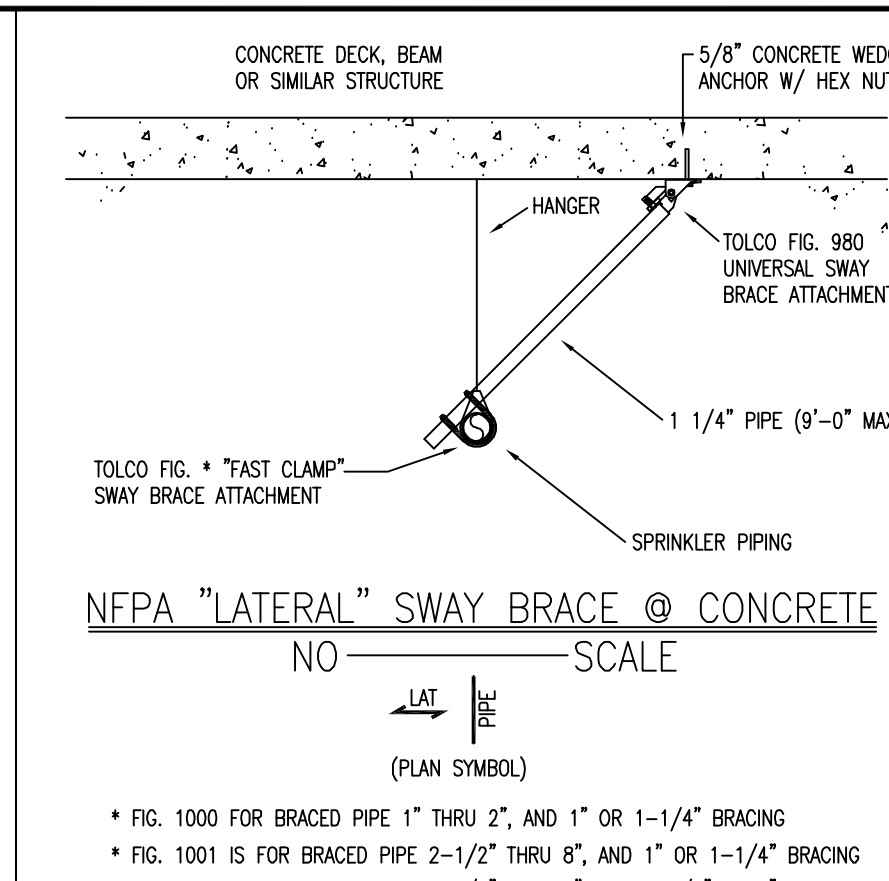

"AS-BUILTS" 08-01—2017										
	08/05/16 FM SCOPE REVIEW									
	10/26/16 POINT SET									
	11/16/16 INSTALLATION SET									
REV	DATE	REVISION DESCRIPTION								
		REVISION HISTORY								
AUTOMATIC SPREADSHEET DESIGN BASED ON THE FOLLOWING NFPA STANDARDS:										
☒ NFPA 13 — 2010 ☐ NFPA 13 R— 2002 ☐ NFPA 13 R— 2002	☐ NFPA 14 — 2003 ☐ NFPA 20 — 2003 ☐ OTHER									
The design information and data contained on this electronic media is provided to you as an instrument of service, protected by copyright law, and intended for use and reference relative only to the specific project they describe. J. F. Ahern Co. explicitly assumes no responsibility or liability for any other use of these electronic files whatsoever. The electronic files may not be copied, modified or released to a third party without the direct written permission of J. F. Ahern Co. Further, because transmission errors and read/write errors can occur and because electronic media stored can be modified by other parties intentionally or otherwise without notice of said modification, J. F. Ahern Co. cannot guarantee the accuracy of these files.										
 J. F. AHERN CO. FIRE PROTECTION CONTRACTORS 2675 Scott Ave., Suite C St. Louis, MO 63103-3047 (314) 535-4544 p (314) 535-0144 f www.jfahern.com										
KEYPLAN										
WEBSTER UNIV - INTER. SCIENCE BUILDING 8274 BIG BEND BLVD. WEBSTER GROVES, MO										
FIRE PROTECTION PLAN - LEVEL 0										
<table style="width: 100%; font-size: x-small;"> <tr> <td style="width: 20%;">DRAWN BY:</td> <td>DANA MITCHELL</td> </tr> <tr> <td>PROJECT WKT:</td> <td>KURT REUTHER</td> </tr> <tr> <td>DATE:</td> <td>07/25/2016</td> </tr> <tr> <td>CONTRACT NO.:</td> <td>461259</td> </tr> </table>			DRAWN BY:	DANA MITCHELL	PROJECT WKT:	KURT REUTHER	DATE:	07/25/2016	CONTRACT NO.:	461259
DRAWN BY:	DANA MITCHELL									
PROJECT WKT:	KURT REUTHER									
DATE:	07/25/2016									
CONTRACT NO.:	461259									
CONSTRUCTION DOCUMENTS										
FP-100.A										



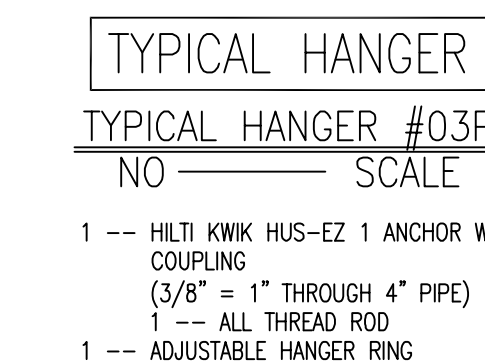


AUTOMATIC SPRINKLER SYSTEM PLAN
SCALE 1/8" = 1'-0"

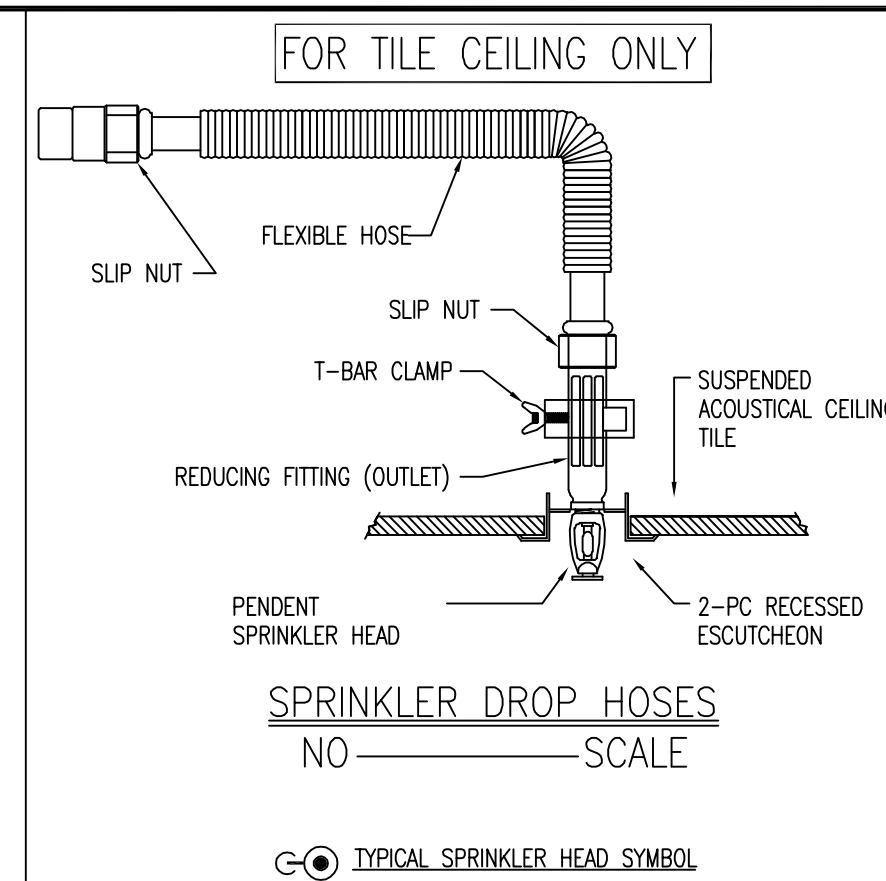

STOCKLIST NOTES

PRELIST NUMBER: 1
SYSTEM MAIN LETTERS: STA,STB,XD
STOCK LIST NUMBER: 0007
REQUEST FOR MATL. NO.: 123737
LIST COLOR CODE: YELLOW
BRANCH LINE NUMBERS: HV

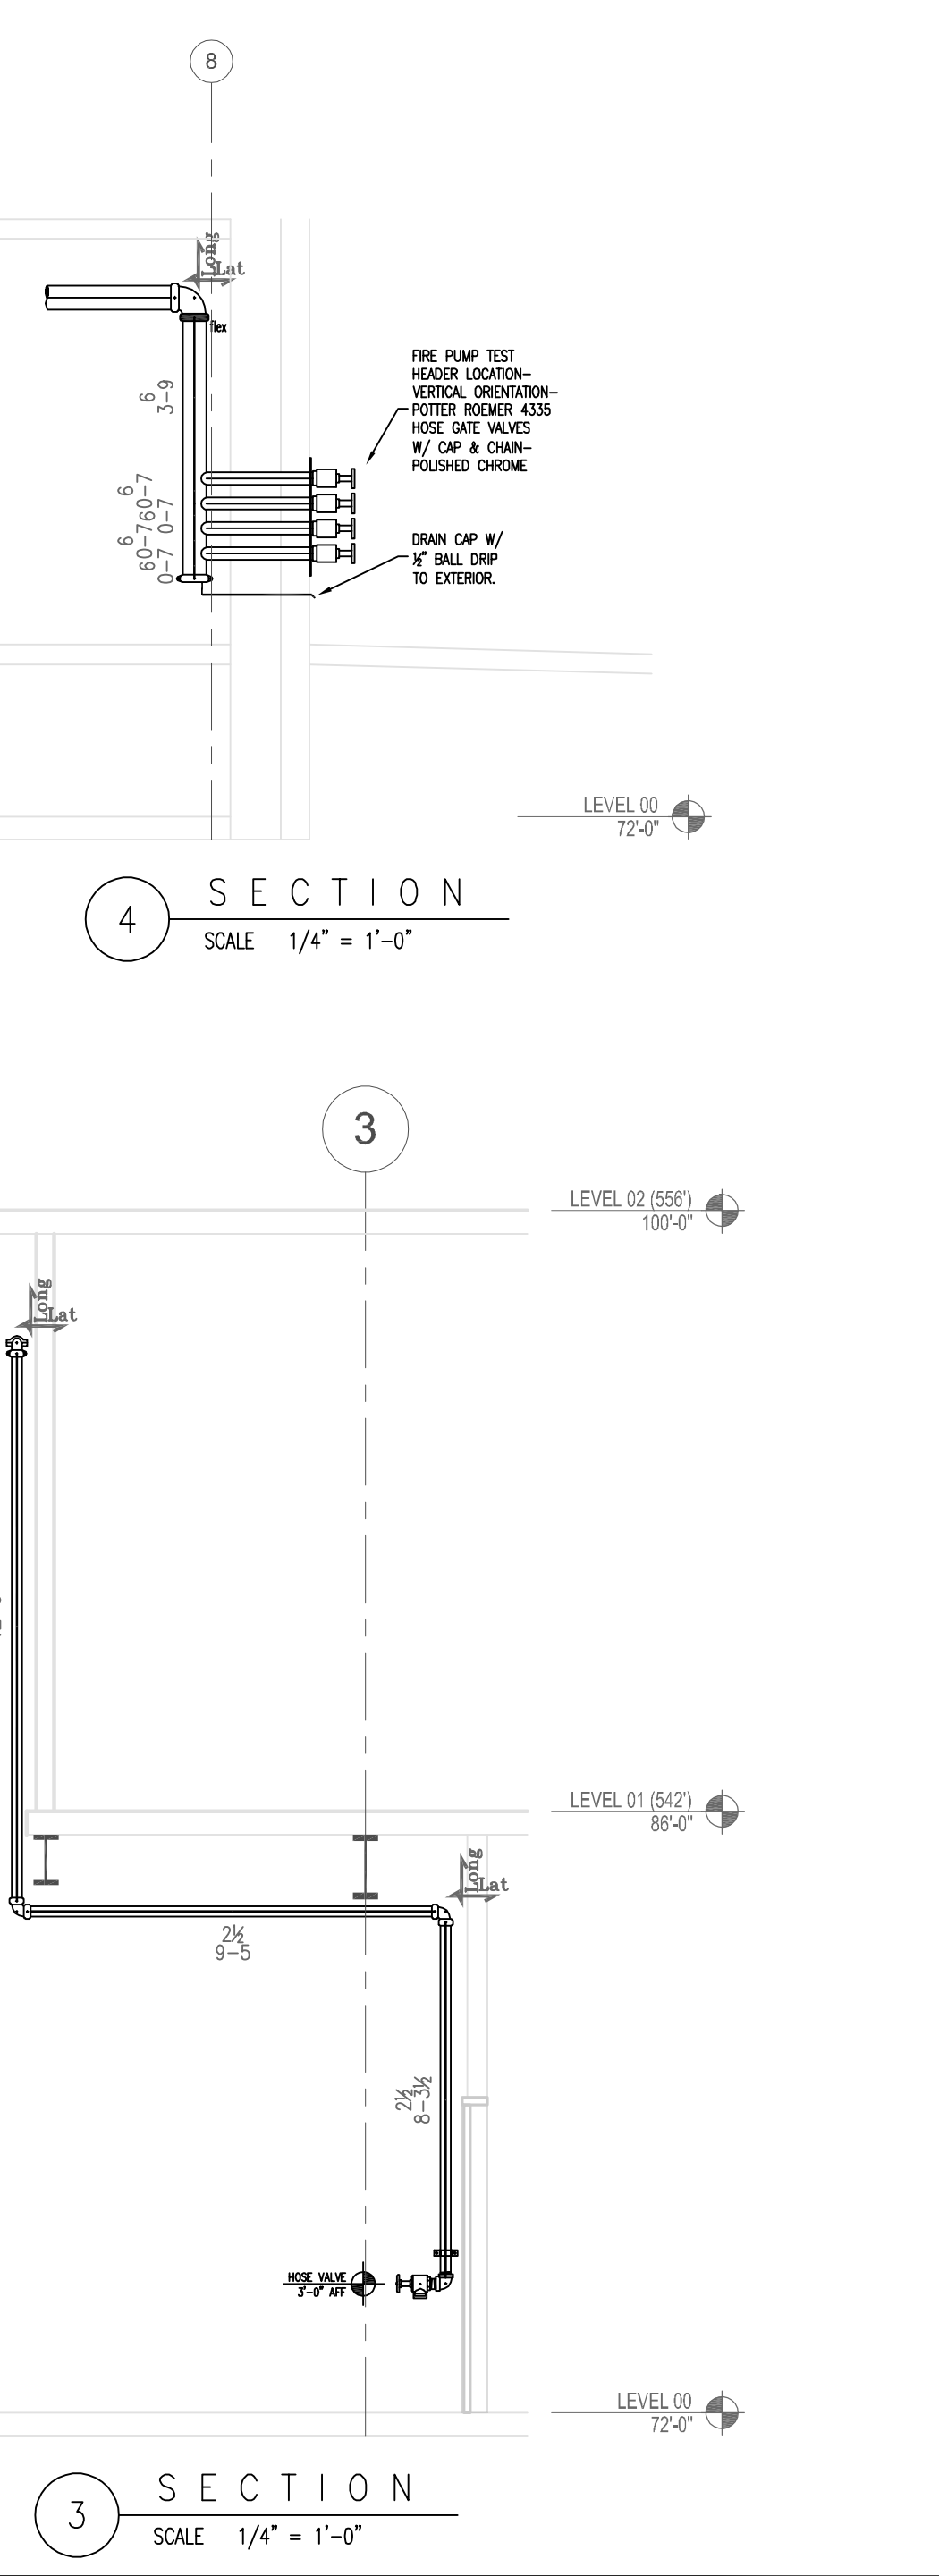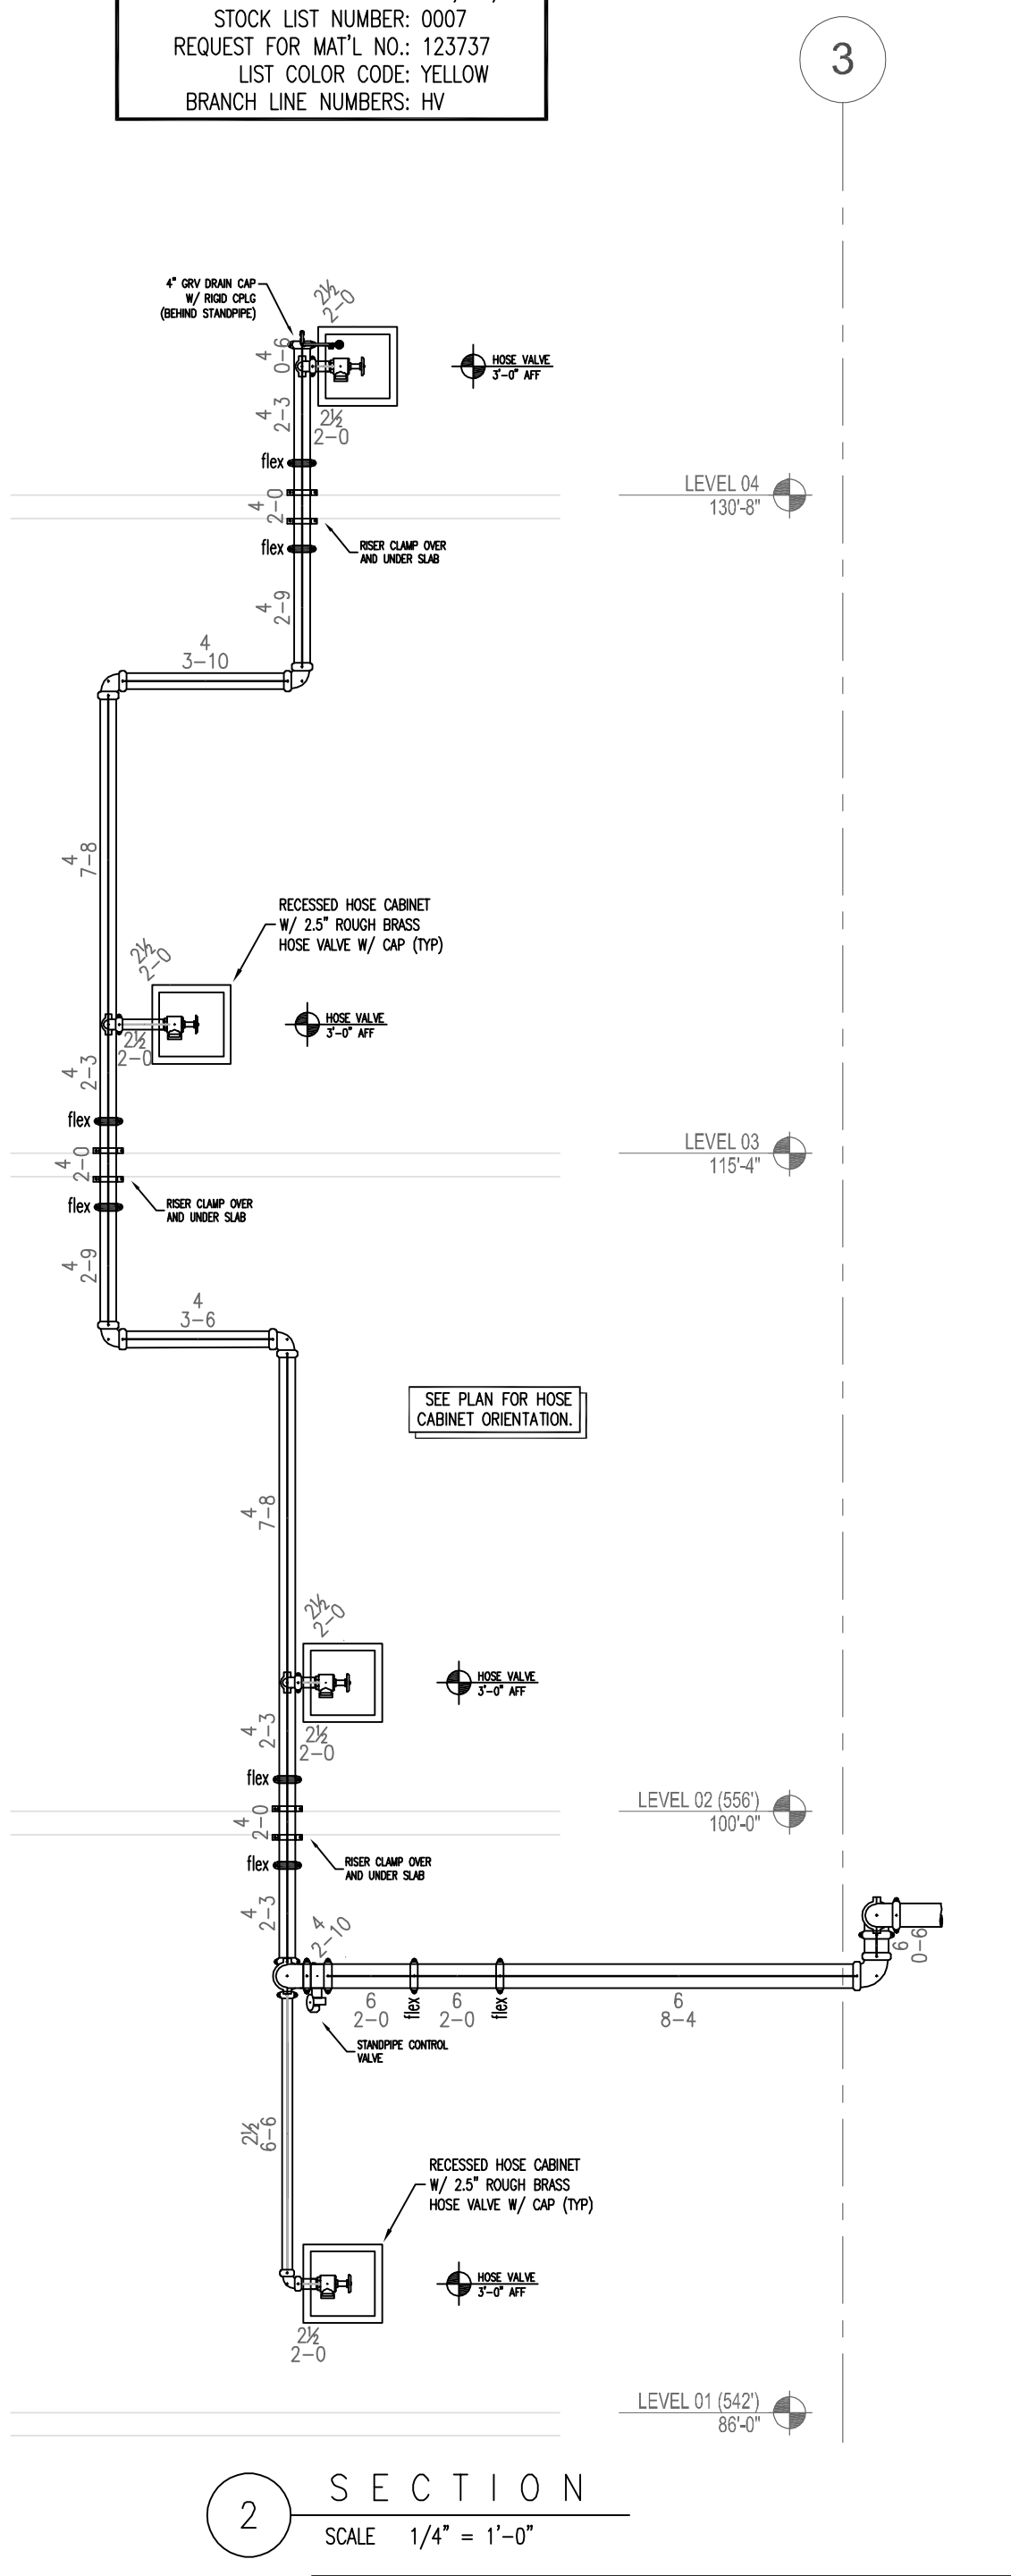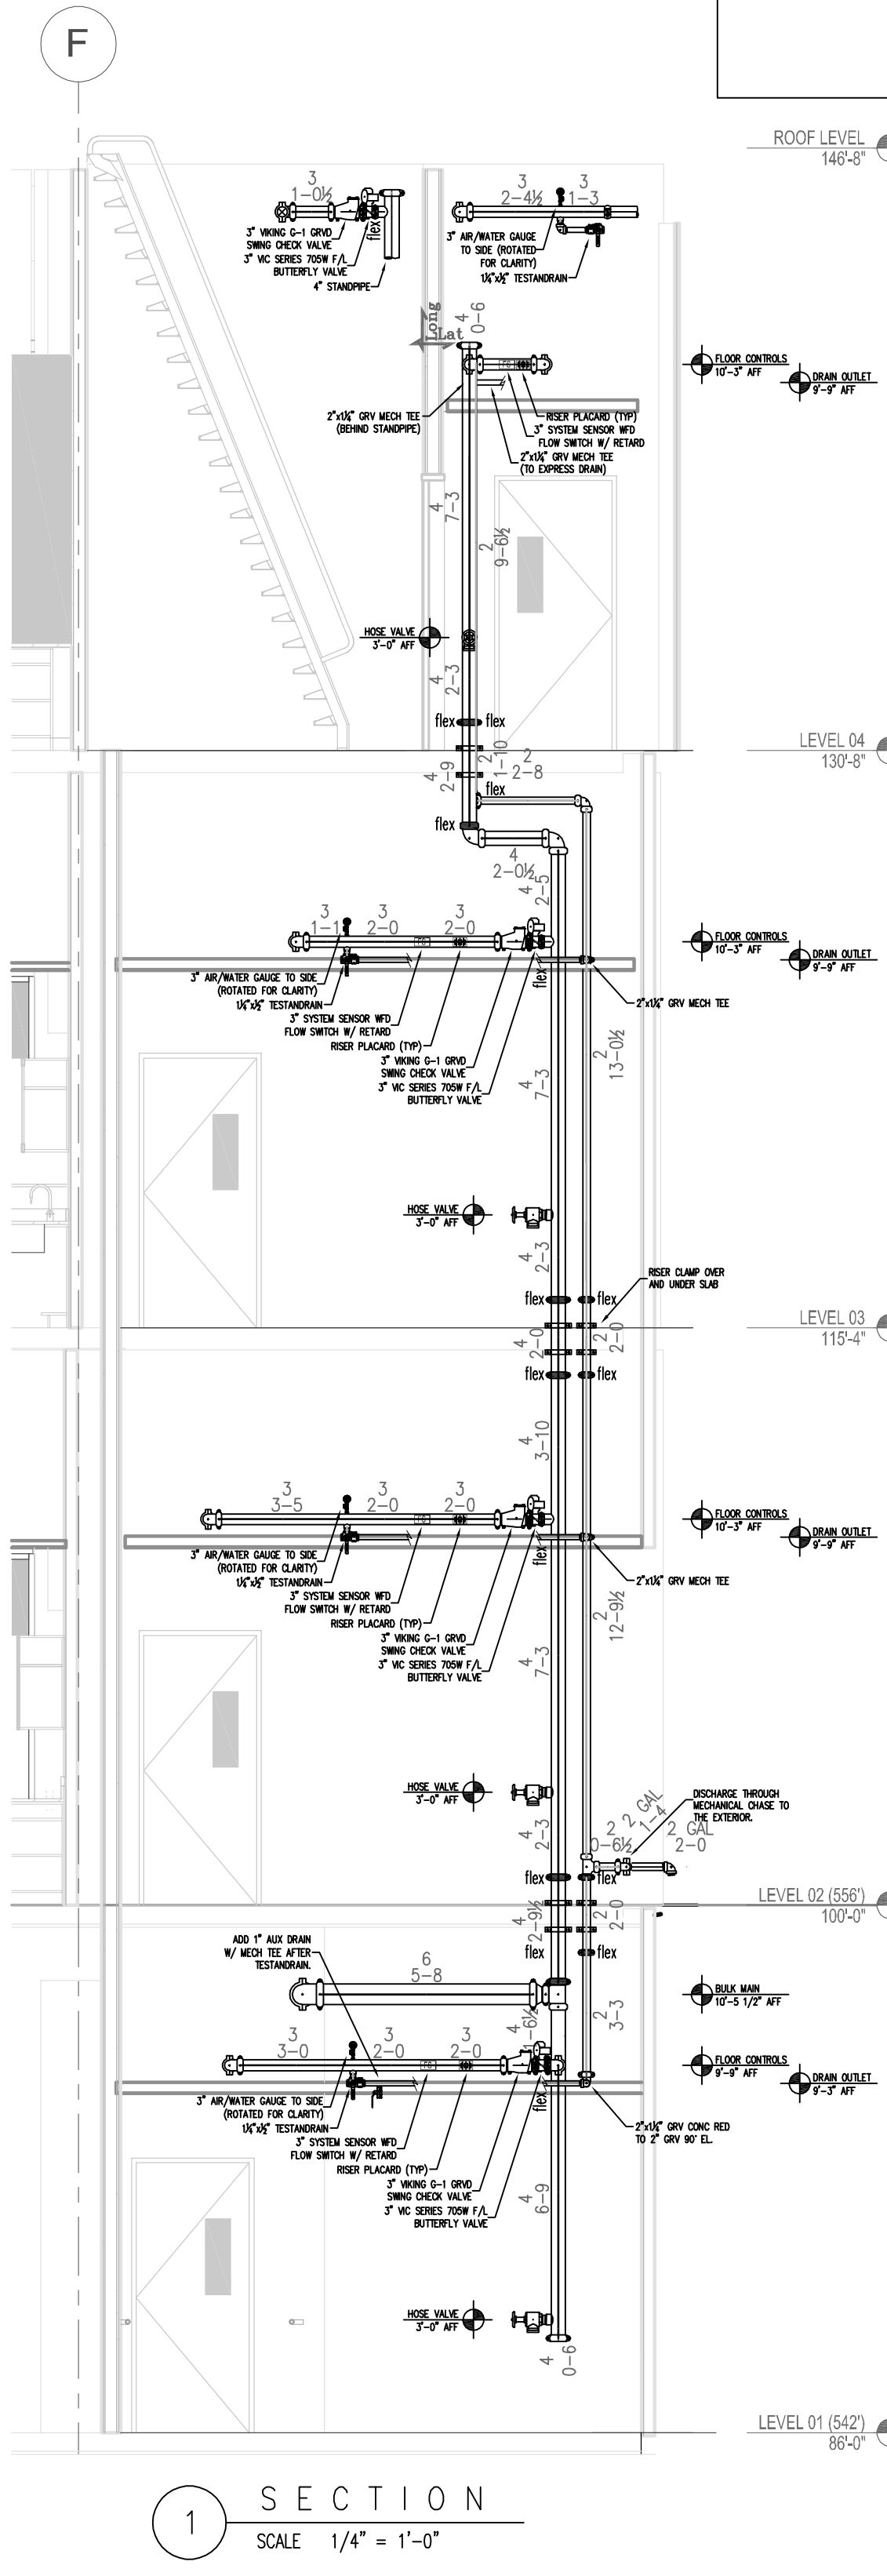


SPRINKLERS													
MAKE / VENDOR	MODEL	SIN	TYPE	RESPONSE TYPE	THREAD SIZE	NOM. "X"	CALC'D COVERAGE	DEFLECT. DISTANCE	TEMP.	FINISH	ESC.	WRENCH	SYMB.
Viking	M	WK300	UPR	QR	1/2"	5.6	225 SQ FT	1-12"	155	BRZ	N/A	1089SW/B	○
Viking	M	WK350	UPR	QR	3/4"	8.0	130 SQ FT	1-12"	200	BRZ	N/A	1089SW/B	○
Viking	EC	WK332	UPR	QR	3/4"	11.2	400 SQ FT	1-12"	200	BRZ	N/A	05118SW/B	○
Viking	MIRAGE	WK462	PND	QR	1/2"	5.6	225 SQ FT	1-12"	155	WHI	CONCLD	14047W/B	○
Viking	MIRAGE	WK464	PND	QR	3/4"	8.0	130 SQ FT	1-12"	200	WHI	CONCLD	14047W/B	○
Viking	MIRAGE EC	WK634	PND	QR	3/4"	8.0	400 SQ FT	1-12"	155	WHI	CONCLD	14047W/B	○
Viking	DRY	WK194	PND	QR	1"	5.6	225 SQ FT	1-12"	155	WHI	DOME CNCLD	0756SW/B	○
Viking	M	WK305	HSW	QR	1/2"	5.6	196 SQ FT	4-6"	200	BRZ	N/A	1089SW/B	○
TOTAL SPRINKLERS ON THIS CONTRACT:													560
TOTAL SPRINKLERS ON THIS SHEET:													80


"AS-BUILTS"
08-01-2017

REV	DATE	REVISION DESCRIPTION
1	08/05/16	FW SCOPE REVIEW
2	10/26/16	PERMIT SET
3	12/2/16	INSTALLATION SET
4	12/2/16	HANGER REVISION
5	1/3/17	INSTALLATION - STANDOFFS
6		
7		
8		
80		

The design information and data contained on this electronic media is provided to you as an instrument of service, protected by copyright law, and intended for use and reference relative only to the specific project they describe. J. F. Ahern Co. explicitly assumes no responsibility or liability for any other use of these electronic files whatsoever. The electronic files may not be copied, modified or released to a third party without the direct written permission of J. F. Ahern Co. Further, because transmission errors and read/write errors can occur and because electronic media stored can be modified by other parties intentionally or otherwise without notice of said modification, J. F. Ahern Co. cannot guarantee the accuracy of these files.

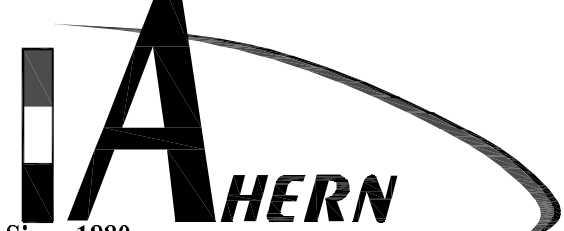


J. F. AHERN CO.
FIRE PROTECTION CONTRACTORS
2675 Scott Ave., Suite C
St. Louis, MO 63103-3047
(314) 535-4544 p (314) 535-0144 f
www.jfahern.com

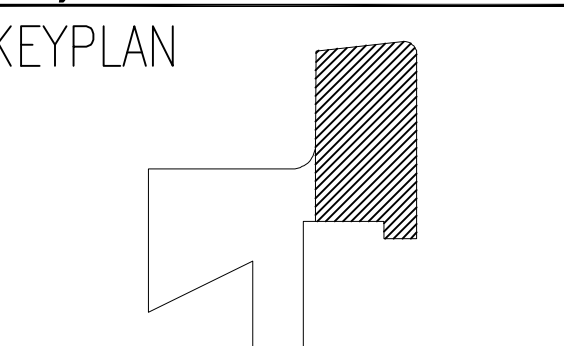


WEBSTER UNIV - INTER. SCIENCE BUILDING
8274 BIG BEND BLVD.
WEBSTER GROVES, MO

FIRE PROTECTION PLAN - LEVEL 1 - AREA A

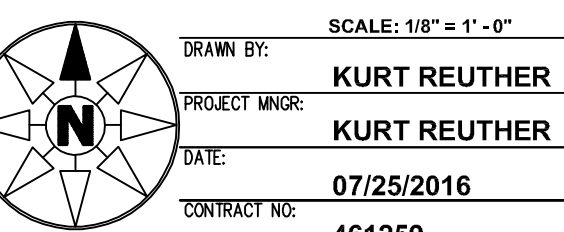




CONSTRUCTION DOCUMENTS
FP-101.A

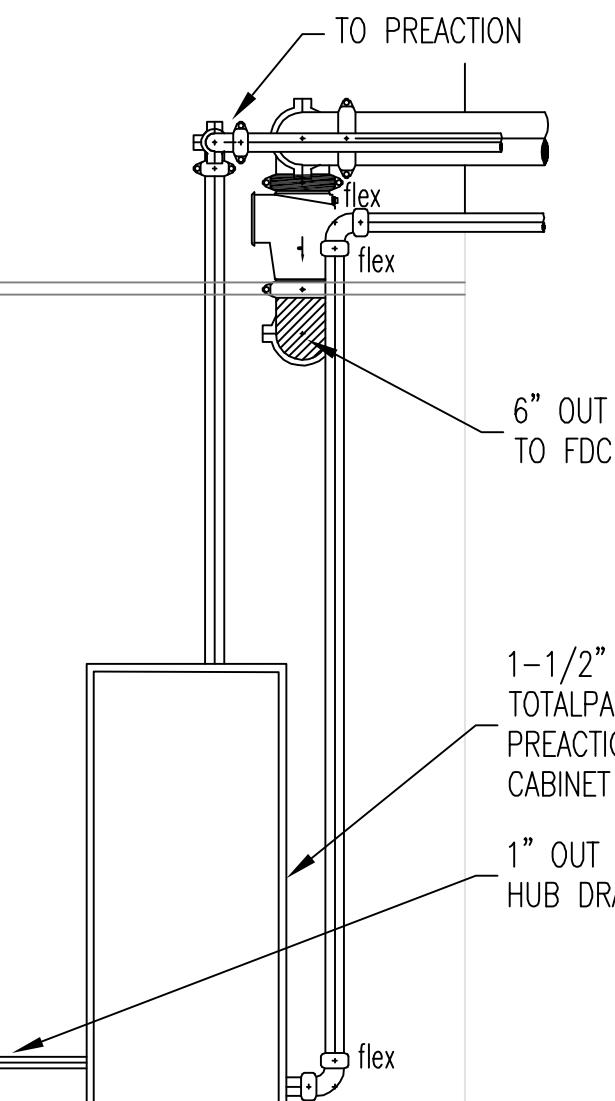


AUTOMATIC SPRINKLER SYSTEM PLAN
SCALE 1/8" = 1'-0"

SPRINKLERS														
MAKE / VENDOR	MODEL	SIN	TYPE	RESPONSE TIME	THREAD SIZE	NOM. V.Y.	CALCD COVERAGE	DEFLECT. DISTANCE	TEMP.	FINISH	ESC.	WRENCH	SYMB.	QUANTITY
WIKING	M	W3030	UPR	QR	1/2"	5.6	225 SQ FT	1'-12"	155°	BRZ	N/A	10869W		3
WIKING	M	W4550	UPR	QR	3/4"	8.0	130 SQ FT	1'-12"	200°	BRZ	N/A	10868W		3
WIKING	EC	W6323	UPR	QR	3/4"	8.0	130 SQ FT	1'-12"	155°	BRZ	N/A	10869W		3
WIKING	MIRAGE	W4644	PND	QR	1/2"	5.6	225 SQ FT	1'-12"	155°	WHT	CONCLD	10474W		4
WIKING	MIRAGE	W4644	PND	QR	3/4"	8.0	130 SQ FT	1'-12"	200°	WHT	CONCLD	10474W		4
WIKING	MIRAGE	EC	W4644	PND	QR	3/4"	8.0	450 SQ FT	1'-12"	155°	WHT	CONCLD	10474W	4
WIKING	DRY	W1134	PND	QR	1"	5.6	225 SQ FT	1'-12"	155°	WHT	DONE	CONCLD	07369W	1
WIKING	M	W3035	HSW	HSW	1/2"	5.6	196 SQ FT	4'-6"	200°	BRZ	N/A	10869W		1
TOTAL SPRINKLERS ON THIS SHEET: 560														84
TOTAL SPRINKLERS ON THIS SHEET: 84														

 FP-101.B

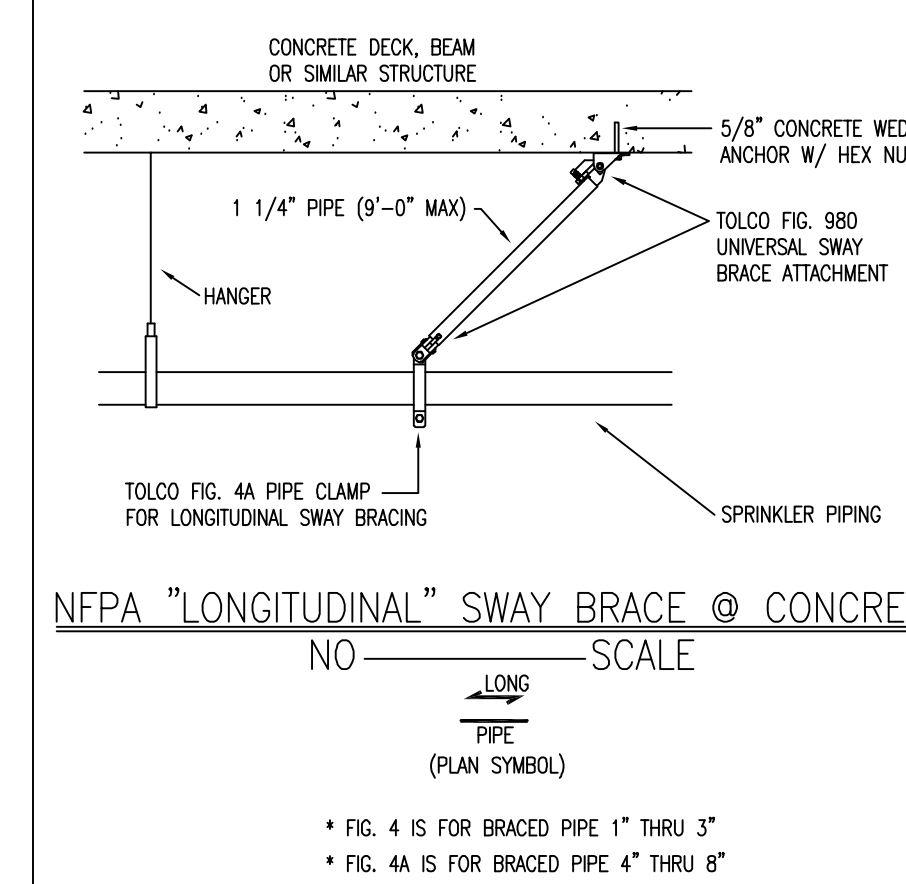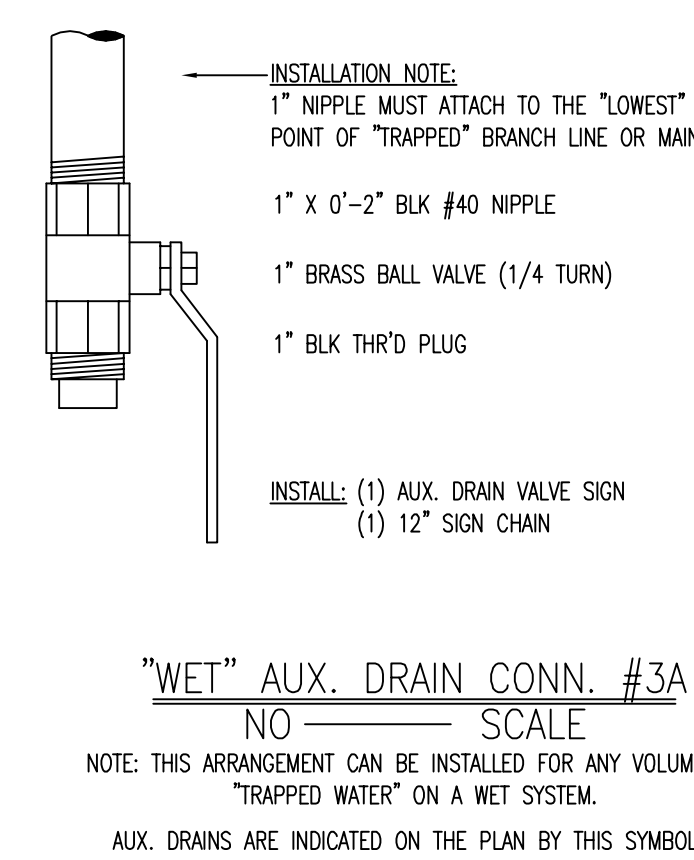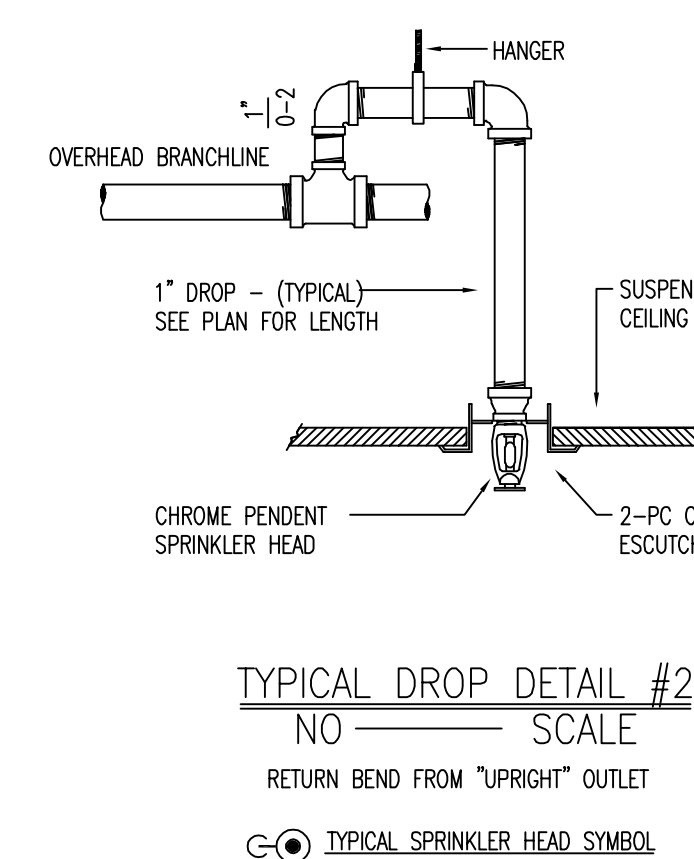

SPRINKLERS														
MAKE / VENDOR	MODEL	SIN	TYPE	RESPONSE TIME	THREAD SIZE	NOM. "K"	OMC/D COVERAGE	DEFLECT. DISTANCE	TEMP.	FINISH	ESC.	WRENCH	SYMB.	QUANT.
VIKING	M	VK300	UPR	GR	1/2"	5.6	225 SQ FT	1-1/2"	155°	BRZ	N/A	1089N/8		3
VIKING	M	VK360	UPR	GR	3/4"	8.0	130 SQ FT	1-1/2"	200°	BRZ	N/A	1089N/8		3
VIKING	EC	VK632	UPR	GR	3/4"	11.2	245 SQ FT	1-1/2"	200°	WHIT	CONCLD	14047N/8		13
VIKING	MIRAGE	VK462	PND	GR	3/4"	5.6	225 SQ FT	1-1/2"	155°	WHIT	CONCLD	14047N/8		3
VIKING	MIRAGE	VK464	PND	GR	3/4"	8.0	130 SQ FT	1-1/2"	200°	WHIT	CONCLD	14047N/8		3
VIKING	MIRAGE EC	VK634	PND	GR	3/4"	8.0	400 SQ FT	1-1/2"	155°	WHIT	CONCLD	14047N/8		33
RELIABLE VIKING	CS-56 DRY	BA114	PND	GR	1/2"	5.6	225 SQ FT	1-1/2"	155°	WHIT	CONCLD	1089N/8		3
VIKING	M	VK305	HSW	GR	1/2"	5.6	198 SQ FT	4-6"	200°	BRZ	N/A	1089N/8		3
TOTAL SPRINKLERS ON THIS SHEET: 560														
TOTAL SPRINKLERS ON THIS SHEET: 71														

"AS-BUILTS"
08-01-2017


[illegible]

The design information and data contained on this electronic media is provided to you as an instrument of service, protected by copyright law, and intended for use and reference relative only to the specific project they describe. J. F. Ahern Co. explicitly assumes no responsibility or liability for any other use of these electronic files whatsoever. The electronic files may not be copied, modified or released to a third party without the direct written permission of J. F. Ahern Co. Further, because transmission errors and read/write errors can occur and because electronic media stored can be modified by other parties intentionally or otherwise without notice of said modification, J. F. Ahern Co. cannot guarantee the accuracy of these files.





J. F. AHERN CO.
FIRE PROTECTION
CONTRACTORS
2675 Scott Ave., Suite C
St. Louis, MO 63103-3047
(314) 535-4544 p (314) 535-0144 f
www.jfahern.com

KEYPLAN



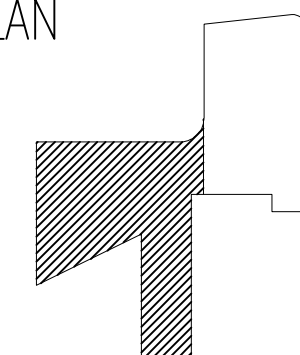


WEBSTER UNIV - INTER.
SCIENCE BUILDING
8274 BIG BEND BLVD.
WEBSTER GROVES, MO

**FIRE PROTECTION
PLAN - LEVEL 2 -
AREA B**

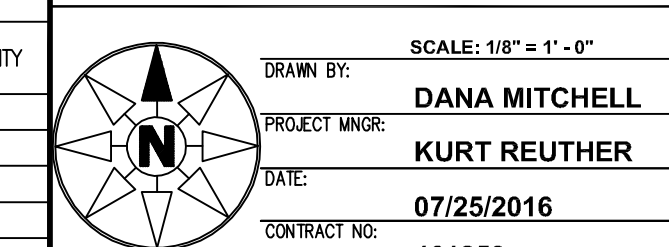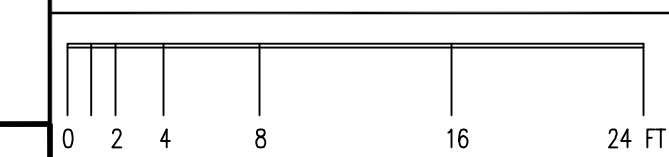46125
CONSTRUCTION DOCUMENTS

FP-102.B

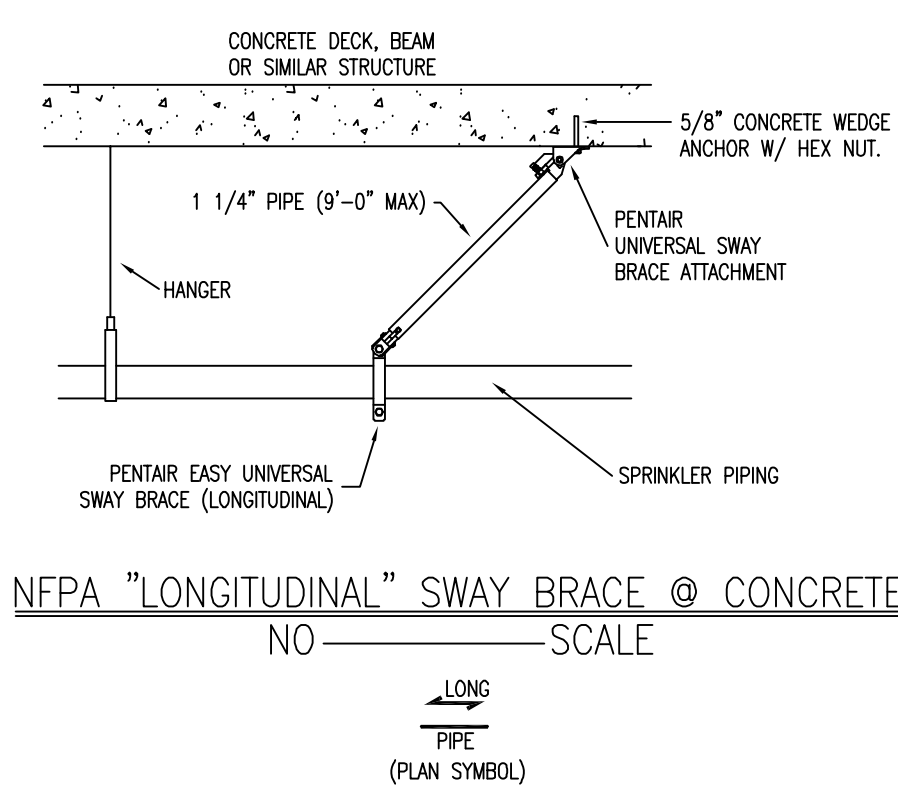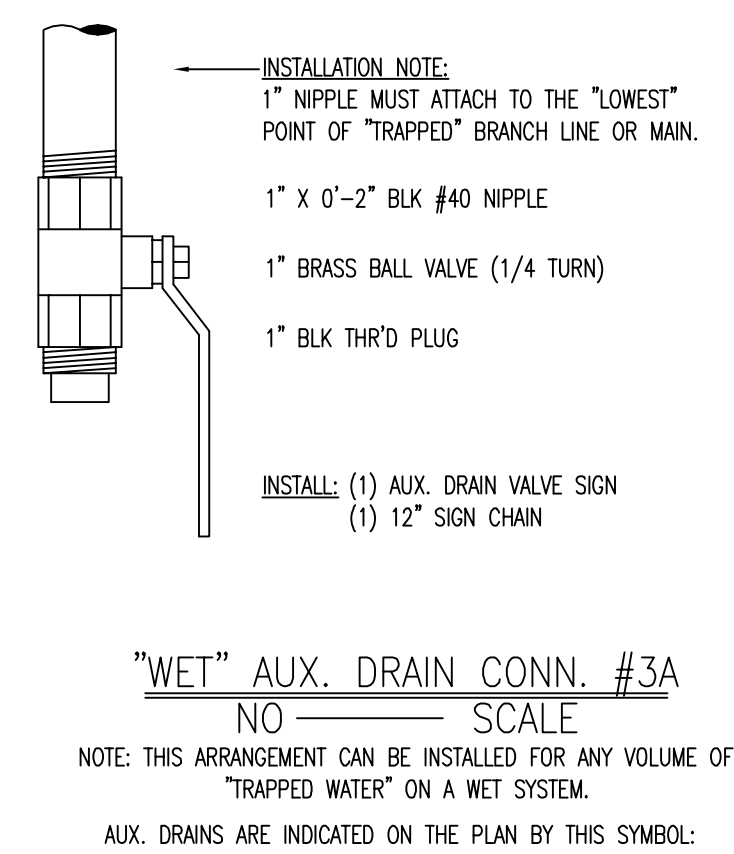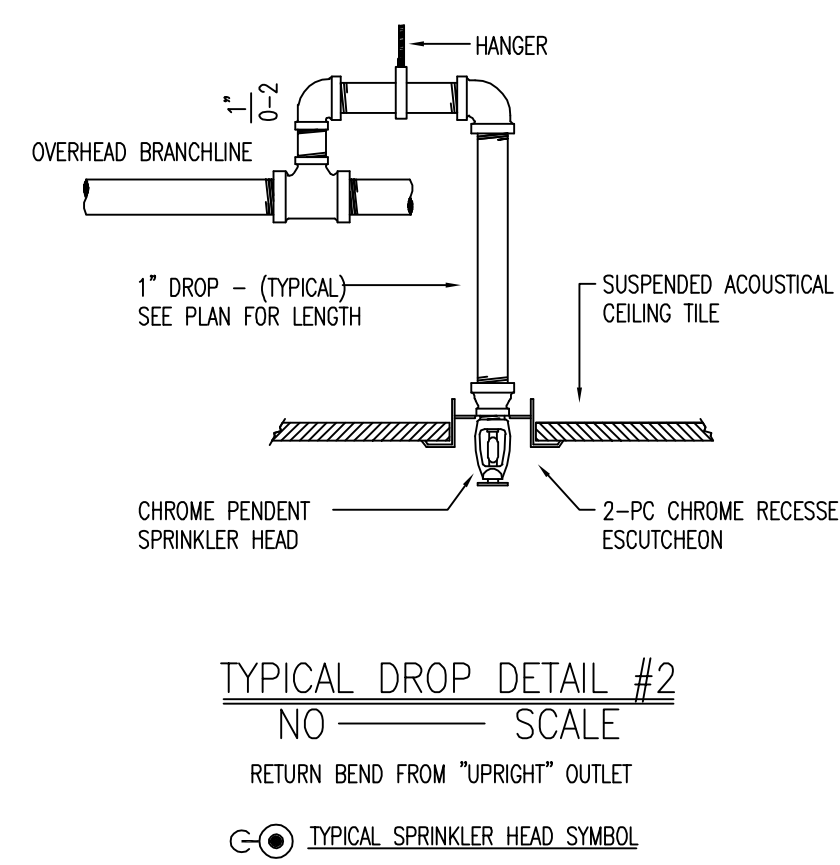
[illegible]

The design information and data contained on this electronic media is provided to you as an instrument of service, protected by copyright law, and intended for use and reference relative only to the specific project they describe. J. F. Ahern Co. explicitly assumes no responsibility or liability for any other use of these electronic files whatsoever. The electronic files may not be copied, modified or released to a third party without the direct written permission of J. F. Ahern Co. Further, because transmission errors and read/write errors can occur and because electronic media stored can be modified by other parties intentionally or otherwise without notice of said modification, J. F. Ahern Co. cannot guarantee the accuracy of these files.





J. F. AHERN CO.
FIRE PROTECTION
CONTRACTORS
2675 Scott Ave., Suite C
St. Louis, MO 63103-3047
(314) 535-4544 p (314) 535-0144 f
www.jfahern.com

KEYPLAN

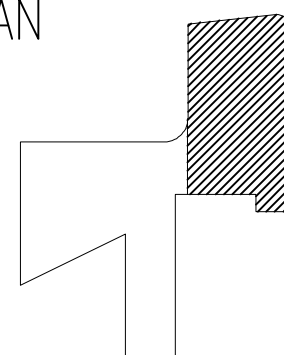


WEBSTER UNIV - INTER.
SCIENCE BUILDING
8274 BIG BEND BLVD.
WEBSTER GROVES, MO

**FIRE PROTECTION
PLAN - LEVEL 3 -
AREA A**





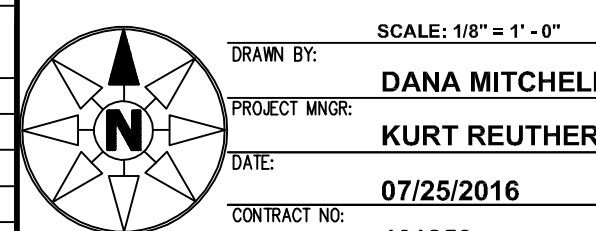
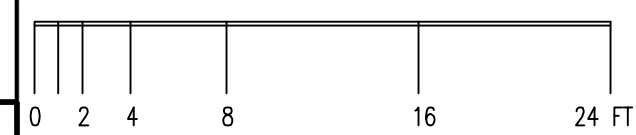


CONSTRUCTION DOCUMENT

SPRINKLERS														
MAKE / VENDOR	MODEL	SIN	TYPE	RESPONSE TYPE	THREAD SIZE	NOM. "K"	CAL'D COVERAGE	DEFLECT. DISTANCE	TEMP.	FINISH	ESC.	WRENCH	SYMB.	QUANTITY
VINGIR	M	VK300	UPR	QR	1/2"	5.6	225 SQ FT	1-12"	155°	BRZ	N/A	10896W/8		-
VINGIR	M	VK350	UPR	QR	3/4"	8.0	130 SQ FT	1-12"	200°	BRZ	N/A	10896W/8		-
VINGIR	EC	VK350	PND	QR	3/4"	8.0	130 SQ FT	1-12"	155°	WHIT	CONCLD	10467W/8		11
VINGIR	MIRAGE	VK462	PND	QR	1/2"	5.6	225 SQ FT	1-12"	155°	WHIT	CONCLD	10467W/8		11
VINGIR	MIRAGE	VK464	PND	QR	3/4"	8.0	130 SQ FT	1-12"	200°	WHIT	CONCLD	10467W/8		33
VINGIR	MIRAGE EC	VK464	PND	QR	3/4"	8.0	130 SQ FT	1-12"	155°	WHIT	CONCLD	10467W/8		33
VINGIR	EC	VK194	PND	QR	1/2"	5.6	225 SQ FT	1-12"	155°	WHIT	CONCLD	07056W/8		33
VINGIR	EC	VK534	PND	QR	3/4"	11.2	100 SQ FT	1-12"	200 °	CHR	E-1	05138W/8		33
TOTAL SPRINKLERS ON THIS CONTRACT:													560	
TOTAL SPRINKLERS ON THIS SHEET:													50	

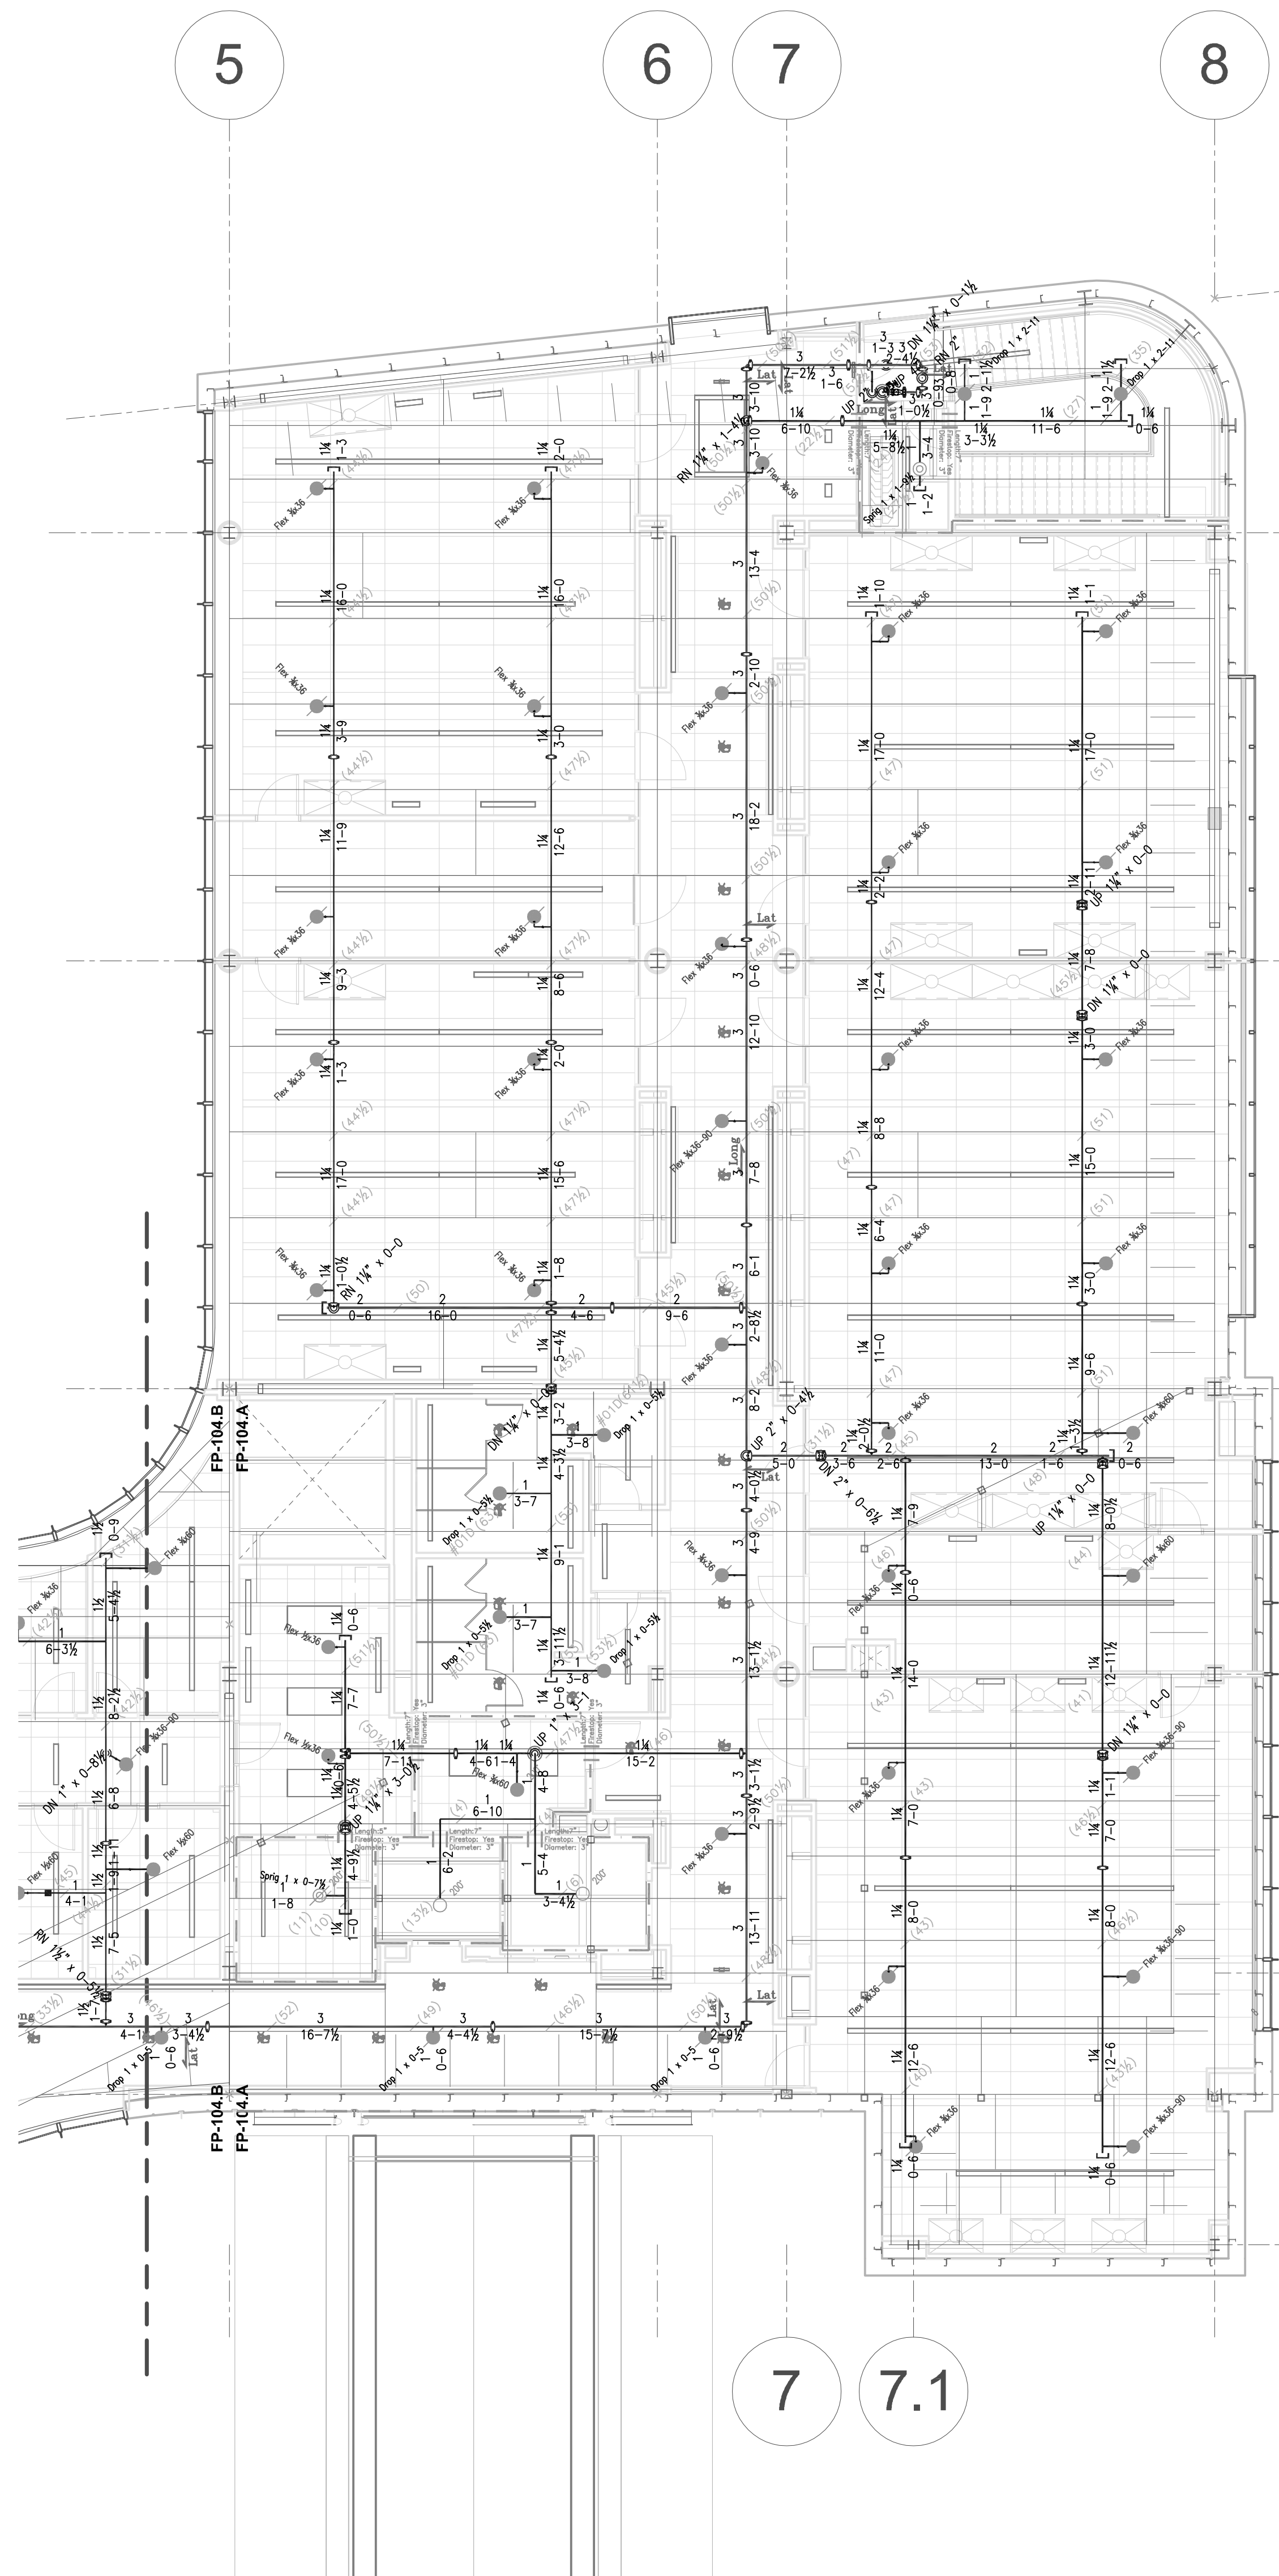

AUTOMATIC SPRINKLER SYSTEM PLAN
SCALE 1/8" = 1'-0"

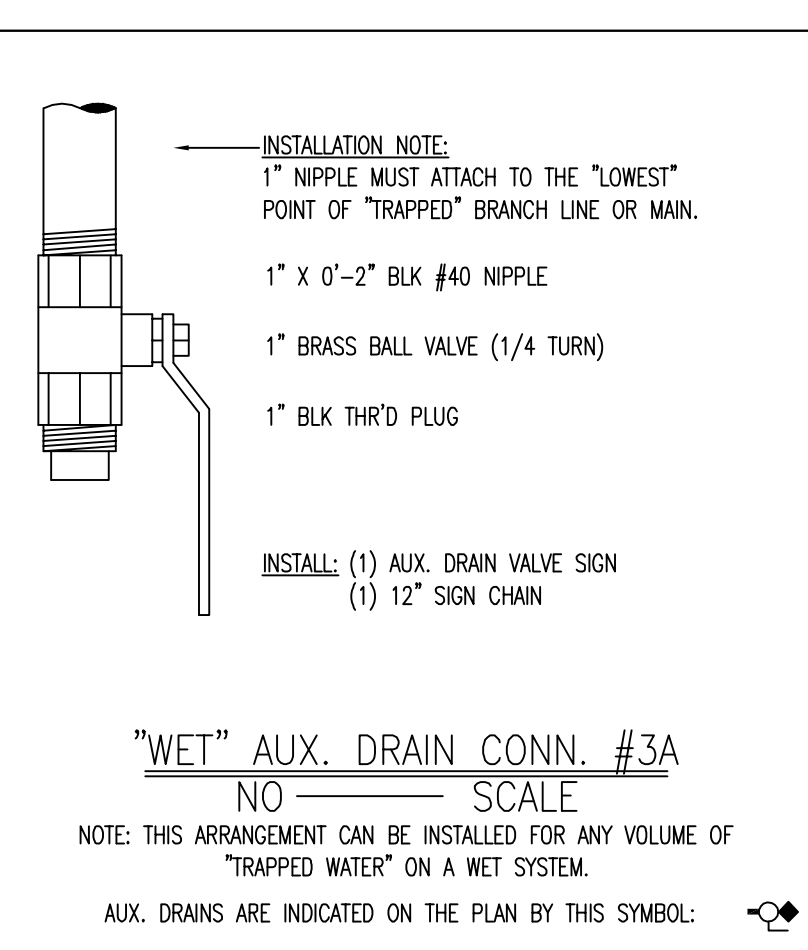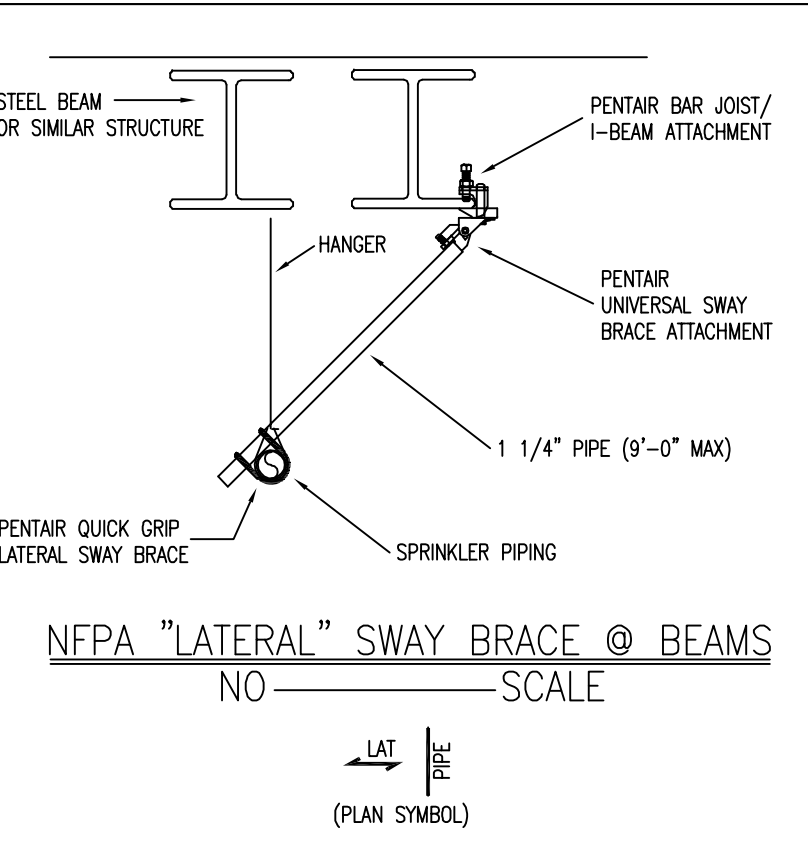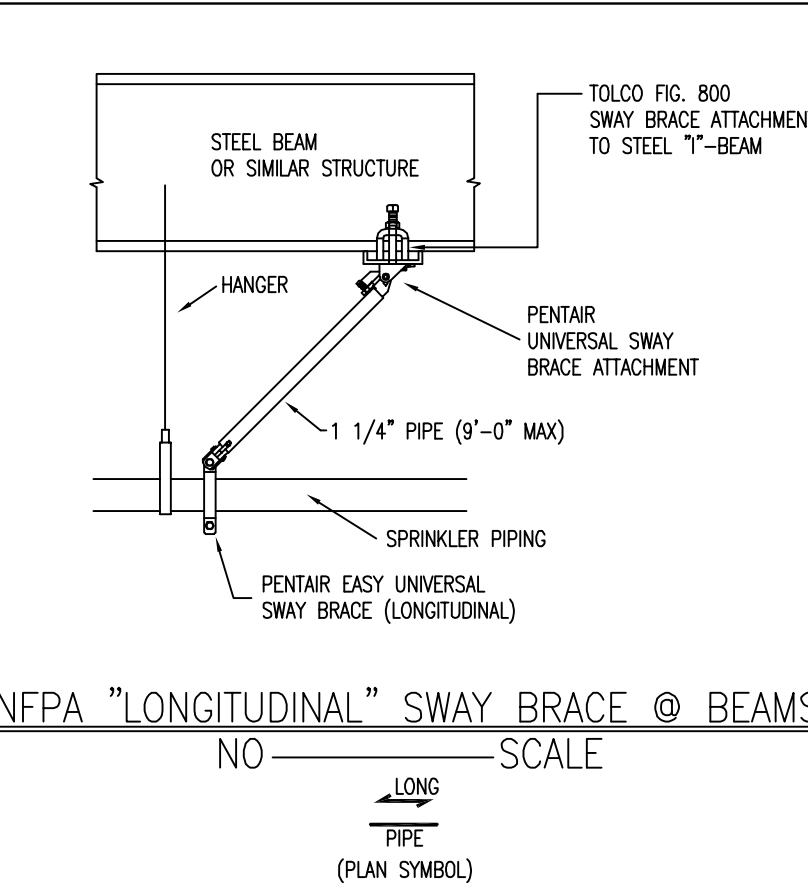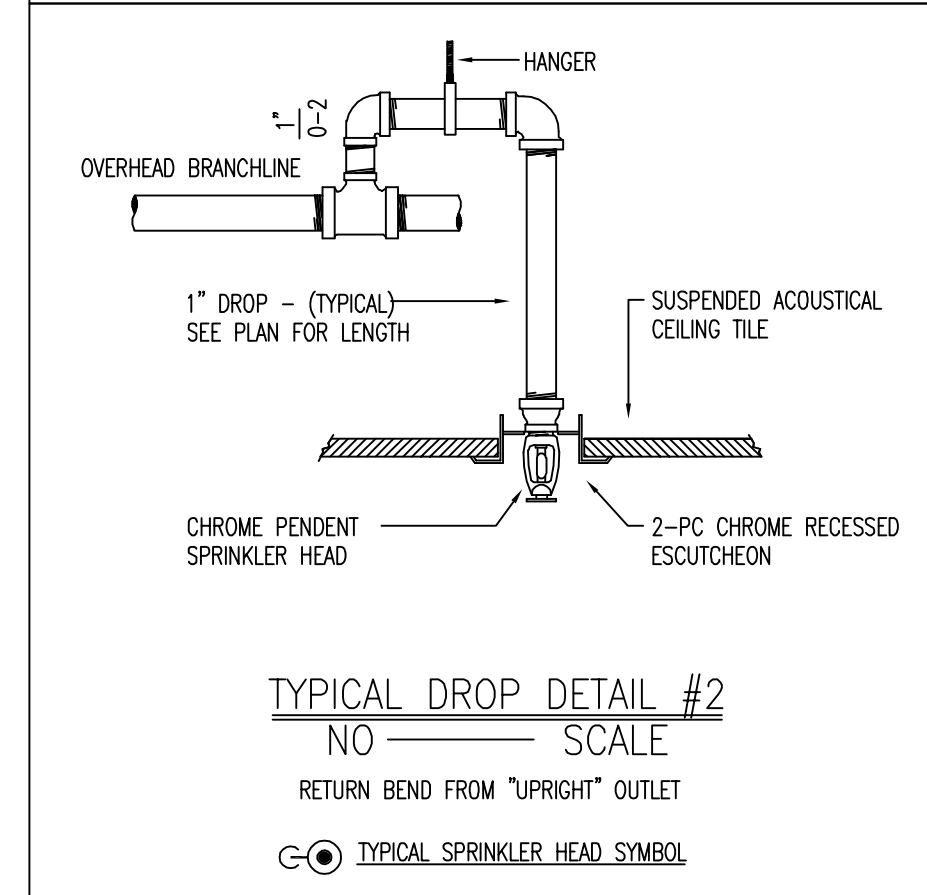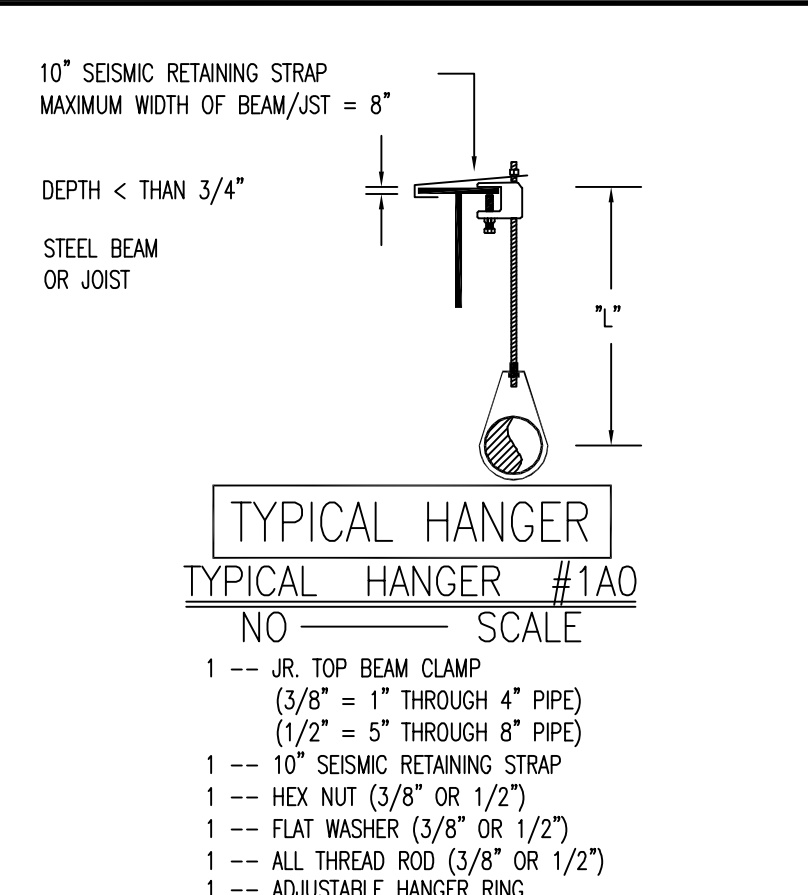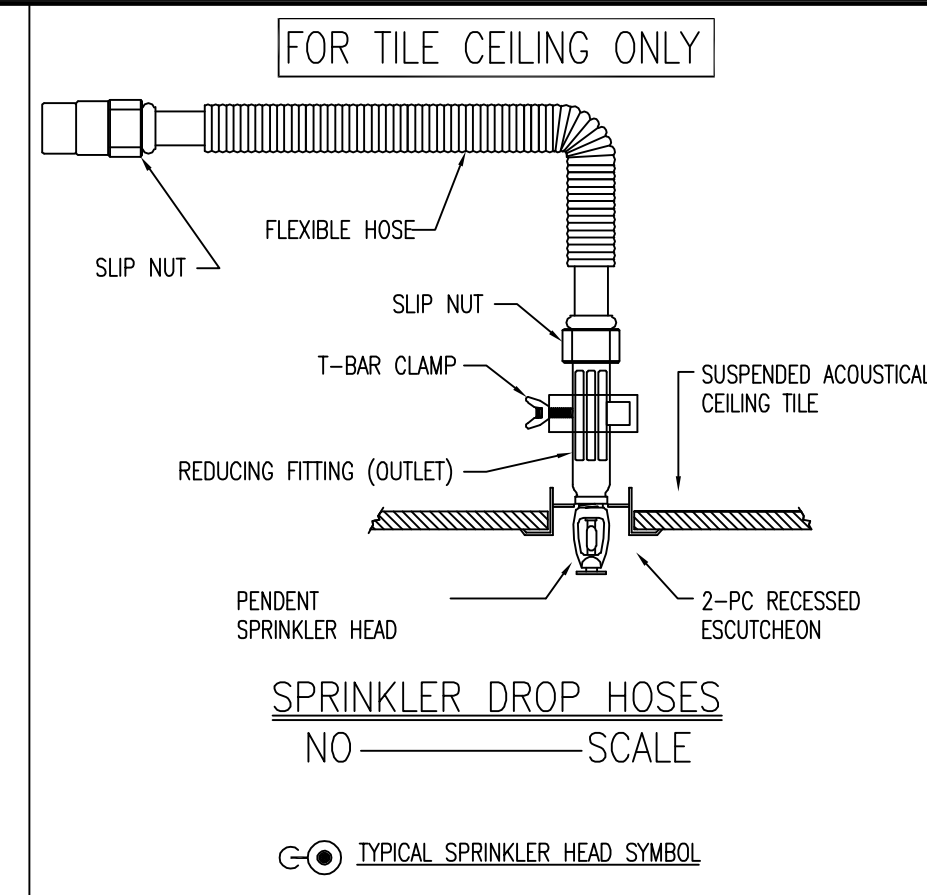

SPRINKLERS											
MAKE / VENDOR	MODEL	SIN	TYPE	RESPONSE TYPE	THREAD SIZE	NOM. "K"	CALC'D COVERAGE	DEFLECT. DISTANCE	TEMP.	FINISH	ESC.
VIKING	M	VK300	UPR	QR	1/2"	5.6	225 SQ FT	1-12"	155	BRZ	N/A
VIKING	M	VK350	UPR	QR	3/4"	8.0	130 SQ FT	1-12"	200	BRZ	N/A
VIKING	EC	VK532	UPR	QR	3/4"	11.2	400 SQ FT	1-12"	200	BRZ	N/A
VIKING	MIRAGE	VK462	PND	QR	1/2"	5.6	225 SQ FT	1-12"	155	WHI	CONCLD
VIKING	MIRAGE	VK464	PND	QR	3/4"	8.0	130 SQ FT	1-12"	200	WHI	CONCLD
VIKING	MIRAGE EC	VK634	PND	QR	3/4"	8.0	400 SQ FT	1-12"	155	WHI	CONCLD
VIKING	DRY	VK194	PND	QR	1"	5.6	225 SQ FT	1-12"	155	WHI	DOME CNCLD
VIKING	M	VK305	HSW	QR	1/2"	5.6	196 SQ FT	4-6"	200	BRZ	N/A
TOTAL SPRINKLERS ON THIS CONTRACT:										560	

"AS-BUILTS"

08-01-2017

REV	DATE	REVISION DESCRIPTION
1	08/05/16	FM SCOPE REVIEW
2	10/26/16	PERMIT SET
3	12/29/16	INSTALLATION SET
4		
5		
6		
7		
8		
9		
10		
11		
12		
13		
14		
15		
16		
17		
18		
19		
20		
21		
22		
23		
24		
25		
26		
27		
28		
29		
30		
31		
32		
33		
34		
35		
36		
37		
38		
39		
40		
41		
42		
43		
44		
45		
46		
47		
48		
49		
50		

REVISION HISTORY

AUTOMATIC SPRINKLER DESIGN BASED ON THE FOLLOWING NFPA STANDARDS:


■ NFPA 13—2010	□ NFPA 14—2003
□ NFPA 13 D—2002	□ NFPA 20—2003
□ NFPA 13 R—2002	□ OTHER

The design information and data contained on this electronic media is provided to you as an instrument of service, protected by copyright law, and intended for use and reference relative only to the specific project they describe. J. F. Ahern Co. explicitly assumes no responsibility or liability for any other use of these electronic files whatsoever. The electronic files may not be copied, modified or released to a third party without the direct written permission of J. F. Ahern Co. Further, because transmission errors and read/write errors can occur and because electronic media stored can be modified by other parties intentionally or otherwise without notice of said modification, J. F. Ahern Co. cannot guarantee the accuracy of these files.



J. F. AHERN CO.
FIRE PROTECTION CONTRACTORS
2675 Scott Ave., Suite C
St. Louis, MO 63103-3047
(314) 535-4544 p (314) 535-0144 f
www.jfahern.com

KEYPLAN

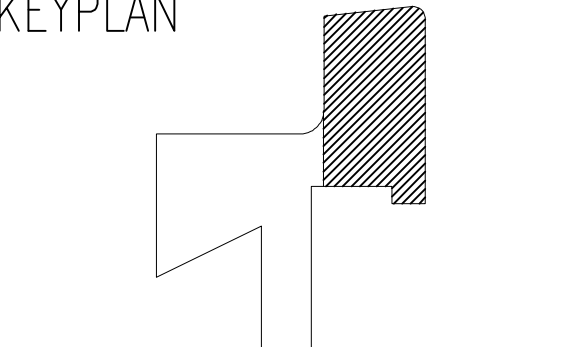


WEBSTER UNIV - INTER. SCIENCE BUILDING
8274 BIG BEND BLVD.
WEBSTER GROVES, MO

FIRE PROTECTION PLAN - LEVEL 4 - AREA A




SCALE: 1/8" = 1'-0"

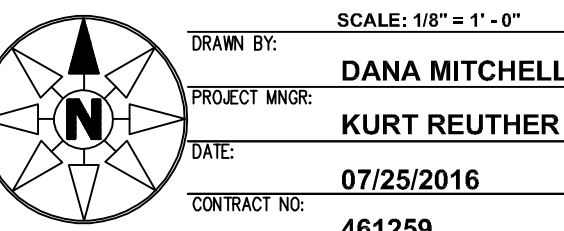

DRAWN BY: **DANA MITCHELL**
PROJECT MANAGER: **KURT REUTHER**
DATE: **07/25/2016**
CONTRACT NO: **461259**

CONSTRUCTION DOCUMENTS

FP-104.A

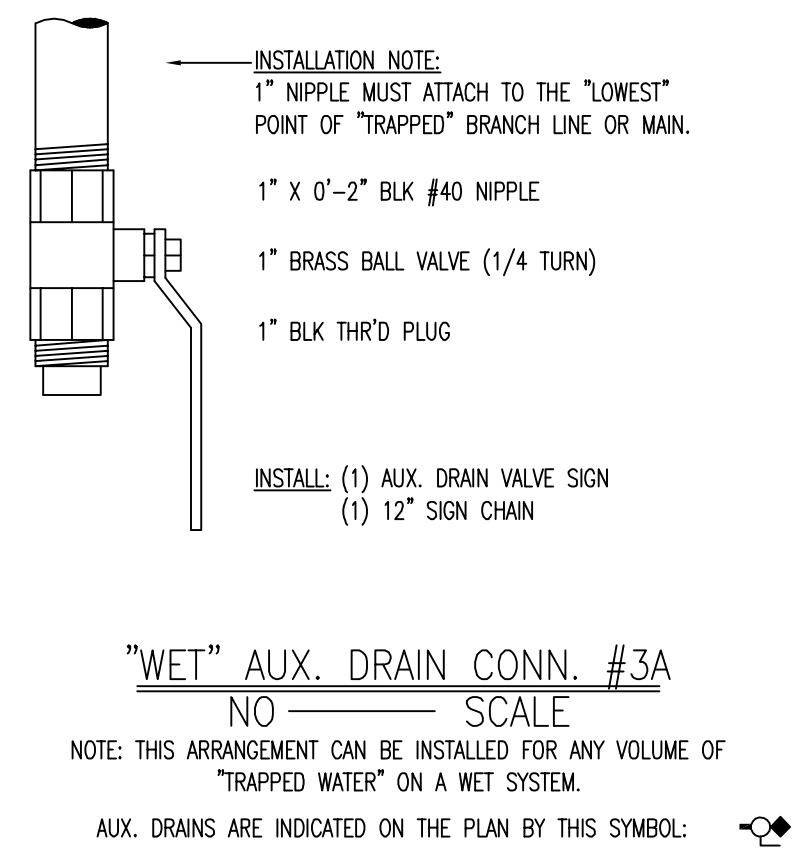

SPRINKLERS														
MAKE / VENDOR	MODEL	SIN	TYPE	RESPONSE TIME	THREAD SIZE	NOM "K"	CALCD COVERAGE	DEFLECT DISTANCE	TEMP.	FINISH	ESC.	WRENCH	SYMBOL	QUANTITY
Viking M	VK300	UPR	QR	1/2"	5.6	225 SQ FT	1-12"	155'	BRZ	N/A	10896W/8"			
Viking M	VK350	UPR	QR	3/4"	8.0	130 SQ FT	1-12"	200'	BRZ	N/A	10896W/8"			
Viking EC	VK450	UPR	QR	3/4"	8.0	130 SQ FT	1-12"	200'	WHI	CONCLD	10474W/8"			
Viking MIRAGE	VK464	PND	QR	1/2"	5.6	225 SQ FT	1-12"	155'	WHI	CONCLD	10474W/8"		27	
Viking MIRAGE	VK464	PND	QR	3/4"	8.0	130 SQ FT	1-12"	200'	WHI	CONCLD	10474W/8"			
Viking MIRAGE EC	VK454	PND	QR	3/4"	8.0	40 SQ FT	1-12"	155'	WHI	CONCLD	10474W/8"		18	
Viking EC	VK184	PND	QR	1"	5.6	225 SQ FT	1-12"	155'	WHI	DOME CNCLD	0755W/8"			
Viking M	VK305	HSW	QR	1/2"	5.6	196 SQ FT	4-6"	200'	BRZ	N/A	10896W/8"		2	
TOTAL SPRINKLERS ON THIS CONTRACT:													560	
TOTAL SPRINKLERS ON THIS SHEET:													48	

The design information and data contained on this electronic media is provided to you as an instrument of service, protected by copyright law and intended for use and reference relative only to the specific project they describe. J. F. Ahern Co. explicitly assumes no responsibility or liability for any other use of these electronic files whatsoever. The electronic files may not be copied, modified or released to a third party without the direct written permission of J. F. Ahern Co. Further, because transmission errors and read/write errors can occur and because electronic media stored can be modified by other parties intentionally or otherwise without notice of said modification, J. F. Ahern Co. cannot guarantee the accuracy of these files.





J. F. AHERN CO.
FIRE PROTECTION
CONTRACTORS
2675 Scott Ave., Suite C
St. Louis, MO 63103-3047
(314) 535-4544 p (314) 535-0144 f
www.jfahern.com

KEYPLAN

WEBSTER UNIV - INTER.
SCIENCE BUILDING
8274 BIG BEND BLVD.
WEBSTER GROVES, MO

**FIRE PROTECTION
PLAN - LEVEL 4 -
AREA B**

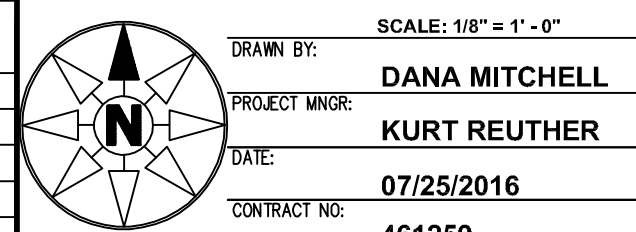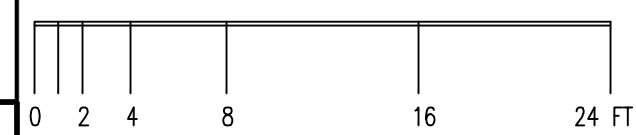

FP-104.B