

SYMBOLS AND ABBREVIATION LEGEND	
SYMBOL	DESCRIPTION
[PACP]	PREACTION RELEASE PANEL
[APS]	ALARM PRESSURE SWITCH
[LPS]	LOW AIR PRESSURE SWITCH
[SOL]	PRE-ACTION SPRINKLER SOLENOID VALVE
[TS]	TAMPER SWITCH
 133°	133° HEAT DETECTOR

KEYPLAN

AS-BUILTS

07/05/2017

[illegible]

The design information and data contained on this electronic media is provided to you as an instrument of service, protected by copyright law, and intended for use and reference relative only to the specific project they describe. J. F. Ahern Co. explicitly assumes no responsibility or liability for any other use of these electronic files whatsoever. The electronic files may not be copied, modified or released to a third party without the direct written permission of J. F. Ahern Co. Further, because of transmission errors and read/write errors can occur and because electronic media stored can be modified by other parties intentionally or otherwise without notice of said modification, J. F. Ahern Co. cannot guarantee the accuracy of these files.




J. F. AHERN CO.
FIRE PROTECTION
CONTRACTORS
2675 Scott Ave., Suite C
St. Louis, MO 63103-3047
(314) 535-4544 p (314) 535-0144 f
www.jfahern.com


WEBSTER UNIV - INTER
SCIENCE BUILDING
3274 BIG BEND BLVD.
WEBSTER GROVES, MO

FIRST FLOOR PLAN
VIEW LAYOUT

DRAWING IS PLOTTED CORRECTLY

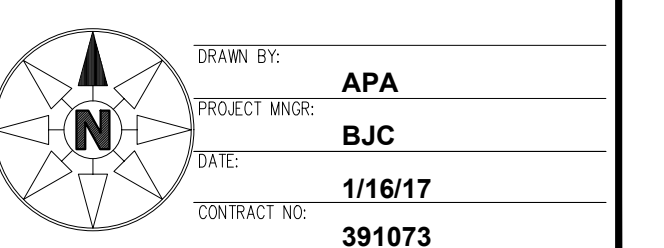

CONSTRUCTION DOCUMENTS

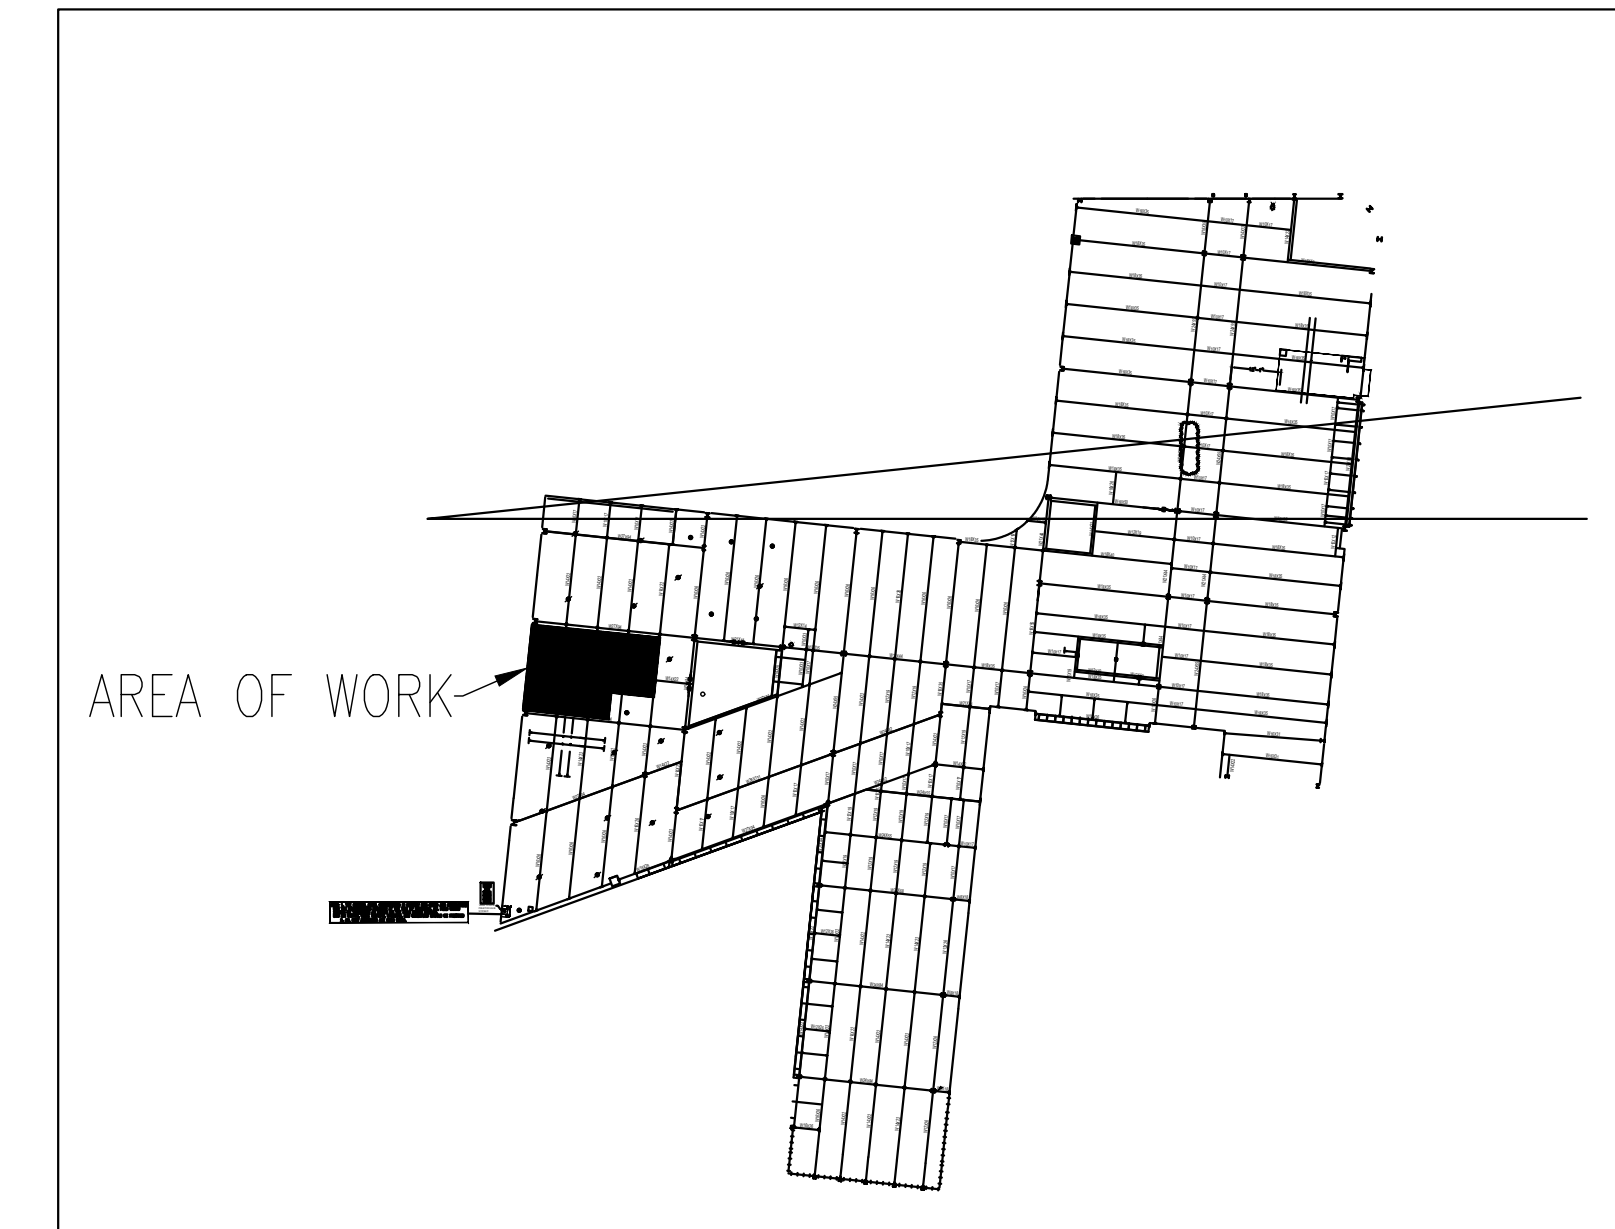FX-2

KEYPLAN
SCALE: N.T.S.



FIRST FLOOR PLAN VIEW
SCALE: 1/4" = 1'-0"